

F.A. RTE.	SECTION	COUNTY	TOTAL SHEETS	SHEET NO.
		ST. CLAIR	140	1
FED. ROAD DIST. NO.		ILLINOIS		

INDEX OF SHEETS

- 1 COVER SHEET
- 2 GENERAL NOTES
- 3-4 SUMMARY OF QUANTITIES
- 5 LOCATION MAP
- 6-9 TYPICAL SECTIONS
- 10-15 SCHEDULE OF QUANTITIES
- 16-19 ALIGNMENT - ALIGNMENT 1
- 20-24 ALIGNMENT - ALIGNMENT 2
- 25 ALIGNMENT - ALIGNMENT 3
- 26-36 PLAN AND PROFILE SHEETS - ALIGNMENT 1
- 37-52 PLAN AND PROFILE SHEETS - ALIGNMENT 2
- 53-55 PLAN AND PROFILE SHEETS - ALIGNMENT 3
- 56-58 PAVEMENT MARKING & SIGNAGE PLAN SHEETS - ALIGNMENT 1
- 59-62 PAVEMENT MARKING & SIGNAGE PLAN SHEETS - ALIGNMENT 2
- 63 PAVEMENT MARKING & SIGNAGE PLAN SHEETS - ALIGNMENT 3
- 64-65 GEOMETRIC DETAIL
- 66-68 MISCELLANEOUS DETAILS
- 69 BOX CULVERT DETAILS
- 70 FLASHING BEACON ELECTRICAL PLAN AND DETAILS
- 71 PEDESTRIAN CROSSING ELECTRICAL ON LINE DIAGRAM
- 72-91 CROSS SECTIONS - ALIGNMENT 1
- 92-131 CROSS SECTIONS - ALIGNMENT 2
- 132-140 CROSS SECTIONS - ALIGNMENT 3


ST. CLAIR COUNTY TRANSIT DISTRICT
PLANS FOR PROPOSED
ORCHARD LOOP TRAIL
PHASE 1
ST. CLAIR COUNTY
2018

IDOT HIGHWAY STANDARDS
(INSERTED AT END OF DRAWING SET)


- 000001-06 STANDARD SYMBOLS, ABBREVIATIONS AND PATTERNS
- 001001-02 AREAS OF REINFORCEMENT BARS
- 001006 DECIMAL OF AN INCH AND OF A FOOT
- 280001-07 TEMPORARY EROSION CONTROL SYSTEMS
- 424001-10 PERPENDICULAR CURB RAMPS FOR SIDEWALKS
- 424026-02 ENTRANCE/ALLEY PEDESTRIAN CROSSINGS
- 542301-03 PRECAST REINFORCED CONCRETE FLARED END SECTION
- 542401-03 METAL FLARED END SECTION FOR PIPE CULVERTS
- 602301-04 INLET - TYPE A
- 604036-03 GRATE TYPE 8
- 606001-07 CONCRETE CURB TYPE B AND COMBINATION CONCRETE CURB AND GUTTER
- 664001-02 CHAIN LINK FENCE
- 701001-02 OFF-ROAD OPERATIONS, 2L, 2W, MORE THAN 15' AWAY
- 701006-05 OFF-ROAD OPERATIONS, 2L, 2W, 15' TO 24" FROM PAVEMENT EDGE
- 701301-04 LANE CLOSURE, 2L, 2W, SHORT TERM OPERATIONS
- 701306-04 LANE CLOSURE, 2L, 2W, SLOW MOVING OPERATIONS DAY ONLY
- 701501-06 URBAN LANE CLOSURE, 2L, 2W, UNDIVIDED
- 701801-06 SIDEWALK, CORNER OR CROSSWALK CLOSURE
- 701901-07 TRAFFIC CONTROL DEVICES
- 720001-01 SIGN PANEL MOUNTING DETAILS
- 720006-04 SIGN PANEL ERECTION DETAILS
- 728001-01 TELESCOPING STEEL SIGN SUPPORT
- 780001-05 TYPICAL PAVEMENT MARKINGS
- 805001-01 ELECTRICAL SERVICE INSTALLATION DETAILS
- 814001-03 HANDHOLES
- 873001-02 TRAFFIC SIGNAL GROUNDING & BONDING
- 876001-04 PEDESTRIAN PUSH BUTTON POST
- 878001-10 CONCRETE FOUNDATION DETAILS
- 880006-01 TRAFFIC SIGNAL MOUNTING DETAILS
- B.L.R. 22-7 TYP. APP. OF TRAFFIC CONTROL DEVICES FOR CONST. ON RURAL LOCAL HWYS



LOCATION OF SECTION INDICATED THUS:

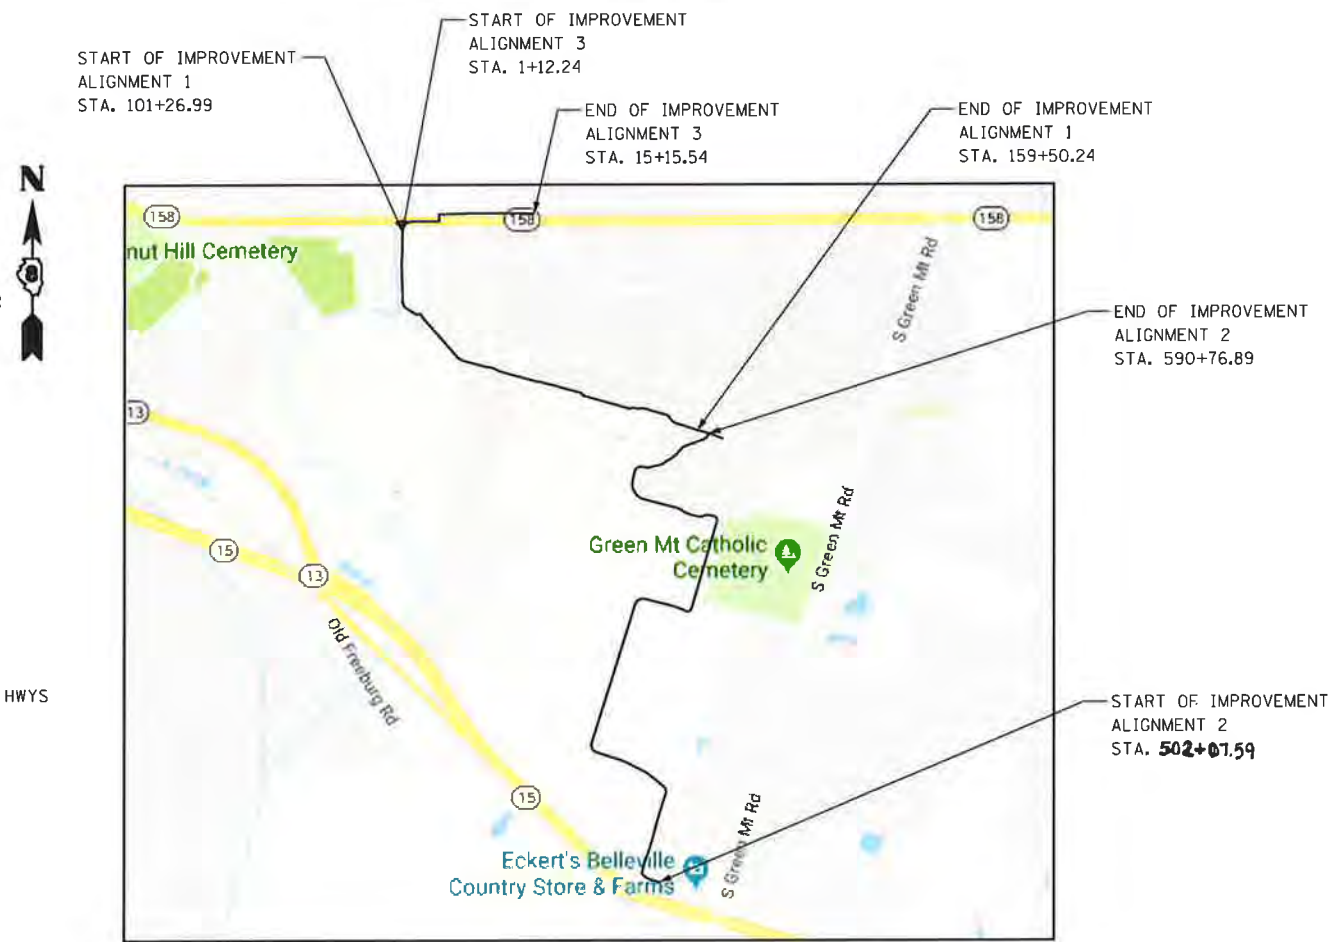

NOT TO SCALE

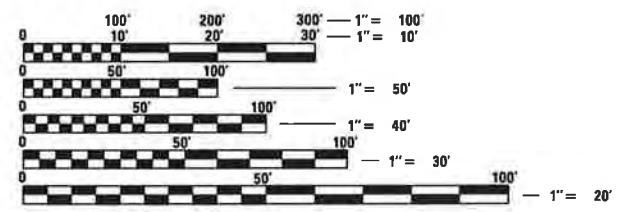

FULL SIZE PLANS HAVE BEEN PREPARED USING STANDARD ENGINEERING SCALES. REDUCED SIZED PLANS WILL NOT CONFORM TO STANDARD SCALES. IN MAKING MEASUREMENTS ON REDUCED PLANS, THE ABOVE SCALES MAY BE USED.

GROSS LENGTH = 16,290.23' (3.085 MILES)
NET LENGTH = 14,688.23' (2.782 MILES)

ALIGNMENT 1 GROSS LENGTH = 5823.25' (1.103 MILES)
ALIGNMENT 2 GROSS LENGTH = 9063.67' (1.717 MILES)
ALIGNMENT 3 GROSS LENGTH = 1403.31' (0.266 MILES)

Kenneth Sharkey
KENNETH SHARKEY
SCCTD
DATE 4/2/18

Chris Eckert
CHRIS ECKERT
ECKERT LAND CO.
DATE 3/30/18



Jeffrey R. Reis
JEFFREY R. REIS, P.E.
LICENSE NO. 062-063262
EXPIRATION DATE 11-30-2019


J.U.L.I.E.
JOINT UTILITY LOCATION INFORMATION FOR EXCAVATION
1-800-892-0123
OR 811

St Clair
County
Transit
District

**THOUVENOT,
WADE &
MOERCHEN, INC.**
SWANSEA • WATERLOO • EDWARDSVILLE • ST. LOUIS • ST. CHARLES

CORPORATE OFFICE
4940 Old Collinsville Road
Swansea, Illinois 62226
Tel: 618.624.4488
Fax: 618.624.6688

EXCEPTIONAL SERVICE.
NOTHING LESS.

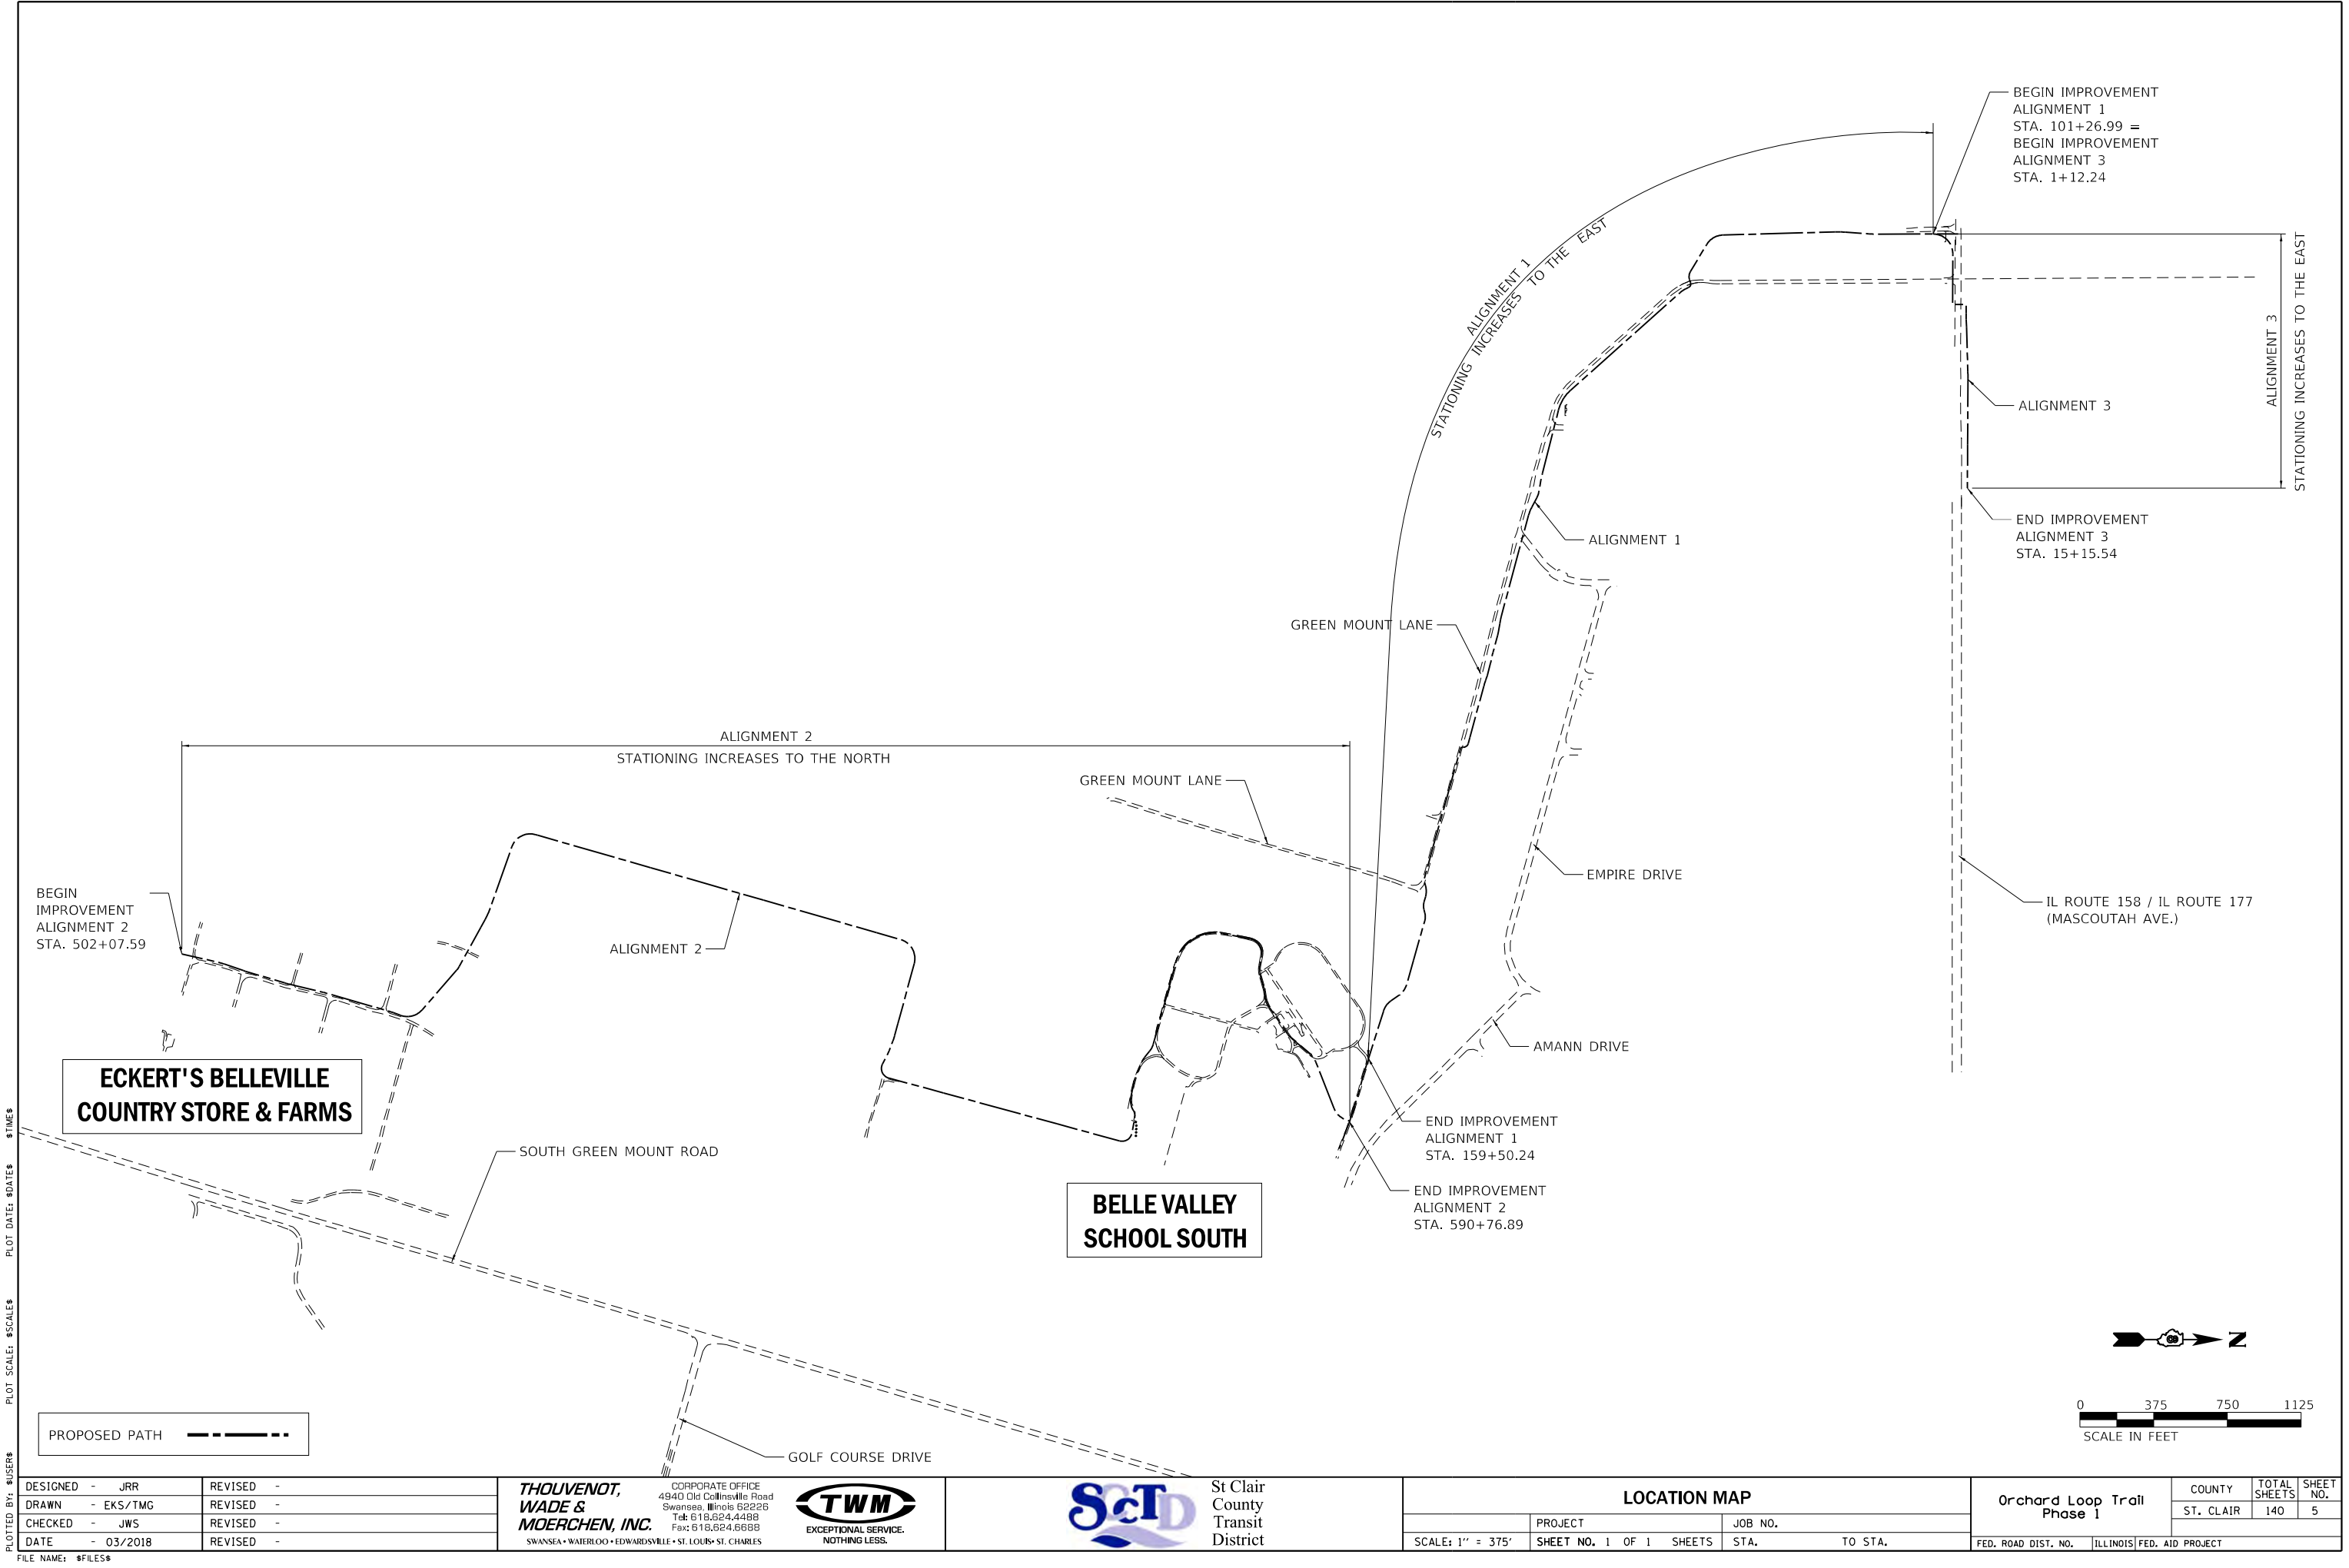



DESIGNED	-	JRR	REVISED	-
DRAWN	-	EKS/TMG	REVISED	-
CHECKED	-	JWS	REVISED	-
DATE	-	03/2018	REVISED	-

THOUVENOT, WADE & MOERCHEN, INC.
CORPORATE OFFICE
4940 Old Collinsville Road
Swansea, Illinois 62226
Tel: 618.624.4488
Fax: 618.624.6688
SWANSEA • WATERLOO • EDWARDSVILLE • ST. LOUIS • ST. CHARLES



LOCATION MAP			
PROJECT		JOB NO.	
SCALE: 1" = 375'	SHEET NO. 1 OF 1 SHEETS	STA.	TO STA.


Orchard Loop Trail Phase 1		COUNTY	TOTAL SHEETS	SHEET NO.
		ST. CLAIR	140	5
FED. ROAD DIST. NO.	ILLINOIS	FED. AID PROJECT		

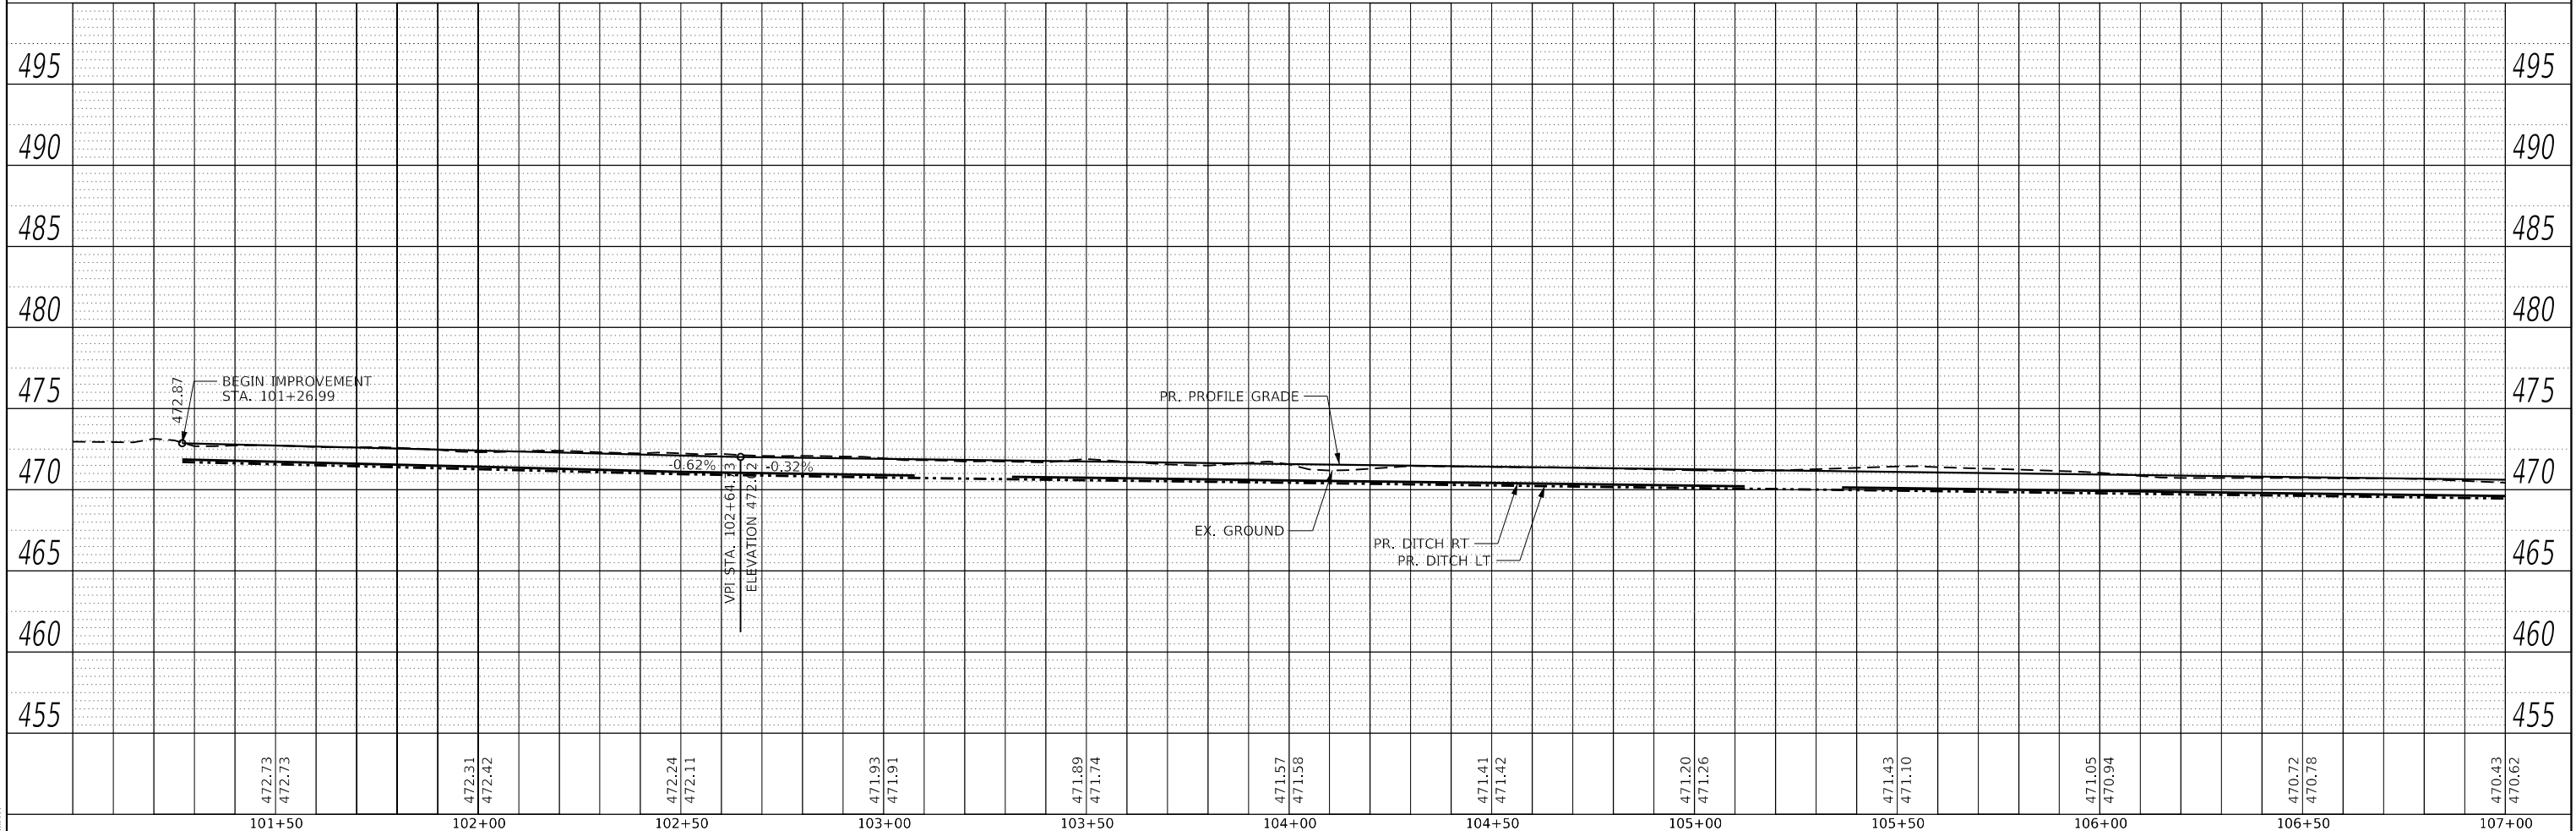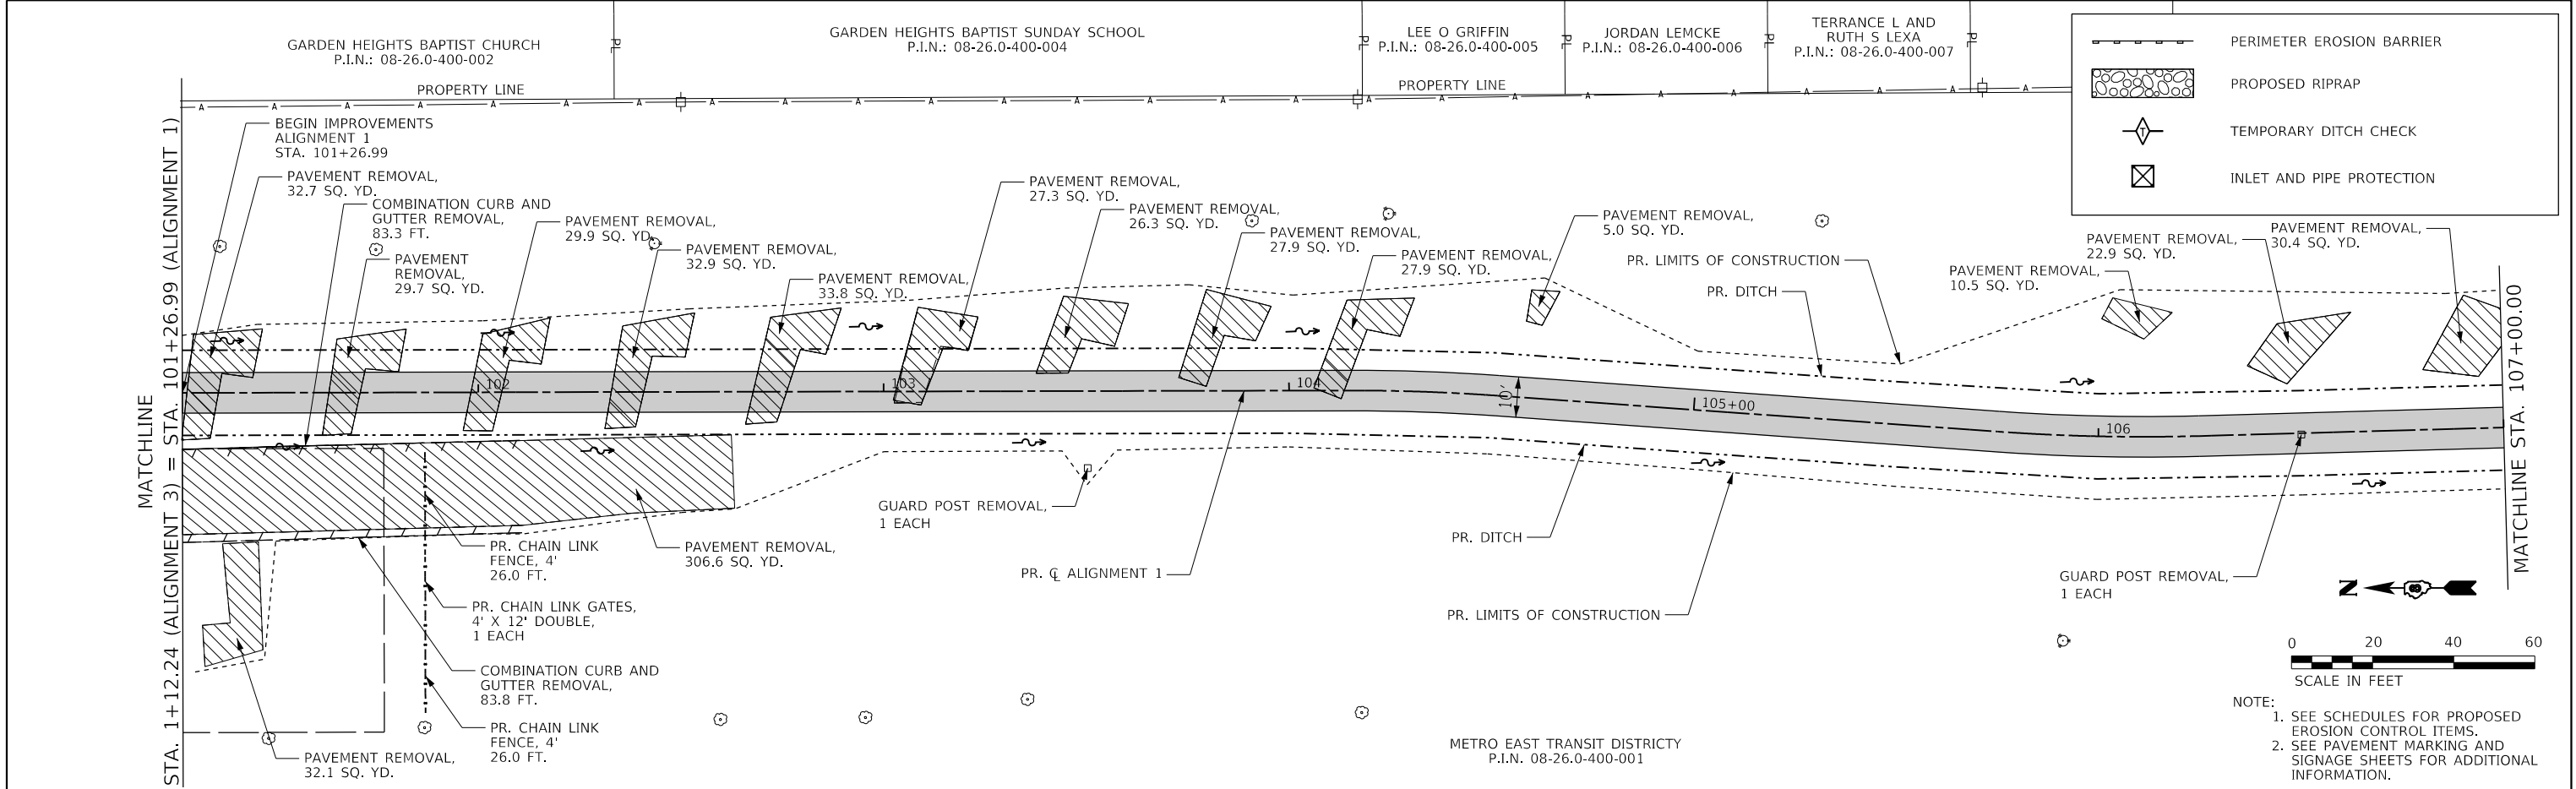



DESIGNED - JRR	REVISED -	THOUVENOT, WADE & MOERCHEN, INC. CORPORATE OFFICE 4940 Old Collinsville Road Swansea, Illinois 62226 Tel: 618.824.4488 Fax: 618.824.6688 SWANSEA • WATERLOO • EDWARDSVILLE • ST. LOUIS • ST. CHARLES	 EXCEPTIONAL SERVICE. NOTHING LESS.	 St Clair County Transit District	PLAN AND PROFILE ALIGNMENT 1			Orchard Loop Trail Phase 1		COUNTY	TOTAL SHEETS	SHEET NO.	
DRAWN - EKS/TMG	REVISED -									ST. CLAIR	140	26	
CHECKED - JWS	REVISED -				PROJECT					JOB NO.			
DATE - 03/2018	REVISED -				SCALE: 1" = 20'					SHEET NO. 1 OF 11 SHEETS			STA. 101+26.99 TO STA. 107+00.00



FILE NAME: 130149-PlnPr f04.dgn



PLOTTED BY: esmith
FILE NAME: 130149-PinPr f04.dgn

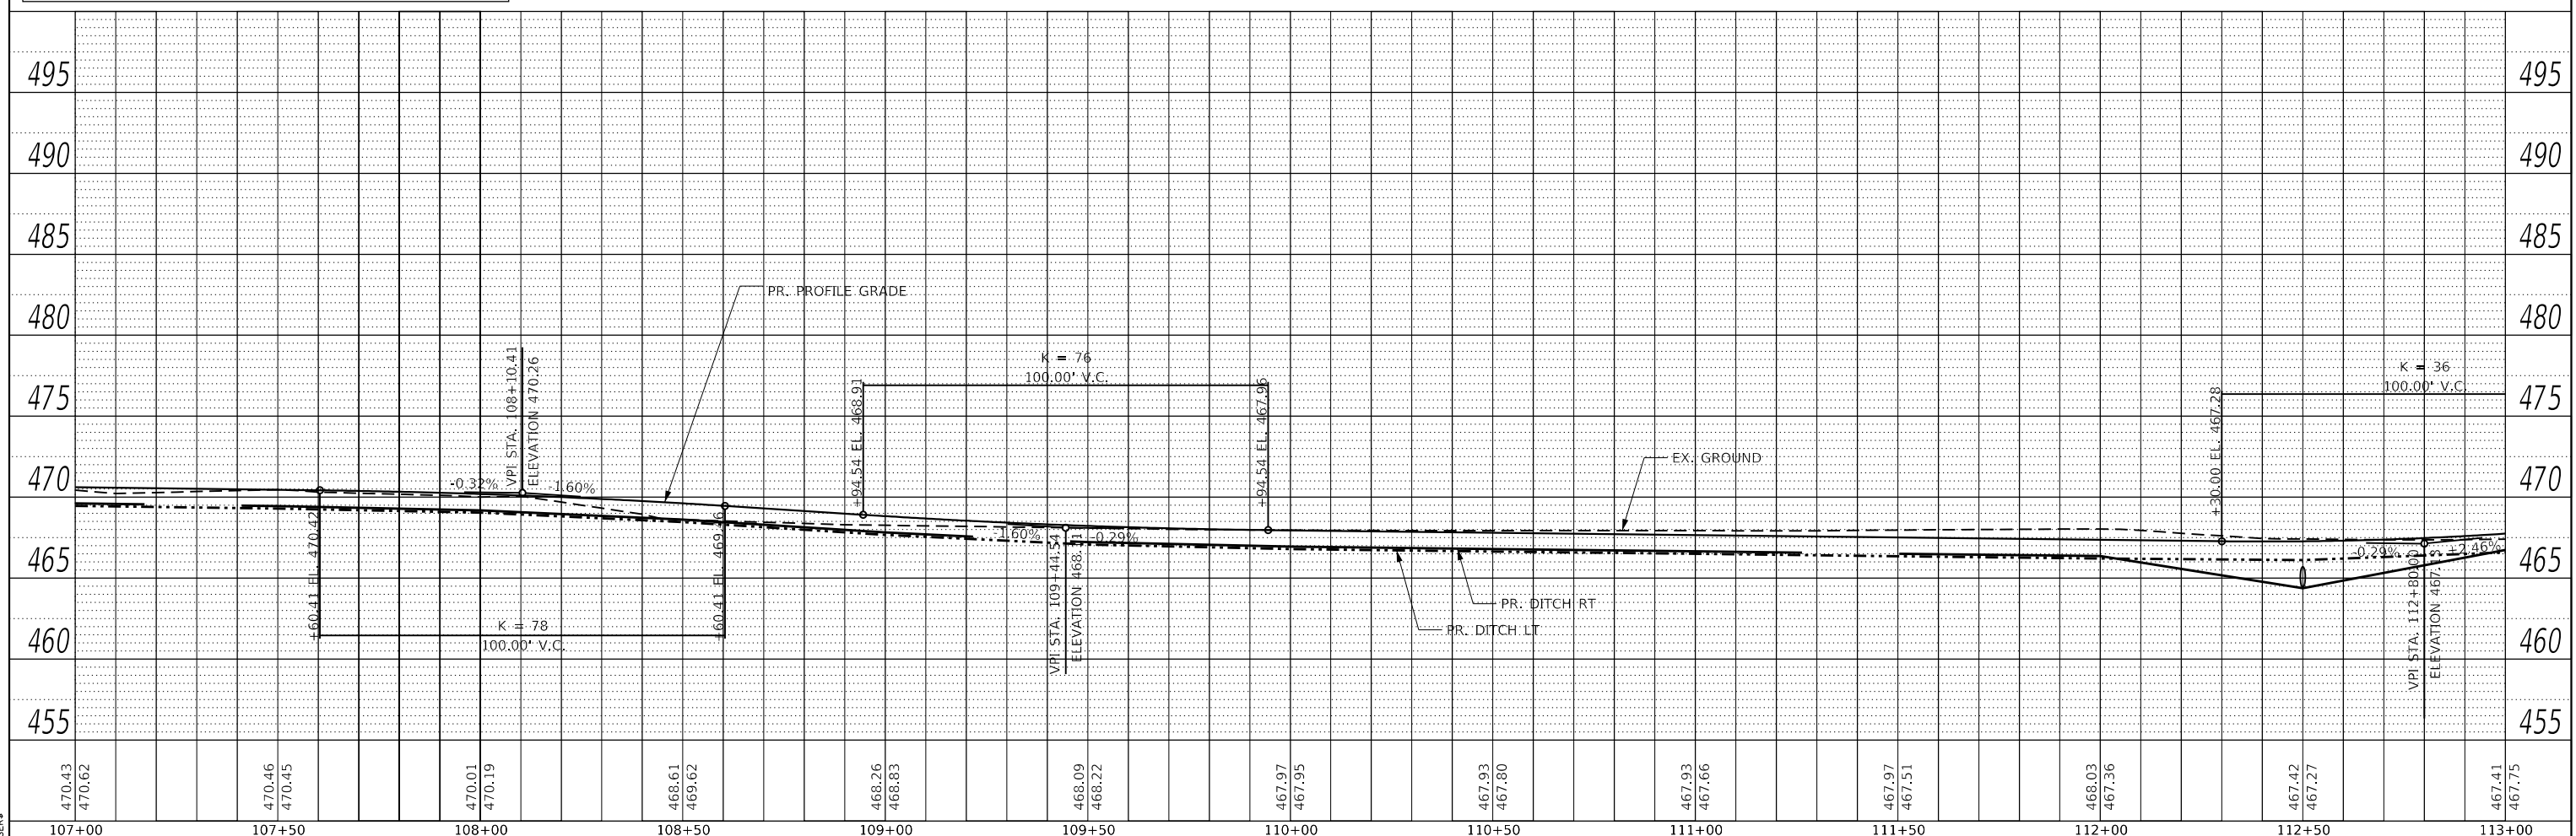



DESIGNED - JRR	REVISED -	THOUVENOT, WADE & MOERCHEN, INC. SWANSEA • WATERLOO • EDWARDSVILLE • ST. LOUIS • ST. CHARLES	 EXCEPTIONAL SERVICE. NOTHING LESS.	 St Clair County Transit District	PLAN AND PROFILE ALIGNMENT 1			Orchard Loop Trail Phase 1		COUNTY	TOTAL SHEETS	SHEET NO.	
DRAWN - EKS/TMG	REVISED -									ST. CLAIR	140	27	
CHECKED - JWS	REVISED -												
DATE - 03/2018	REVISED -							SCALE: 1" = 20'	SHEET NO. 2 OF 11 SHEETS	STA. 107+00.00 TO STA. 113+00.00	FED. ROAD DIST. NO.	ILLINOIS	FED. AID PROJECT

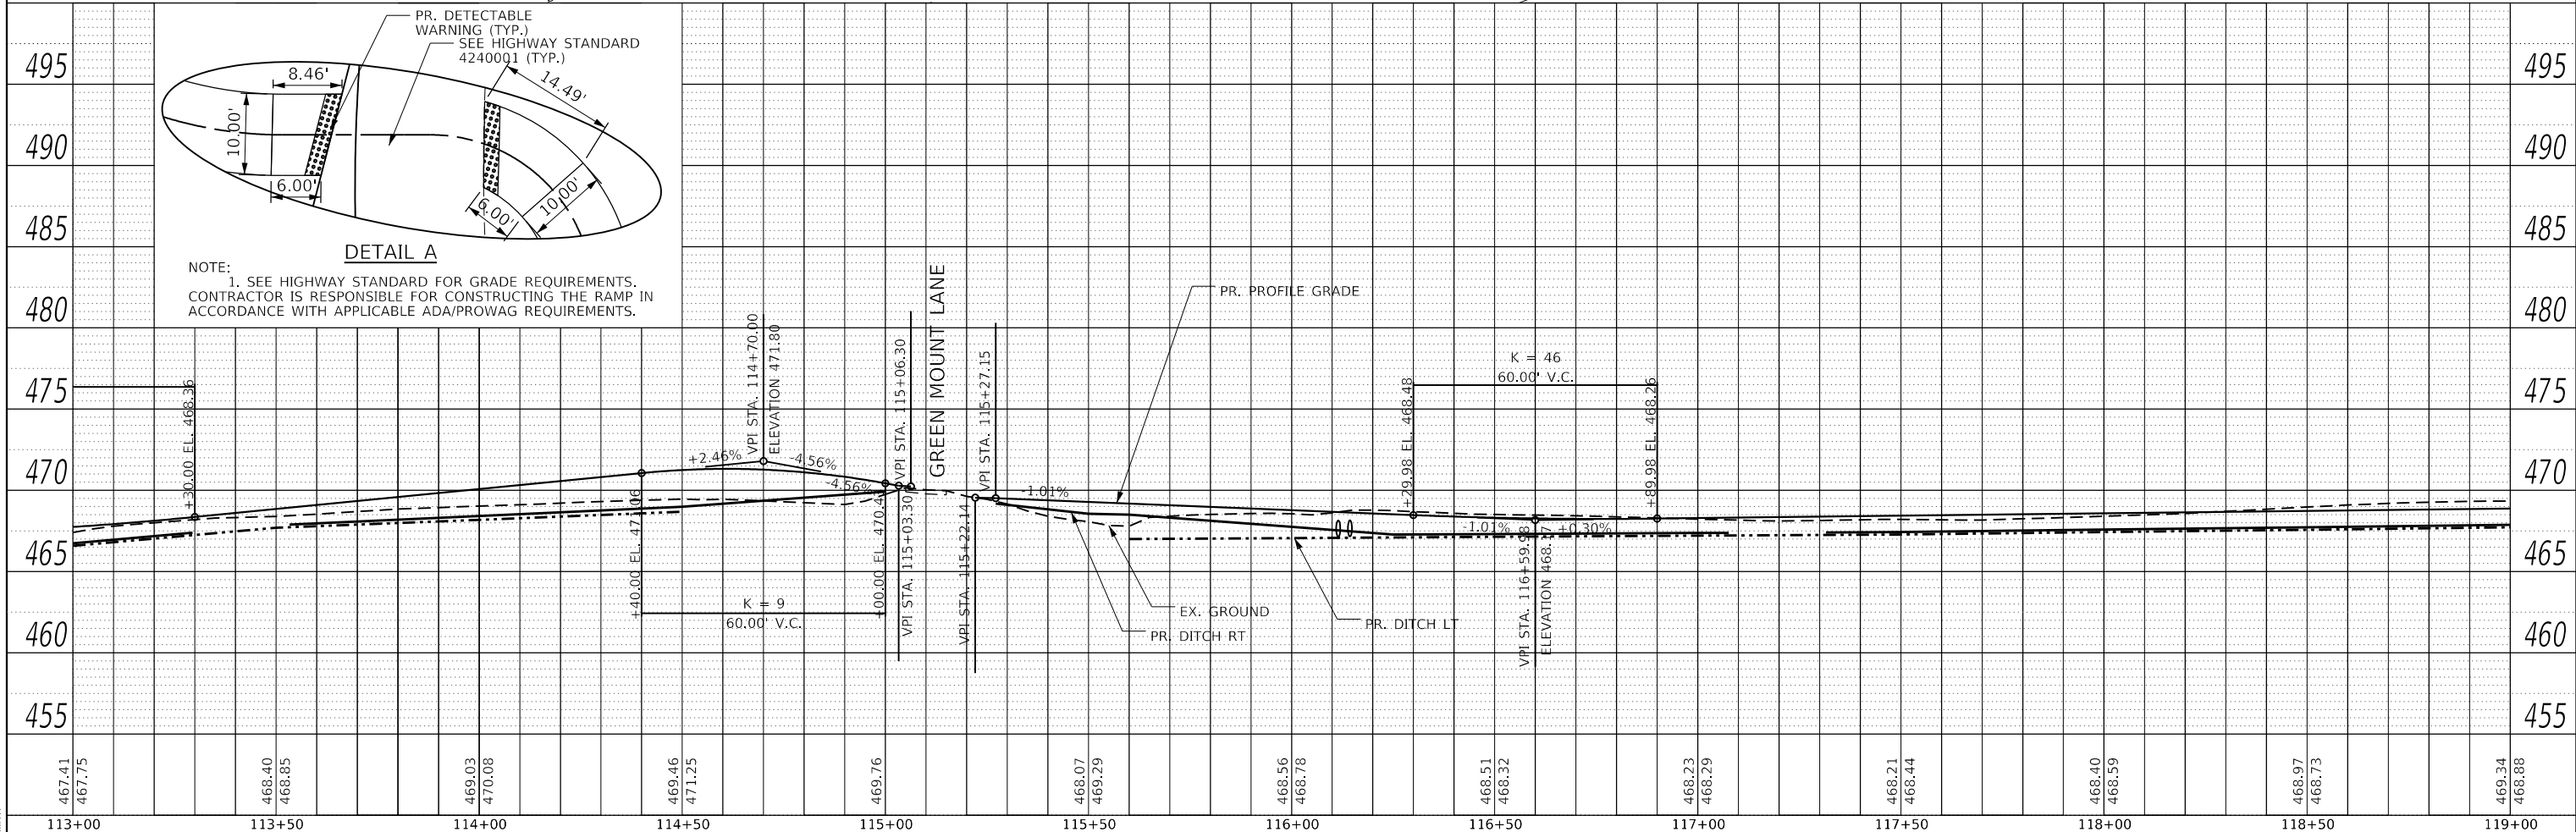
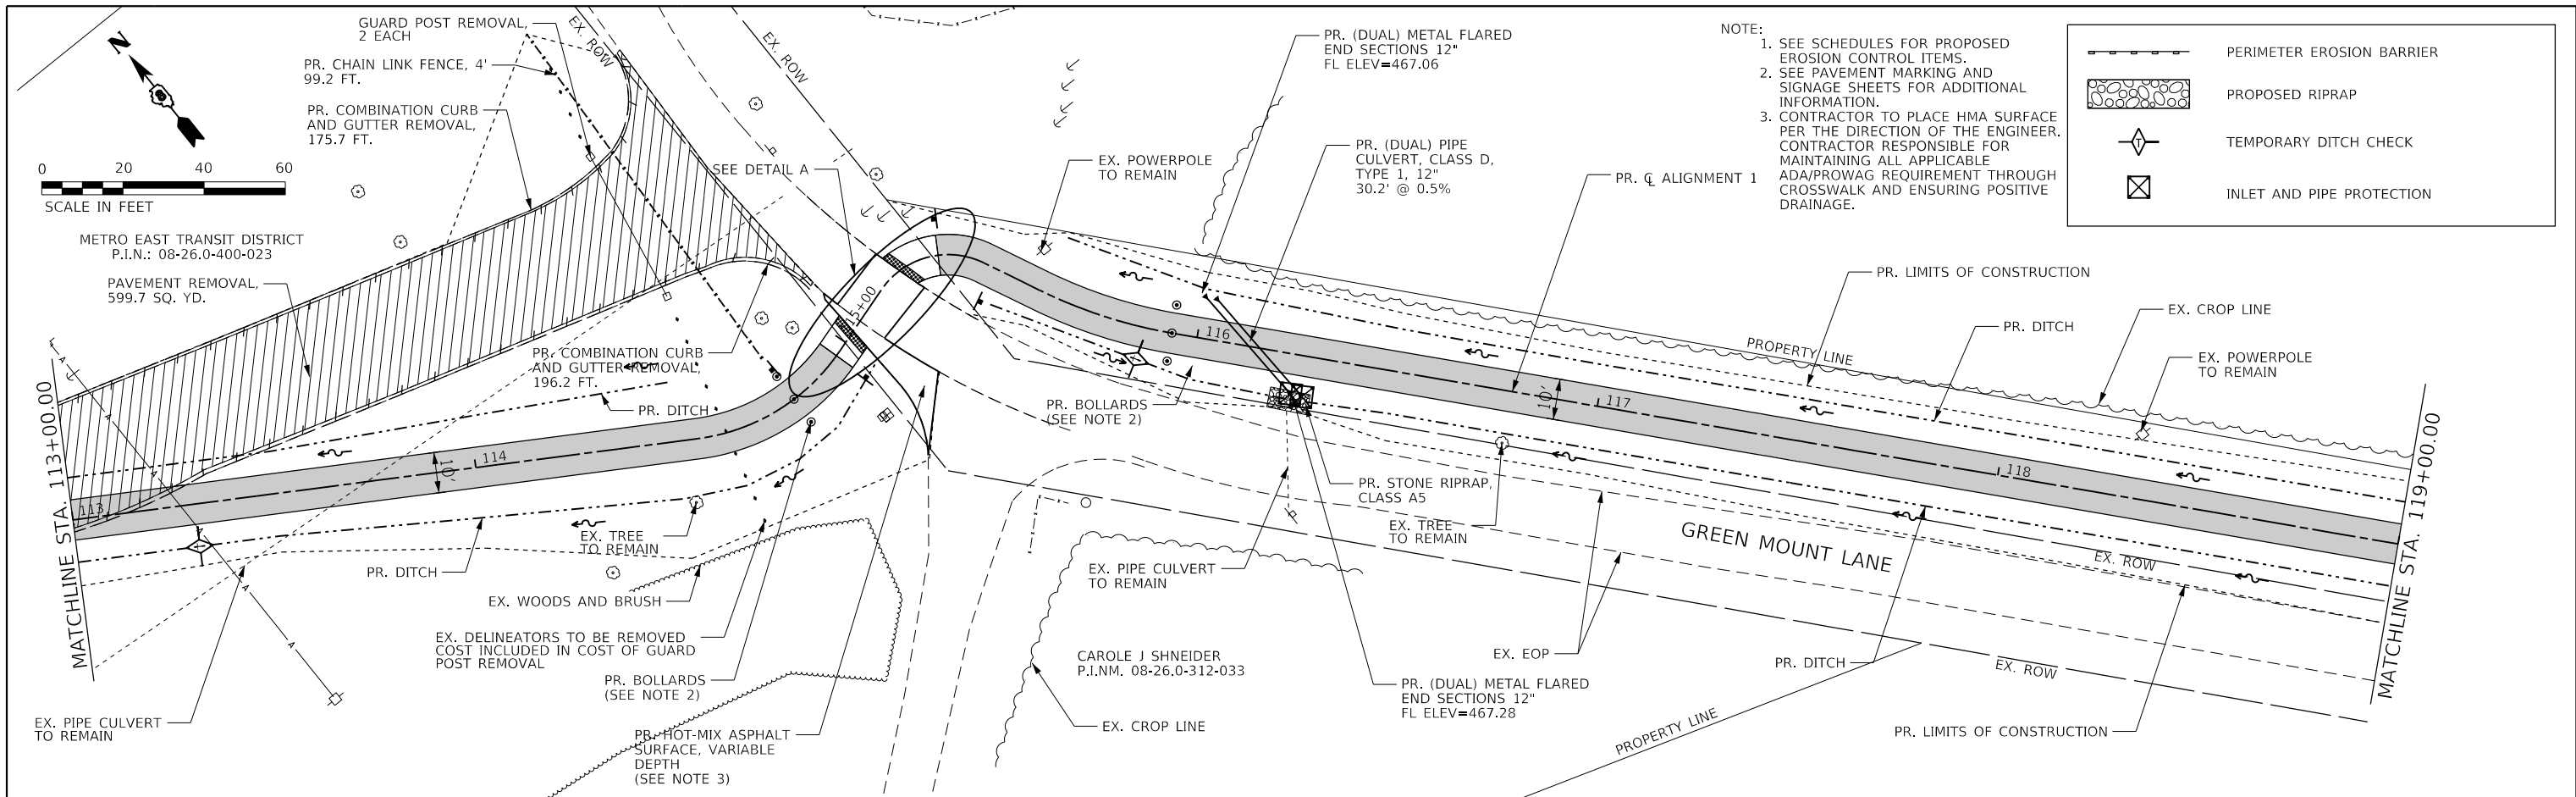


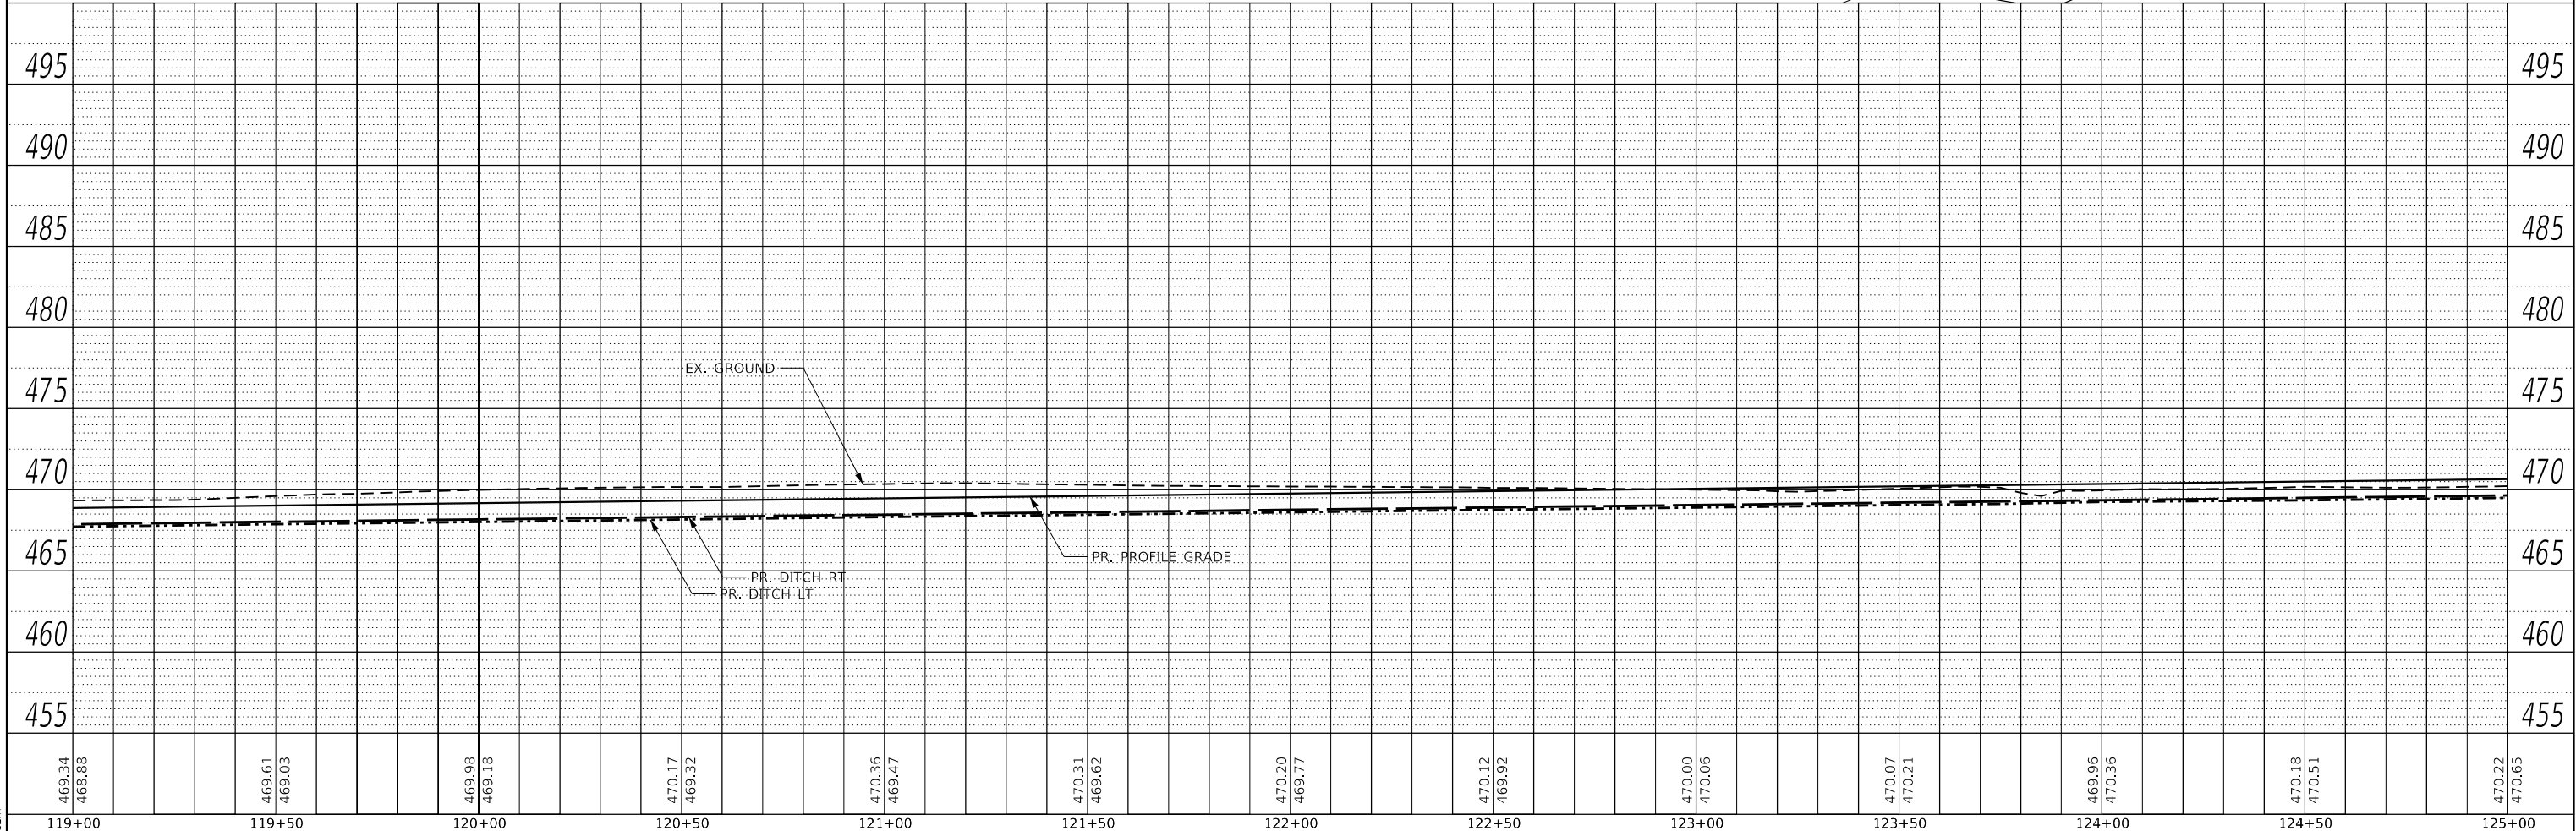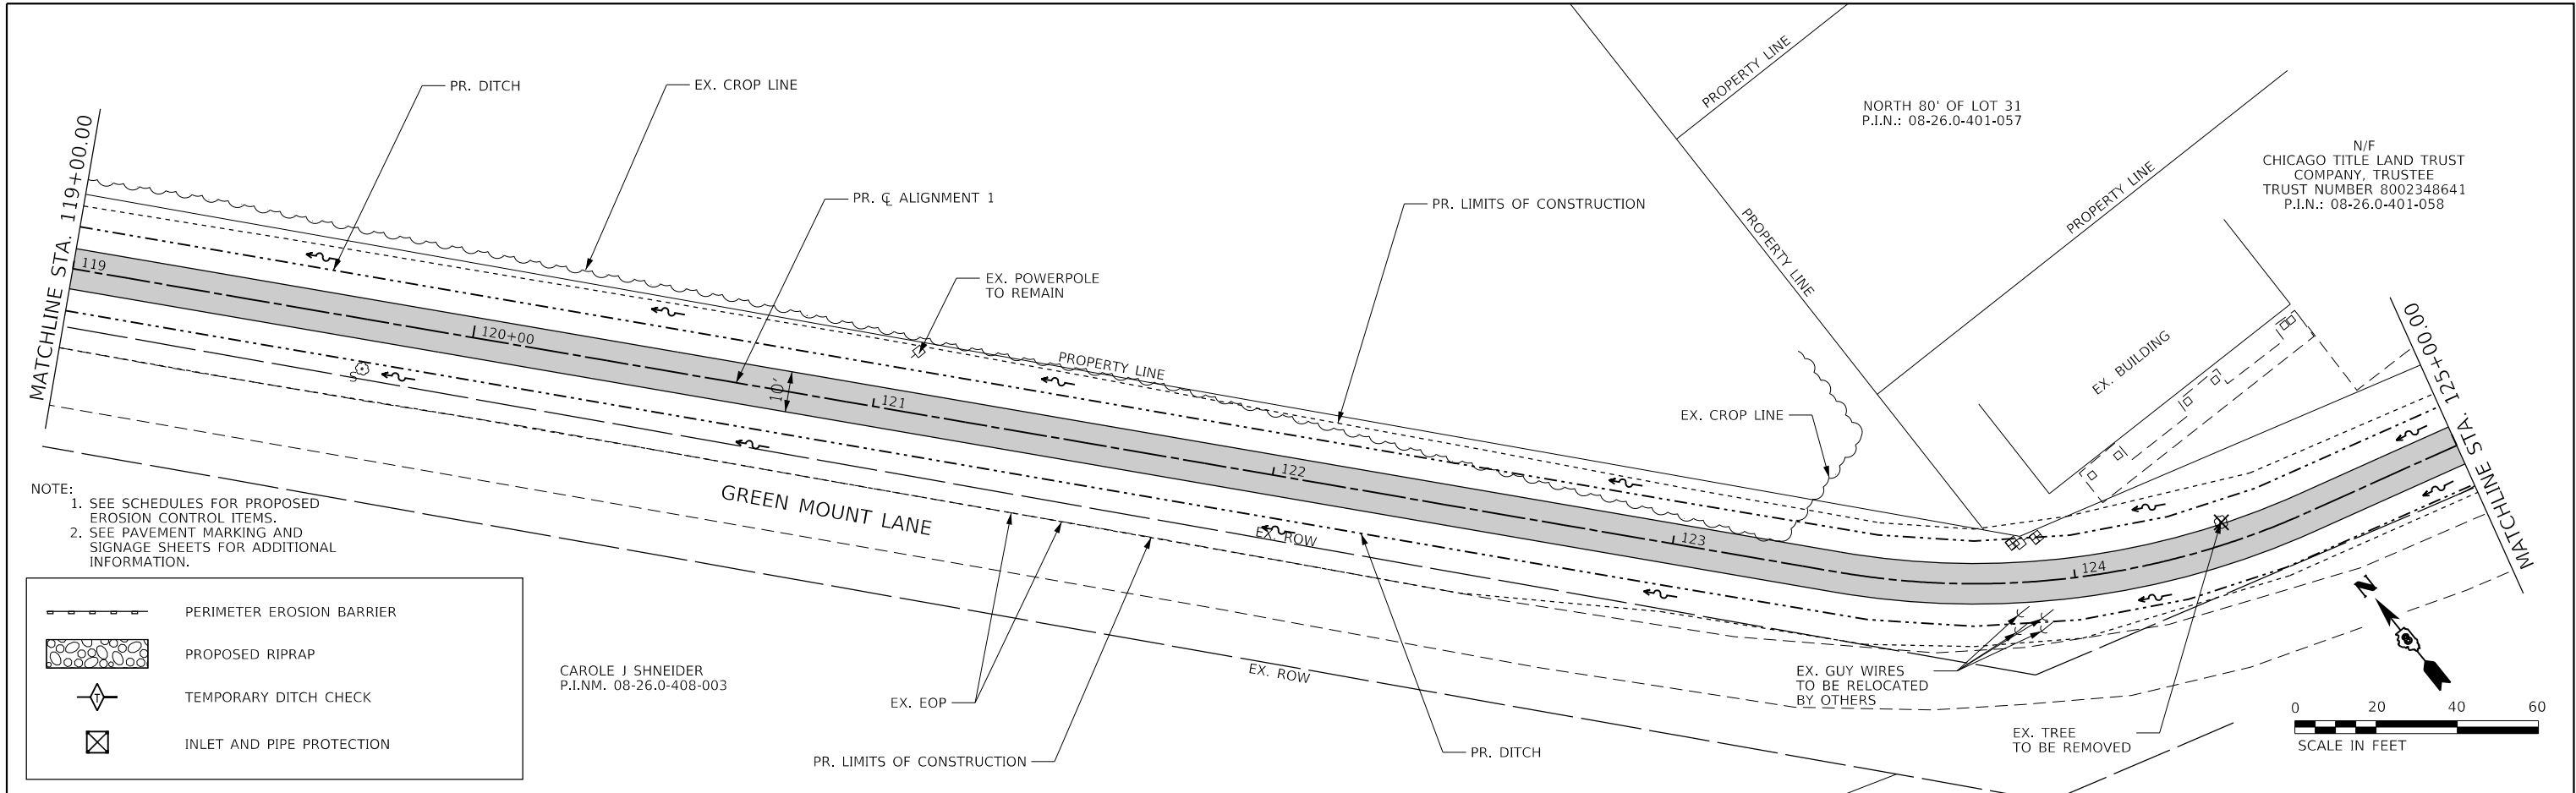

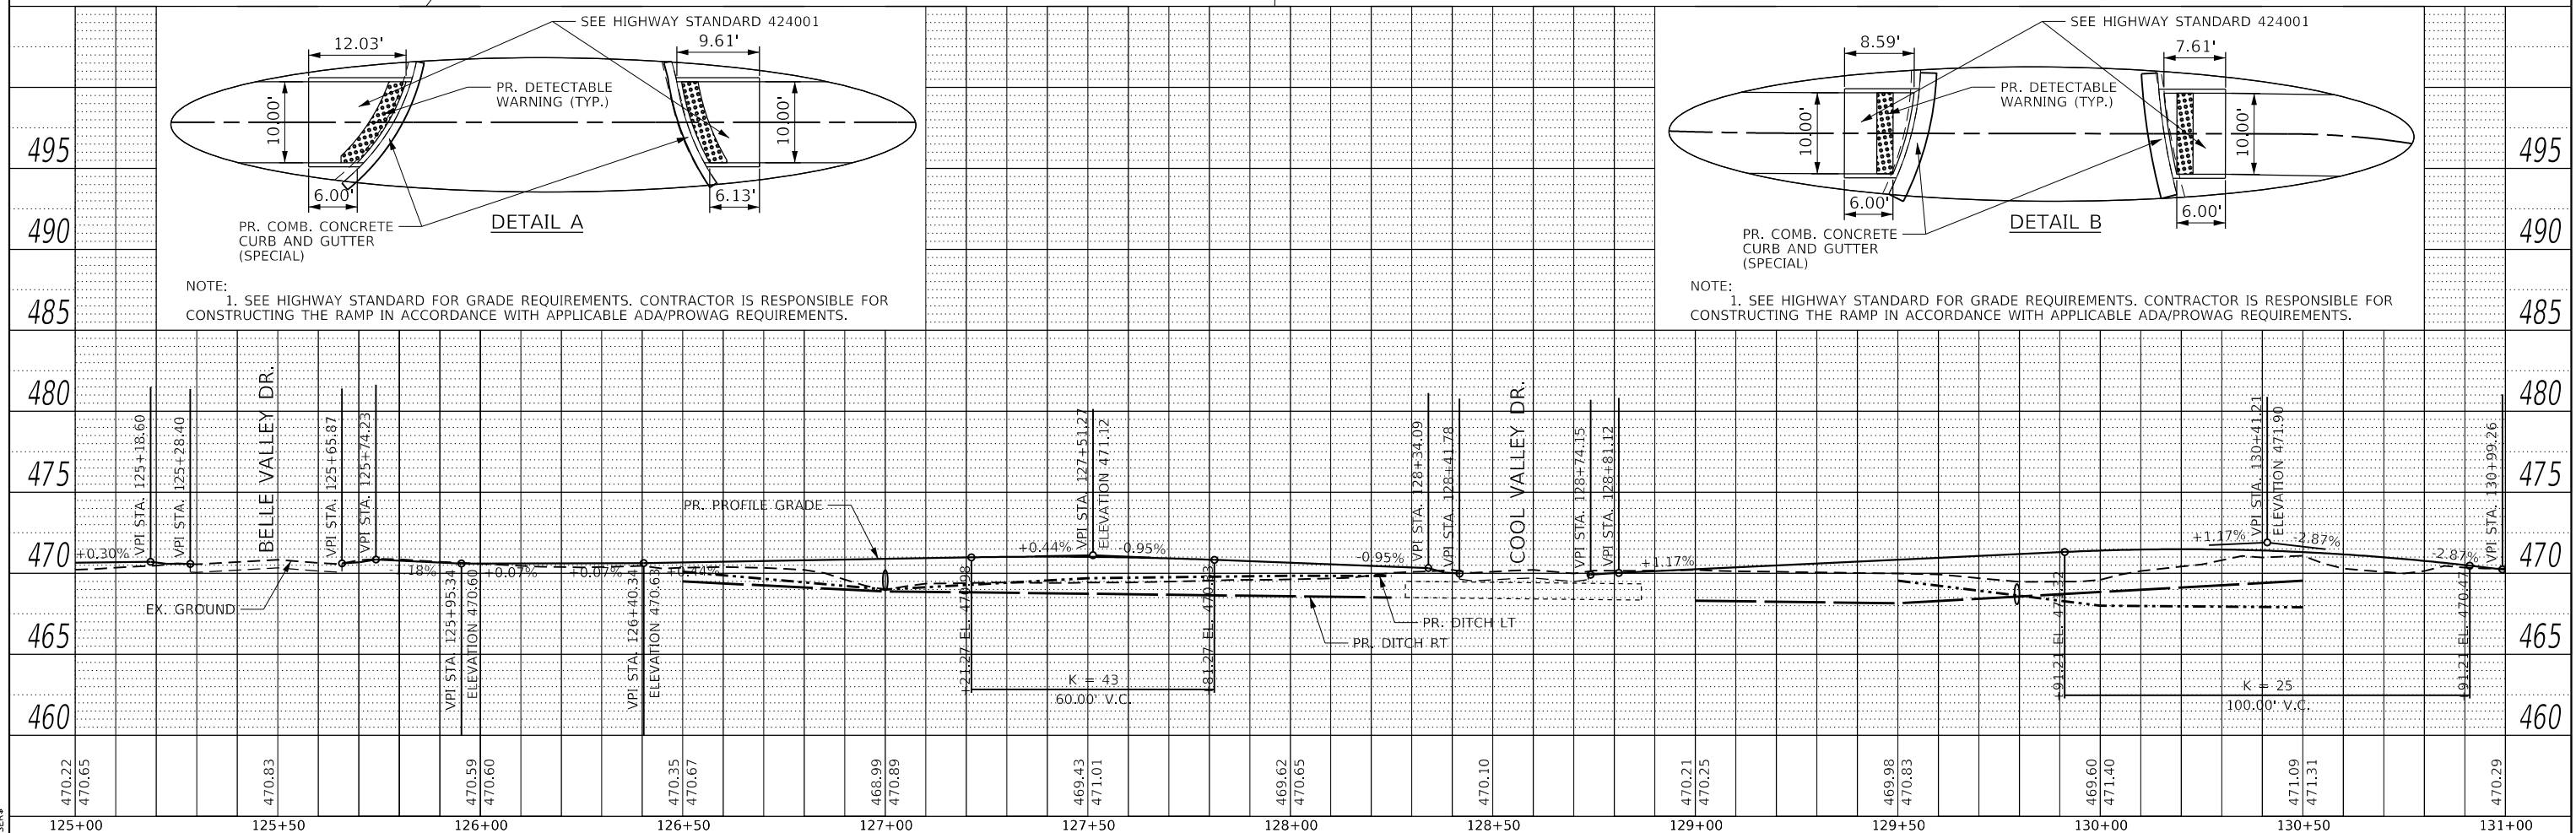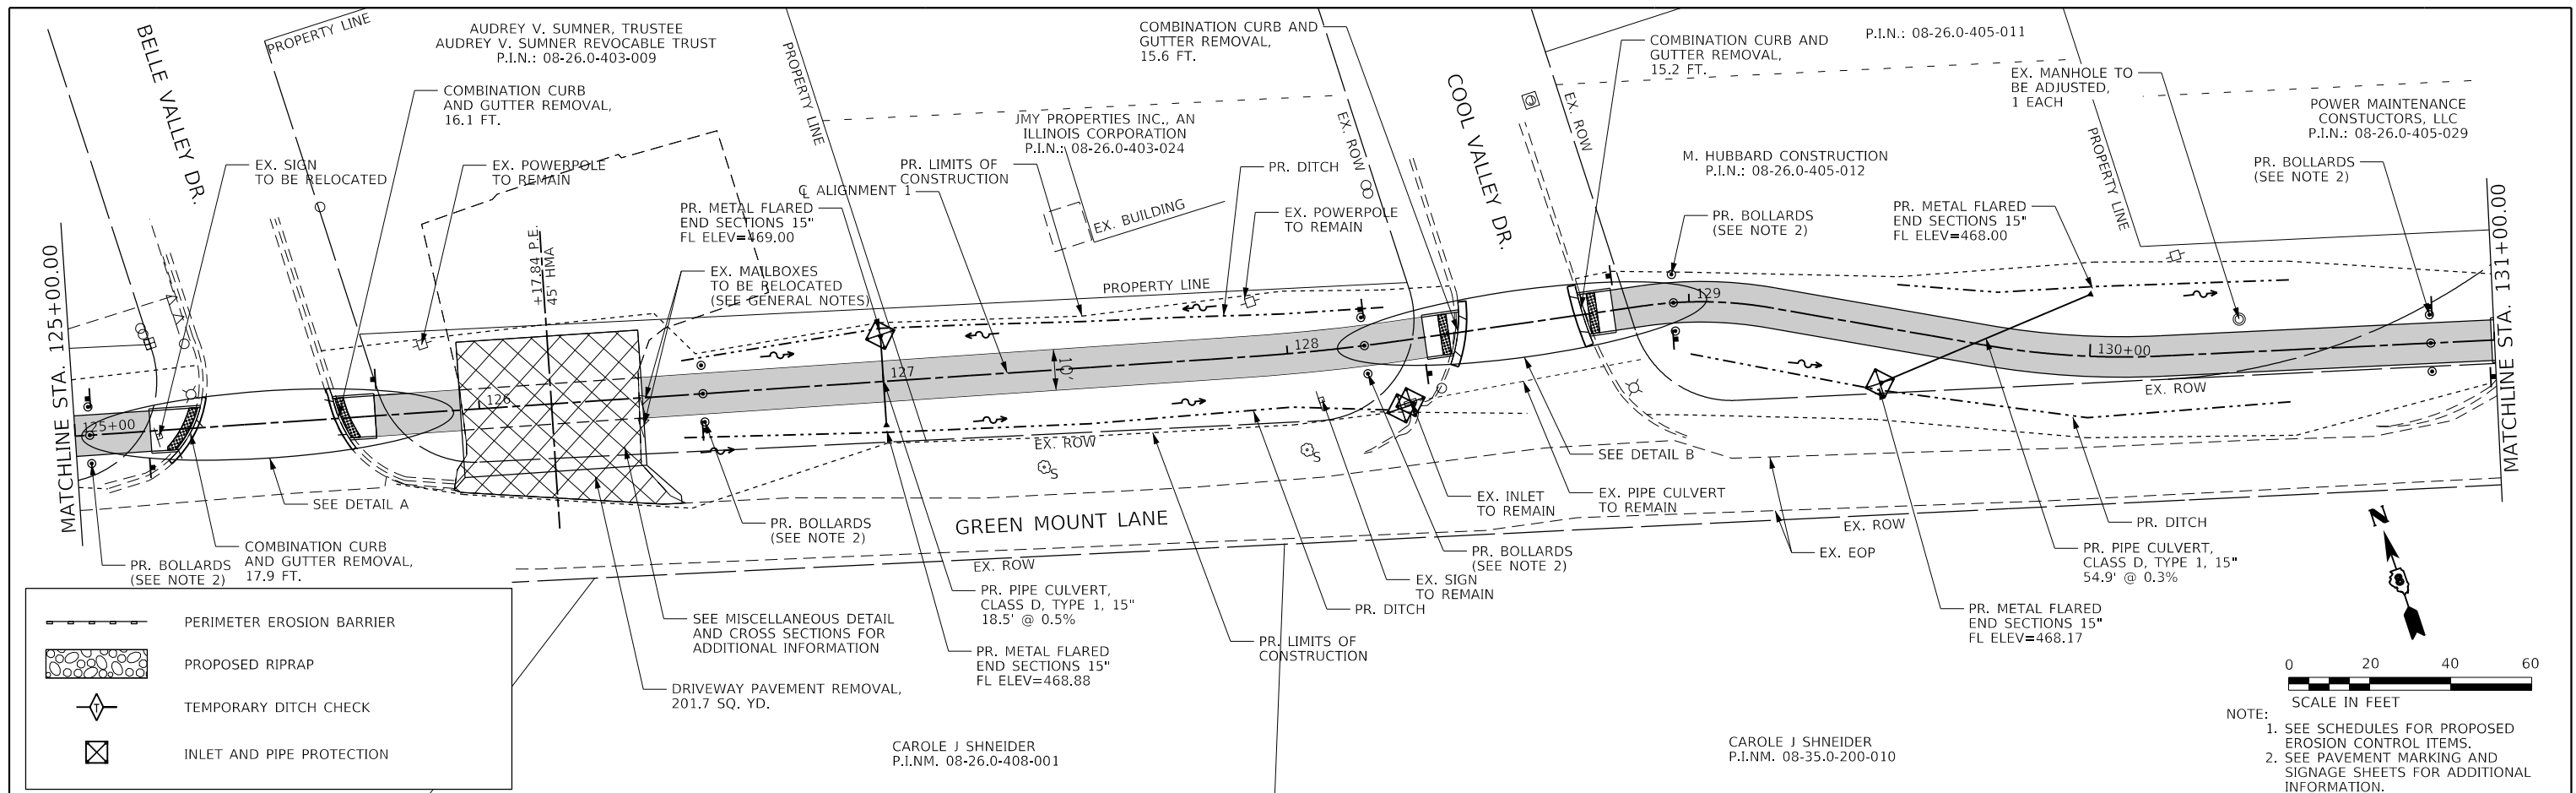

DESIGNED - JRR	REVISED -	THOUVENOT, WADE & MOERCHEN, INC. CORPORATE OFFICE 4940 Old Collinsville Road Swansea, Illinois 62226 Tel: 618.624.4488 Fax: 618.624.6688 SWANSEA • WATERLOO • EDWARDSVILLE • ST. LOUIS • ST. CHARLES	 EXCEPTIONAL SERVICE. NOTHING LESS.	 St Clair County Transit District	PLAN AND PROFILE ALIGNMENT 1			Orchard Loop Trail Phase 1	COUNTY	TOTAL SHEETS	SHEET NO.
DRAWN - EKS/TMG	REVISED -								ST. CLAIR	140	30
CHECKED - JWS	REVISED -				PROJECT JOB NO.						
DATE - 03/2018	REVISED -				SCALE: 1" = 20' SHEET NO. 5 OF 11 SHEETS STA. 125+00.00 TO STA. 131+00.00				FED. ROAD DIST. NO. ILLINOIS FED. AID PROJECT		

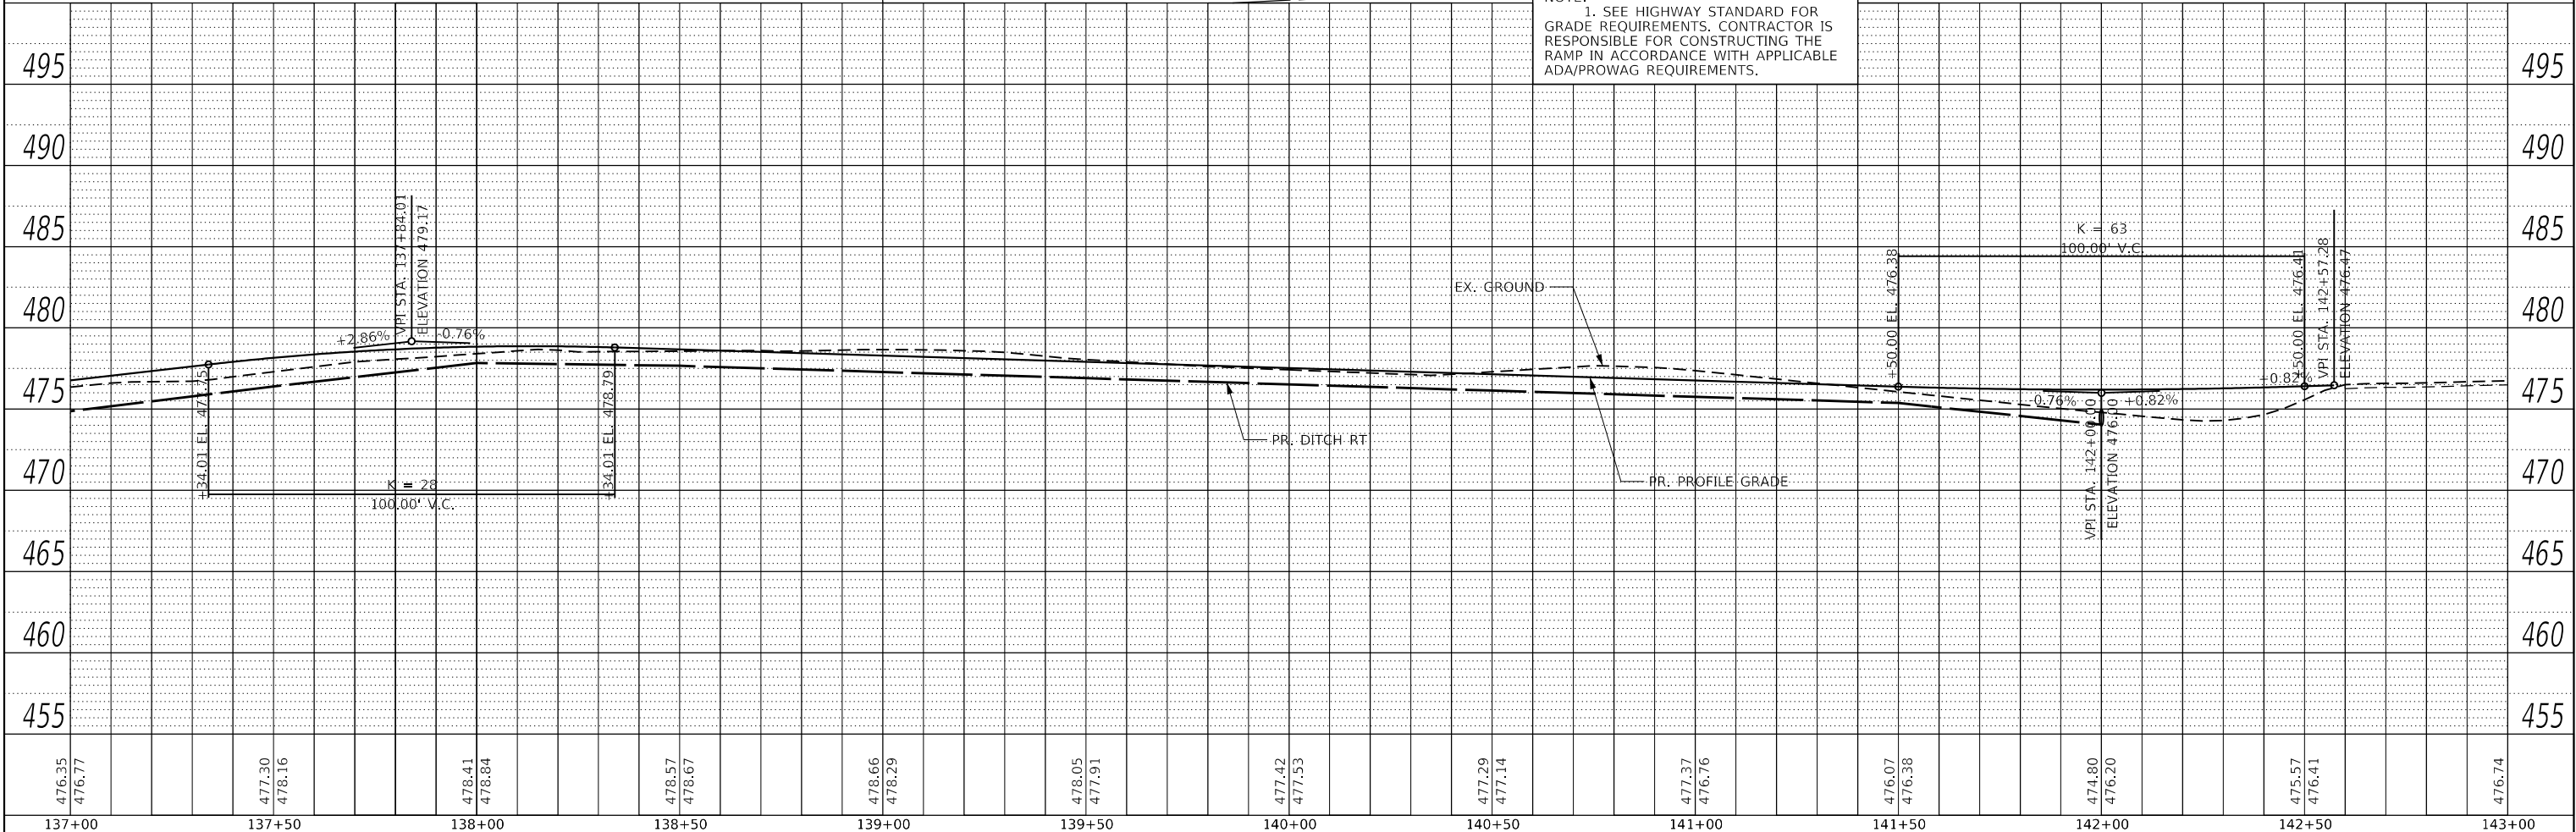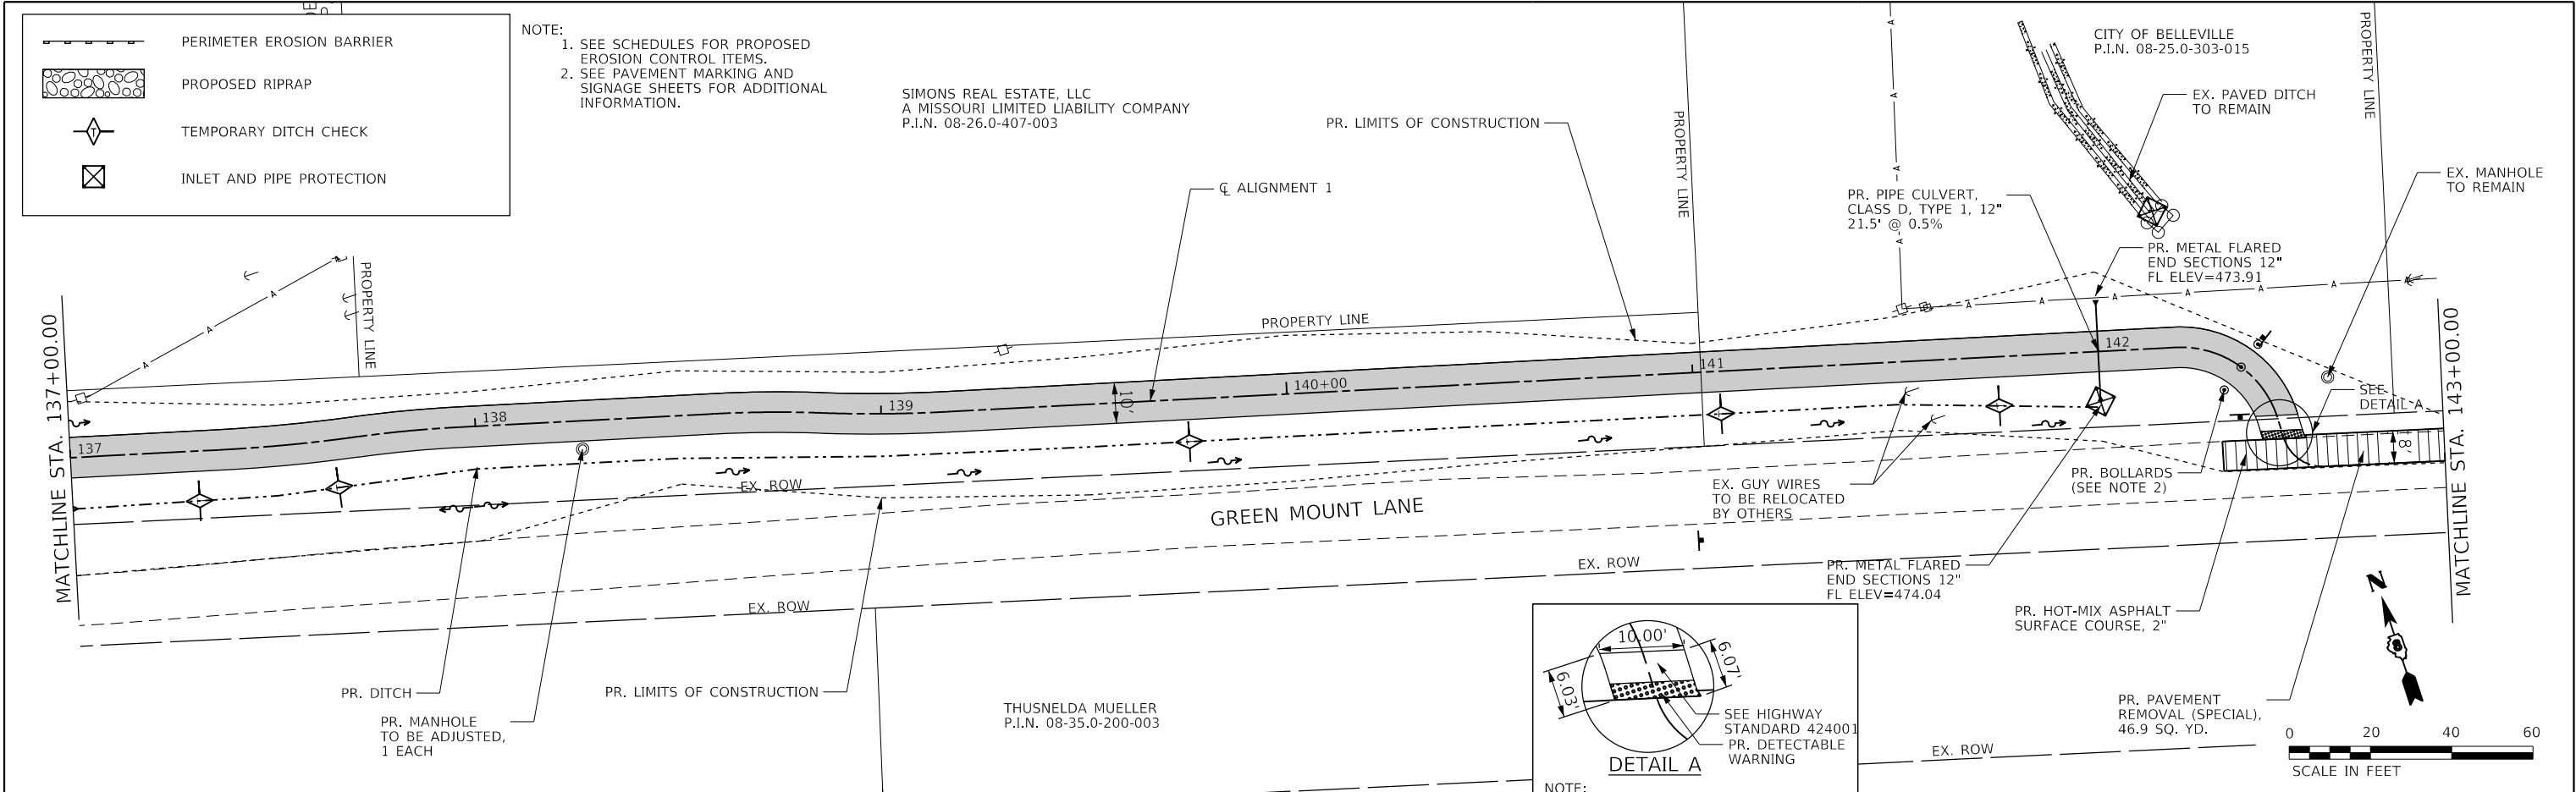

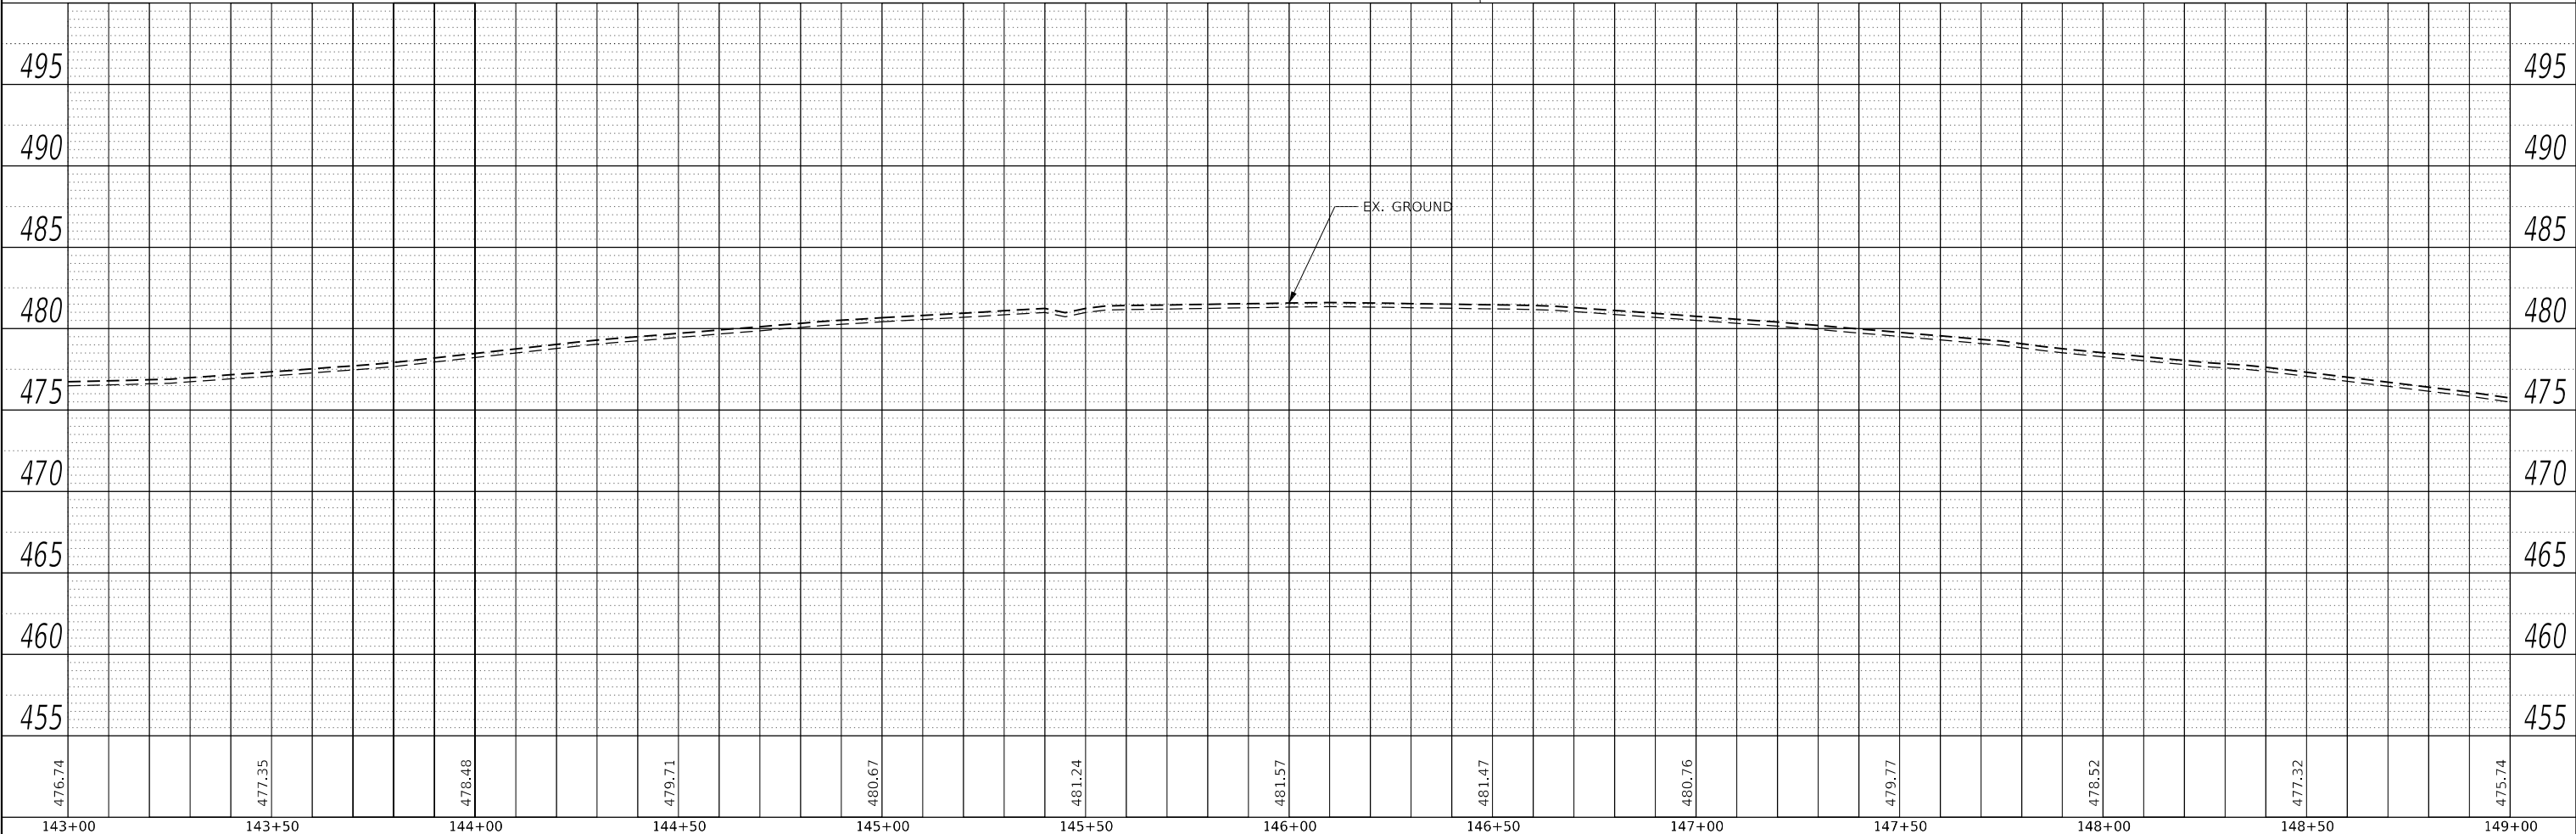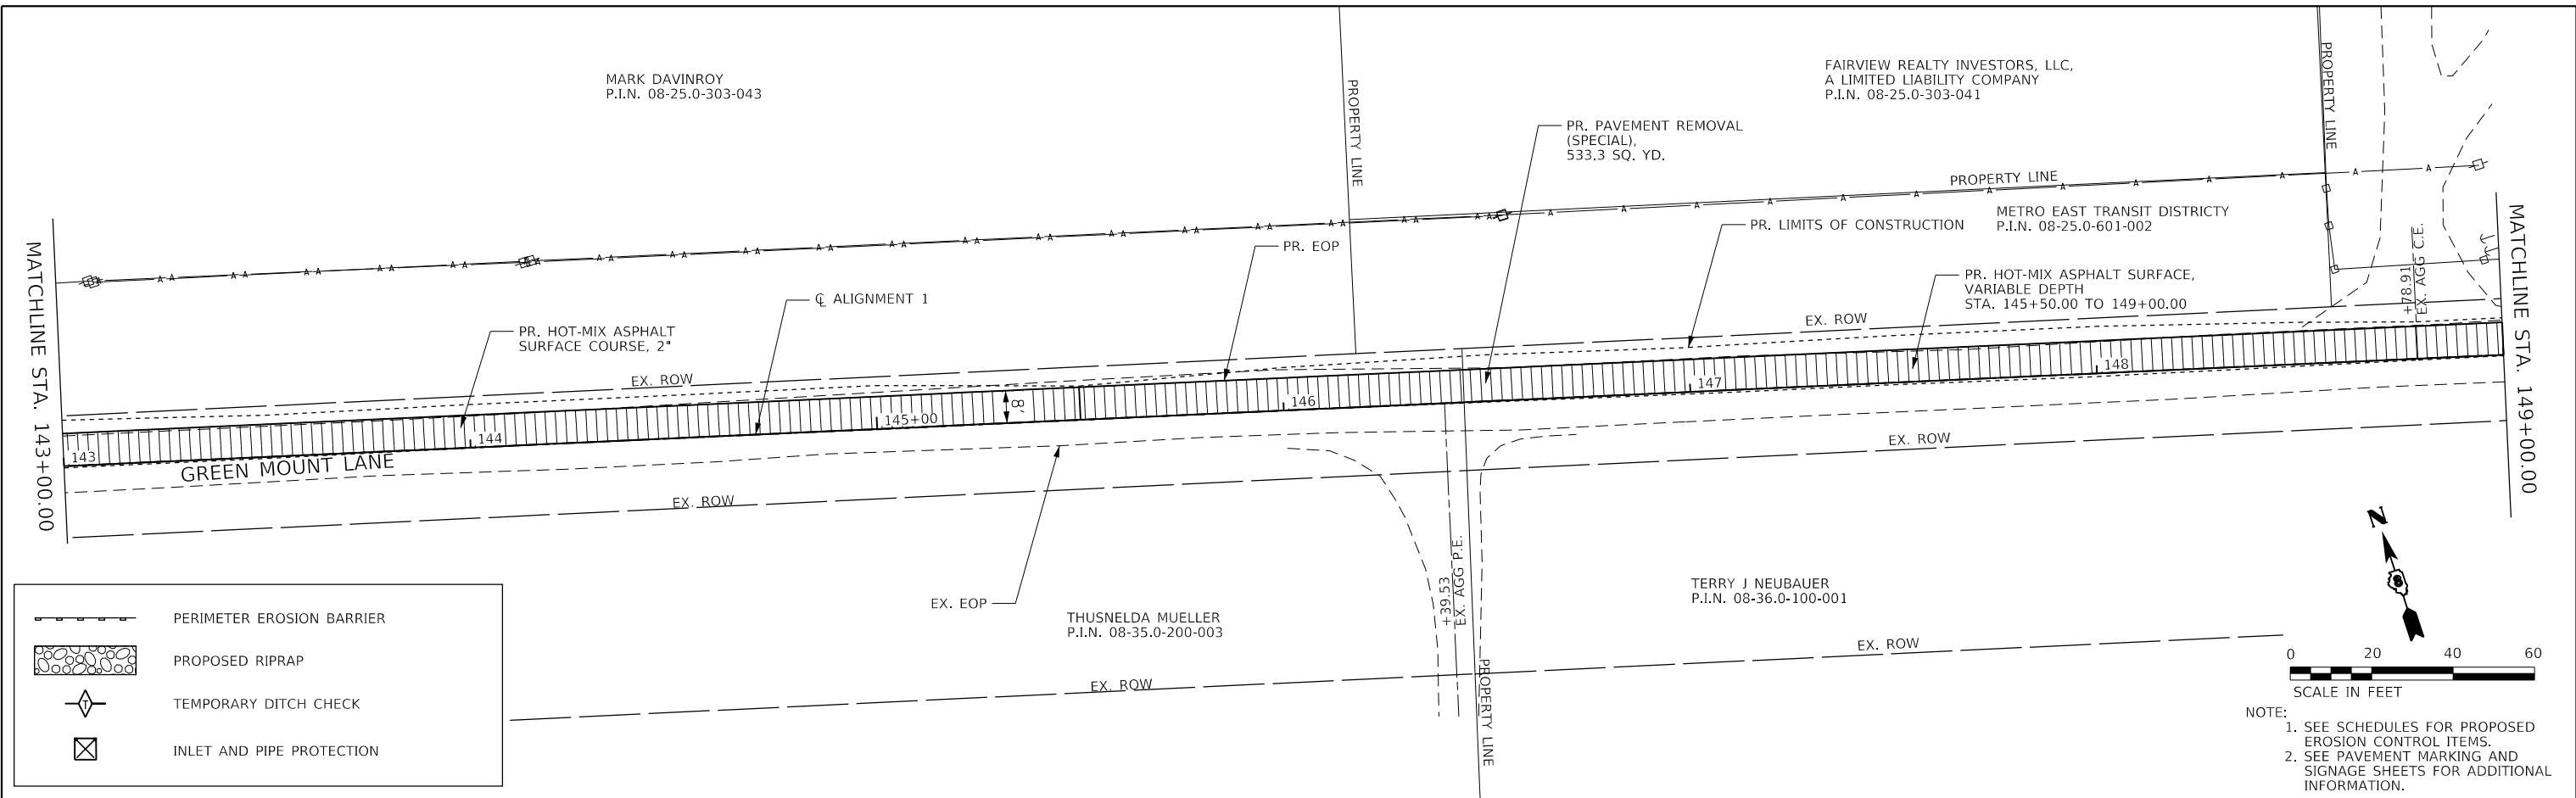

DESIGNED - JRR
DRAWN - EKS/TMG
CHECKED - JWS
DATE - 03/2018

REVISED -
REVISED -
REVISED -
REVISED -

**THOUVENOT,
WADE &
MOERCHEN, INC.**
SWANSEA • WATERLOO • EDWARDSVILLE • ST. LOUIS • ST. CHARLES

TWM
EXCEPTIONAL SERVICE.
NOTHING LESS.

**St Clair
County
Transit
District**

PLAN AND PROFILE ALIGNMENT 1	
PROJECT	JOB NO.
SHEET NO. 8 OF 11 SHEETS	STA. 143+00.00 TO STA. 149+00.00



Orchard Loop Trail Phase 1	
COUNTY	TOTAL SHEETS
ST. CLAIR	140



FED. ROAD DIST. NO.	ILLINOIS	FED. AID PROJECT
---------------------	----------	------------------

COUNTY
ST. CLAIR
TOTAL SHEETS
140
SHEET NO.
33



FILE NAME: I30149-PinPr f011.dgn

PLotted By: esmith

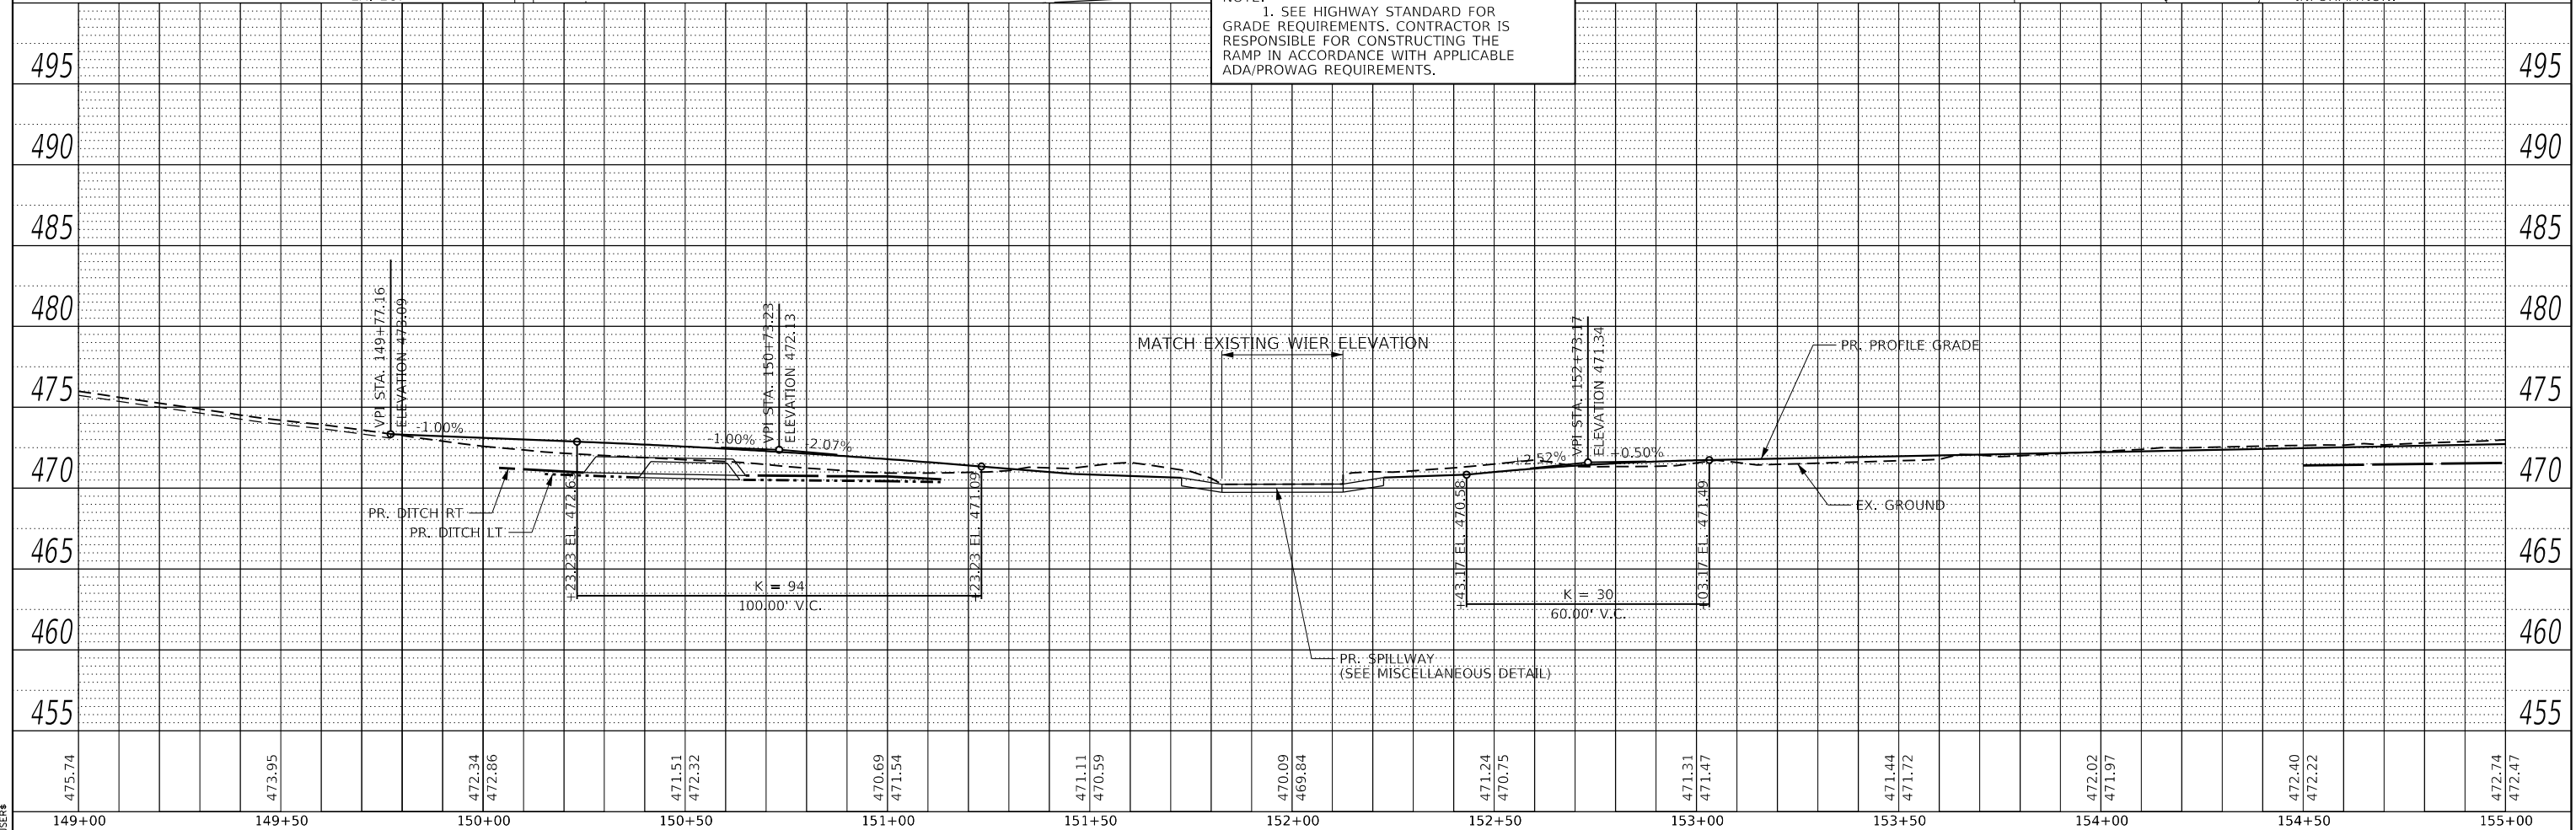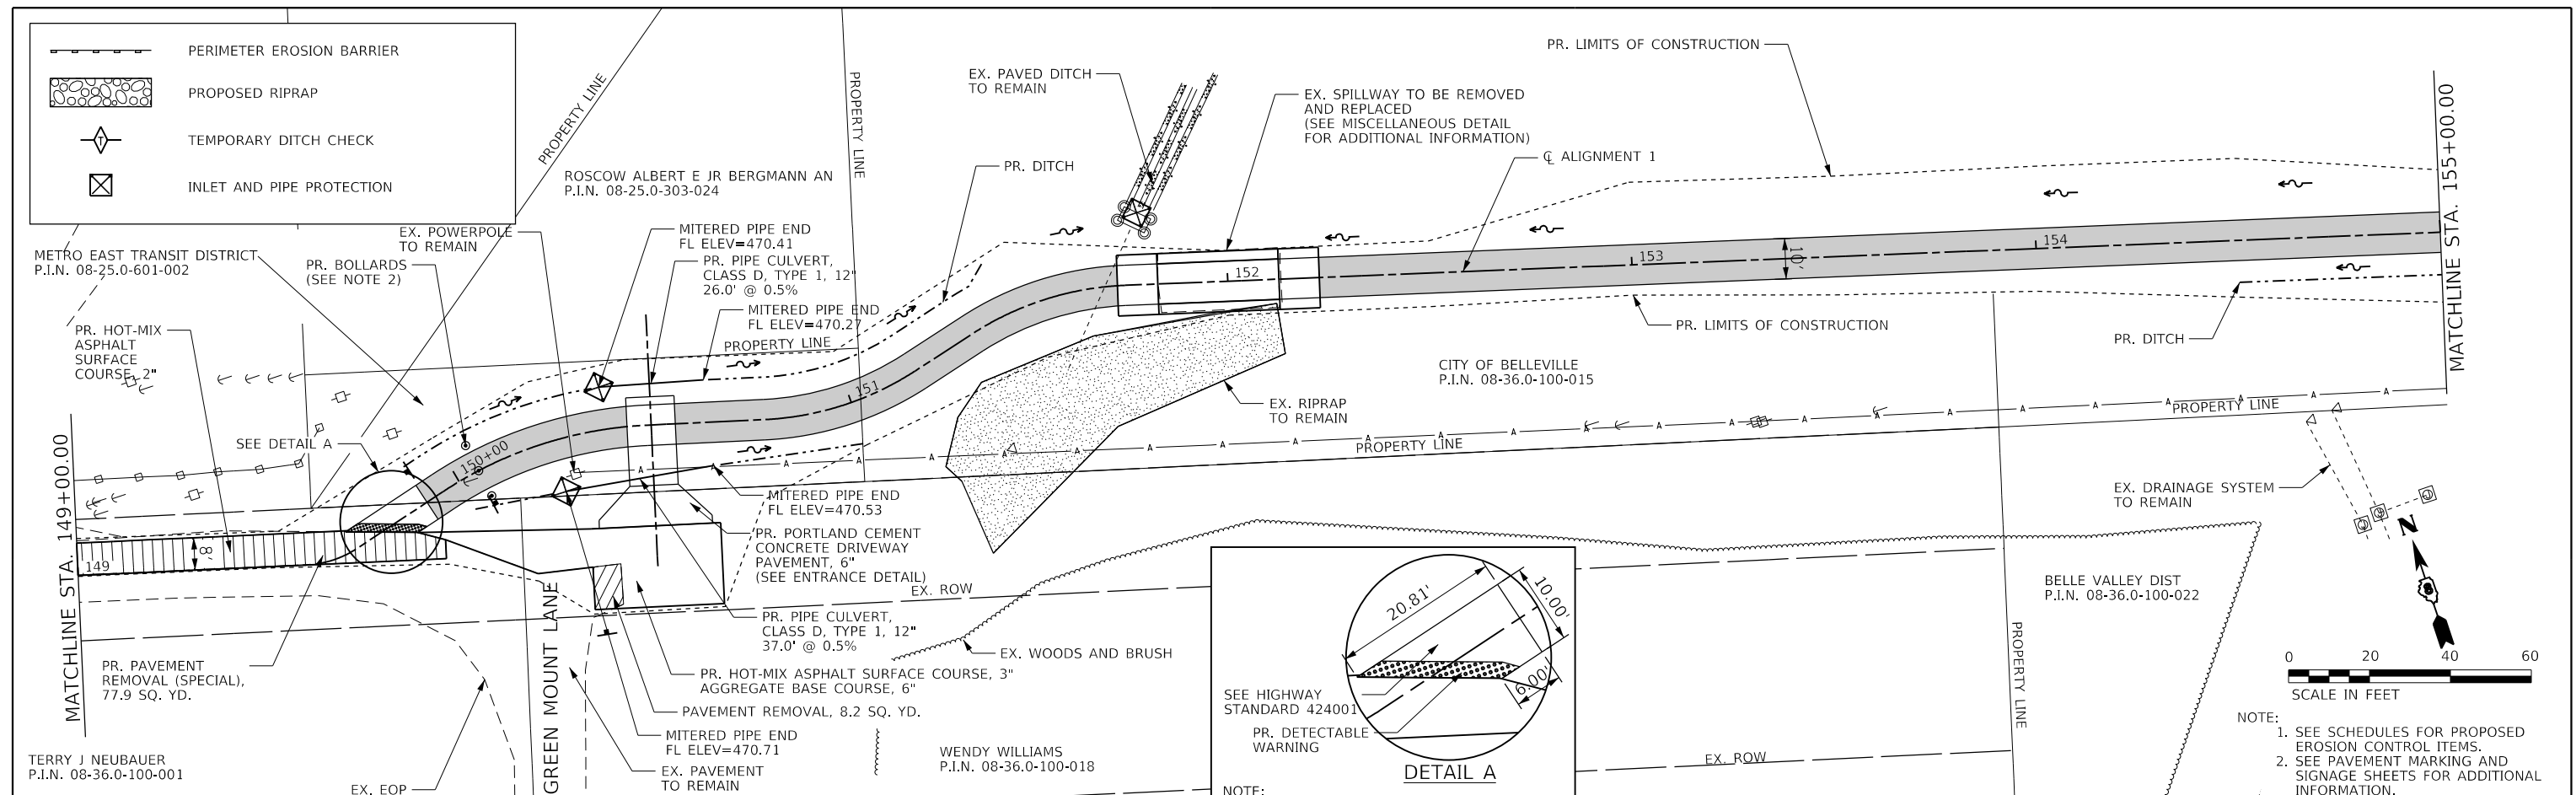


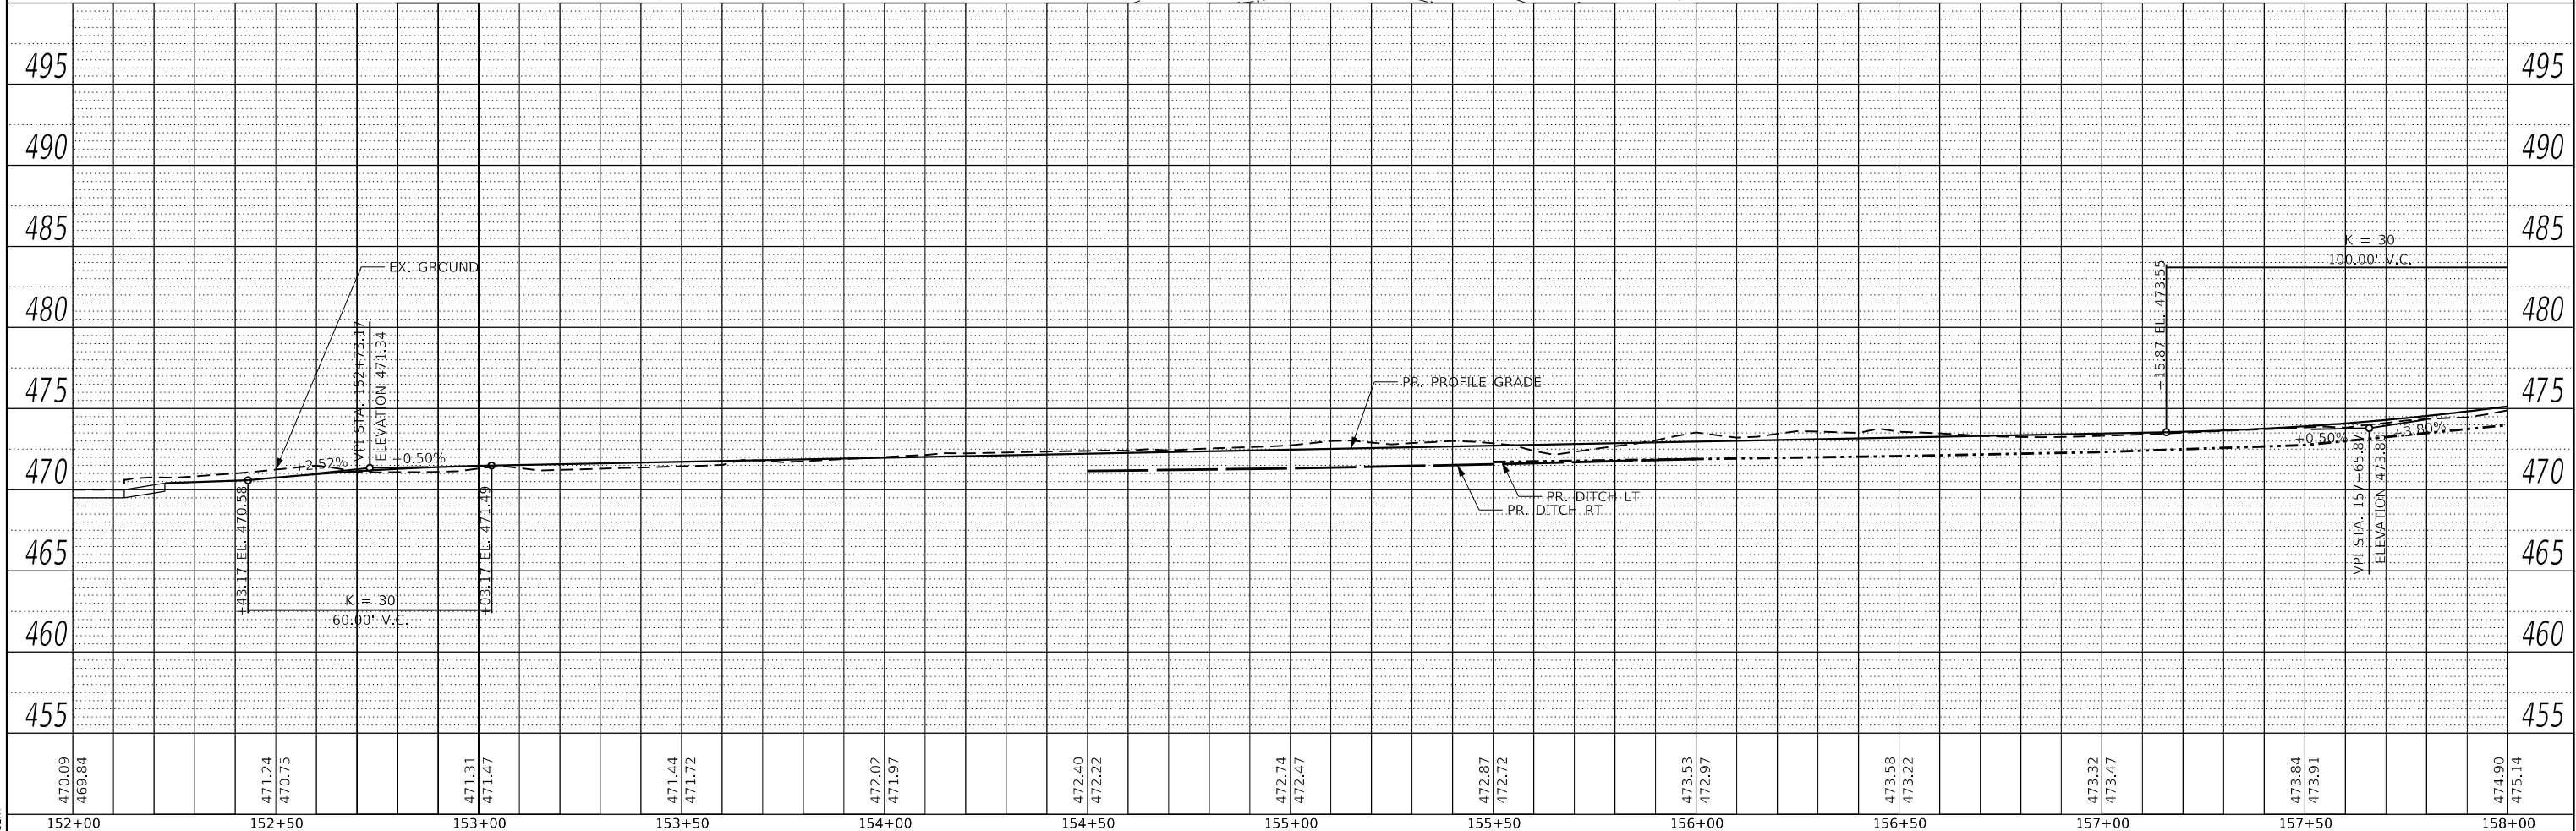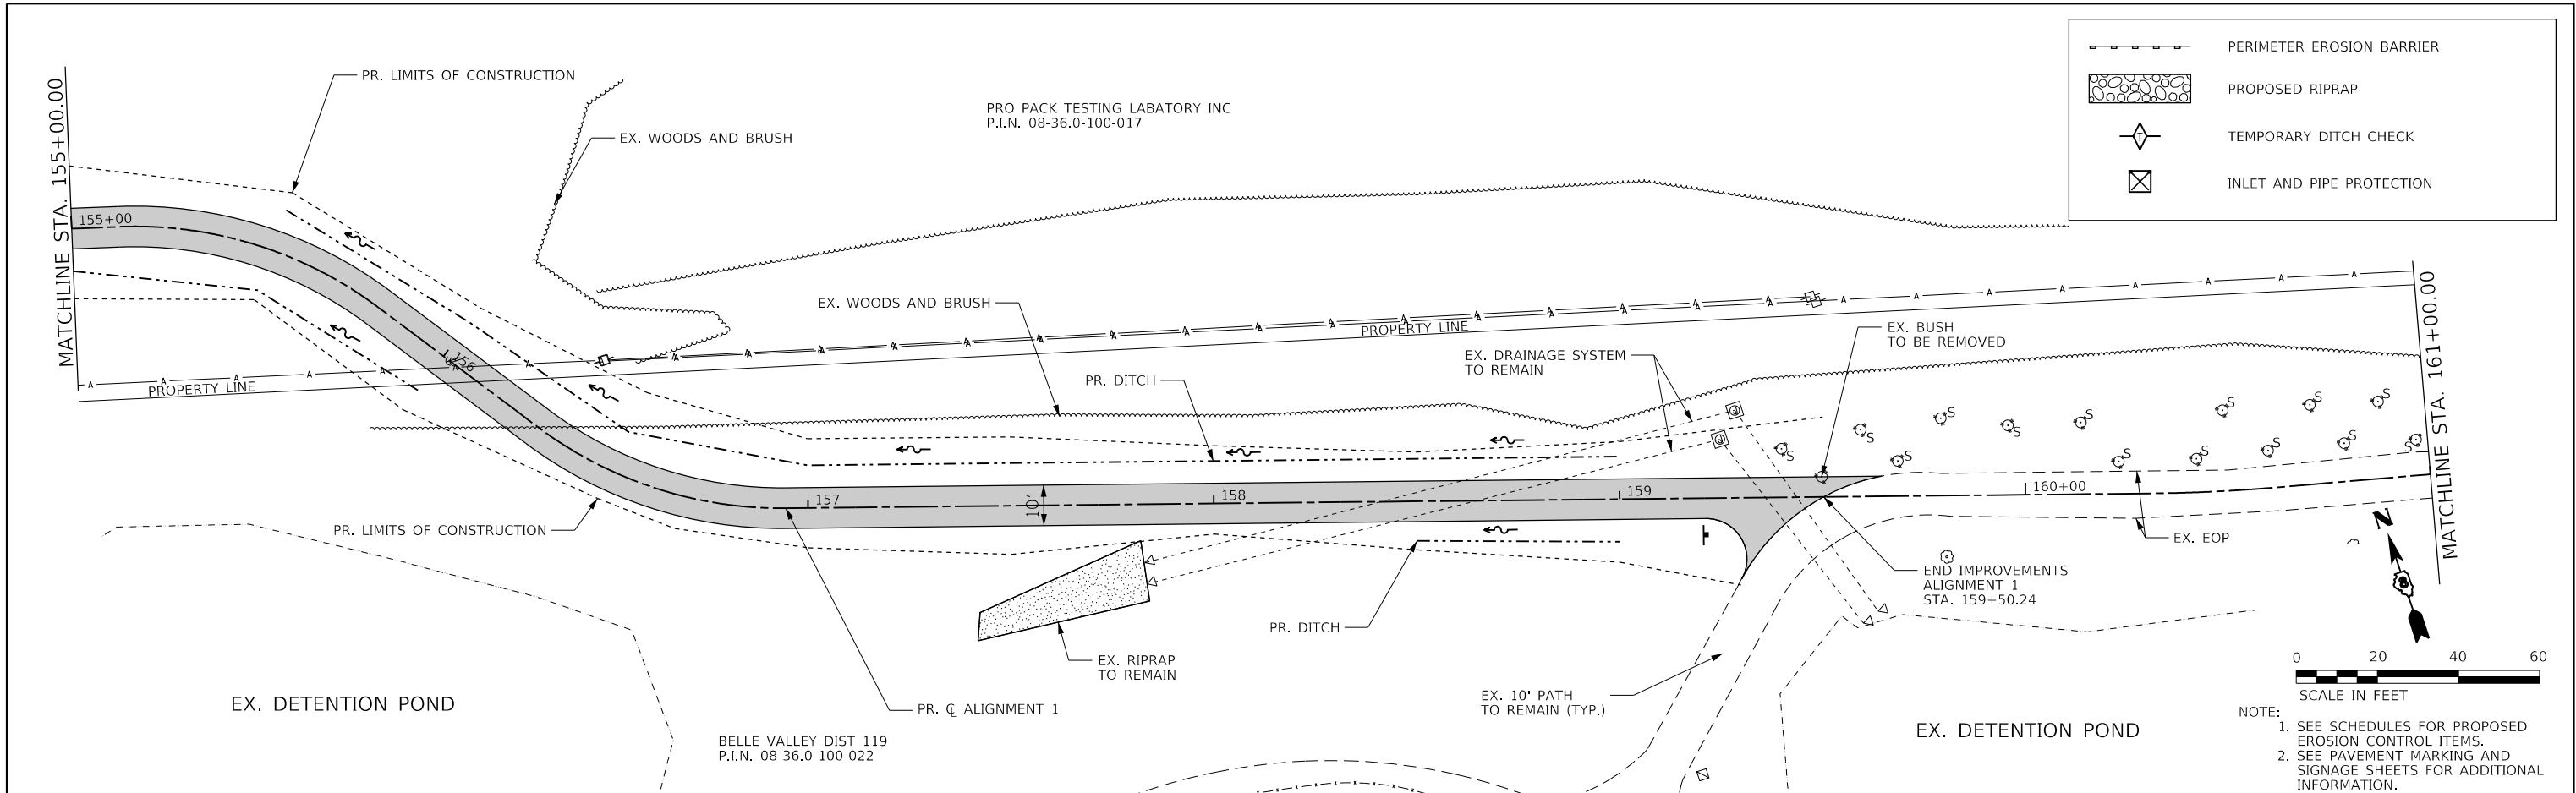


DESIGNED - JRR	REVISED -	THOUVENOT, WADE & MOERCHEN, INC. CORPORATE OFFICE 4940 Old Collinsville Road Swansea, Illinois 62226 Tel: 618.824.4488 Fax: 618.624.6688 SWANSEA • WATERLOO • EDWARDSVILLE • ST. LOUIS • ST. CHARLES	 EXCEPTIONAL SERVICE. NOTHING LESS.	 St Clair County Transit District	PLAN AND PROFILE ALIGNMENT 1			Orchard Loop Trail Phase 1		COUNTY	TOTAL SHEETS	SHEET NO.	
DRAWN - EKS/TMG	REVISED -									ST. CLAIR	140	35	
CHECKED - JWS	REVISED -							PROJECT	JOB NO.				
DATE - 03/2018	REVISED -							SCALE: 1" = 20'	SHEET NO. 10 OF 11 SHEETS	STA. 155+00.00 TO STA. 161+00.00	FED. ROAD DIST. NO.	ILLINOIS	FED. AID PROJECT
FILE NAME: *FILES*													

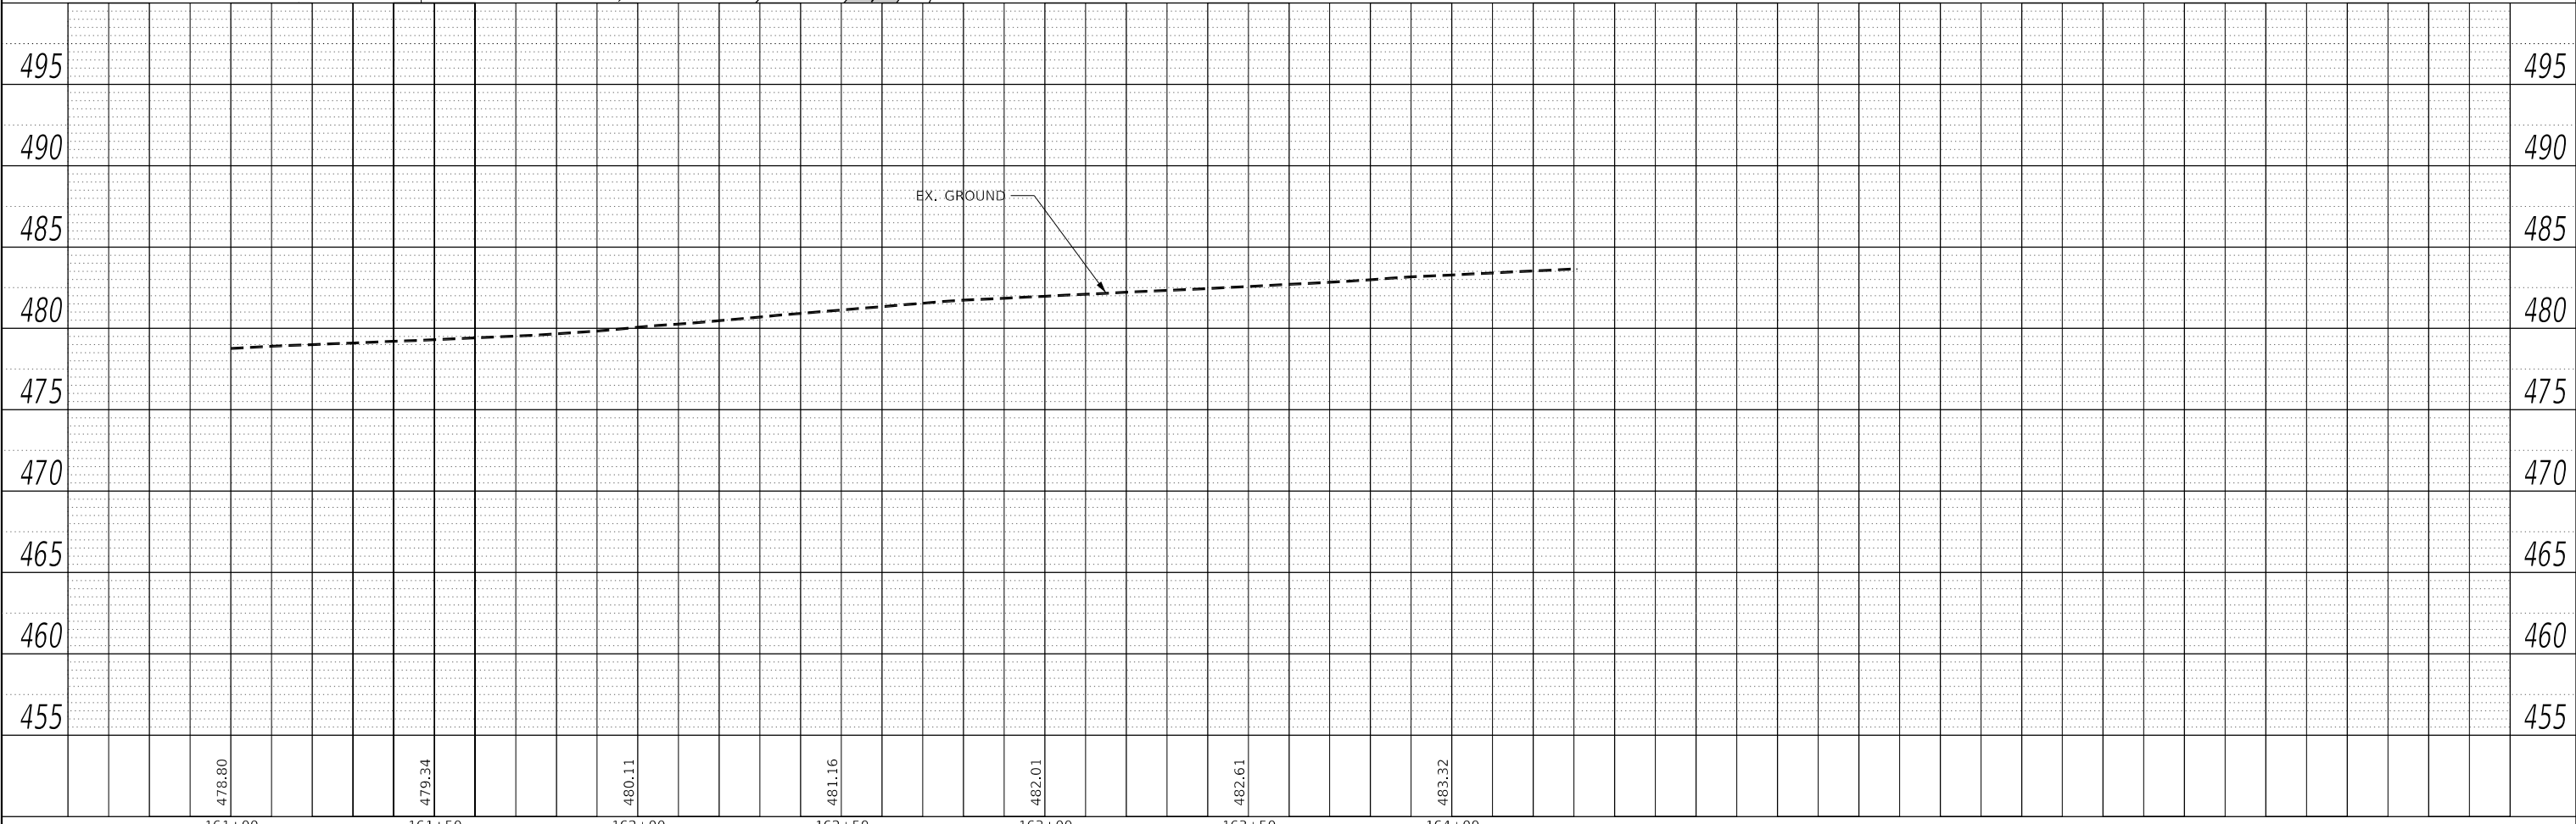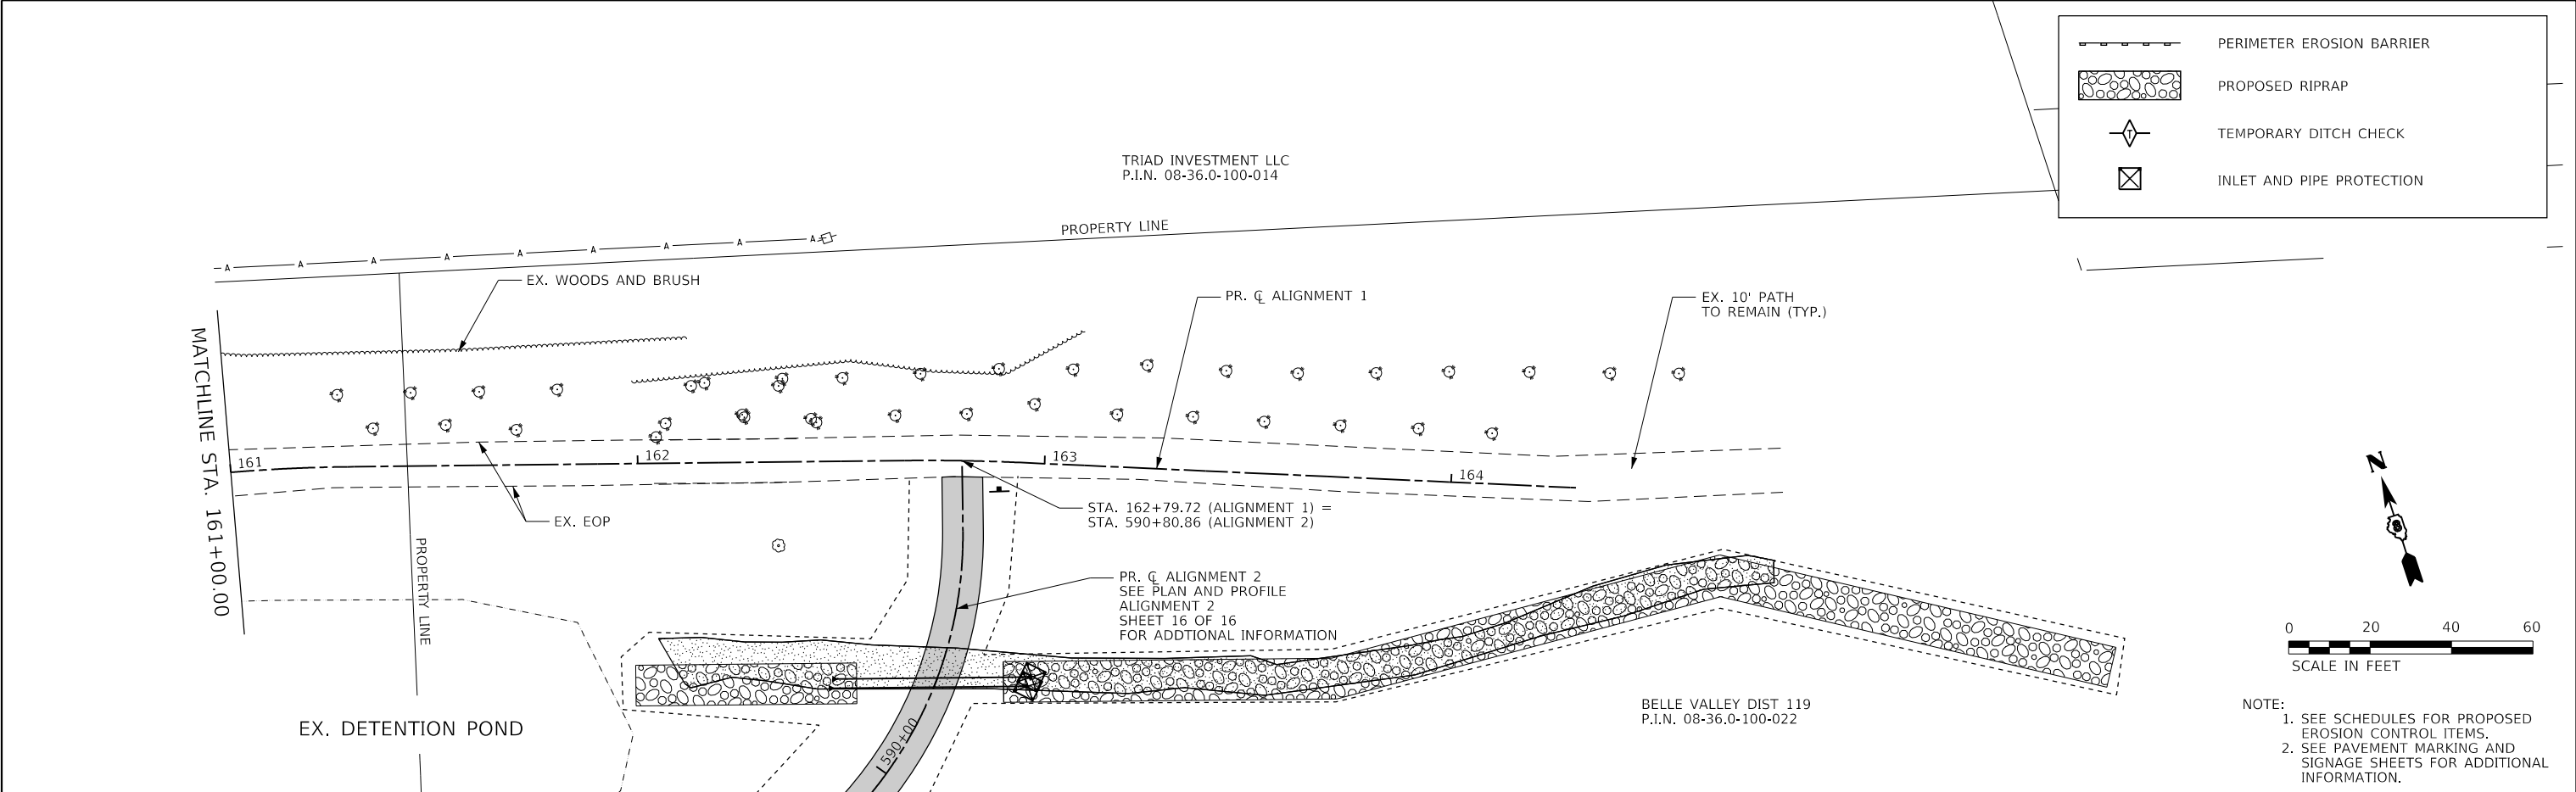

DESIGNED - JRR		REVISED -		THOUVENOT, WADE & MOERCHEN, INC.		CORPORATE OFFICE 4940 Old Collinsville Road Swansea, Illinois 62226 Tel: 618.624.4488 Fax: 618.624.6688		TWM EXCEPTIONAL SERVICE. NOTHING LESS.		St Clair County Transit District		PLAN AND PROFILE ALIGNMENT 1		Orchard Loop Trail Phase 1		COUNTY ST. CLAIR		TOTAL SHEETS 140		SHEET NO. 36	
DRAWN - EKS/TMG		REVISED -		SWANSEA • WATERLOO • EDWARDSVILLE • ST. LOUIS • ST. CHARLES								PROJECT		JOB NO.							
CHECKED - JWS		REVISED -										SCALE: 1" = 20'		SHEET NO. 11 OF 11 SHEETS		STA. 161+00.00 TO STA. 164+30.71		FED. ROAD DIST. NO.		ILLINOIS	
DATE - 03/2018		REVISED -																			

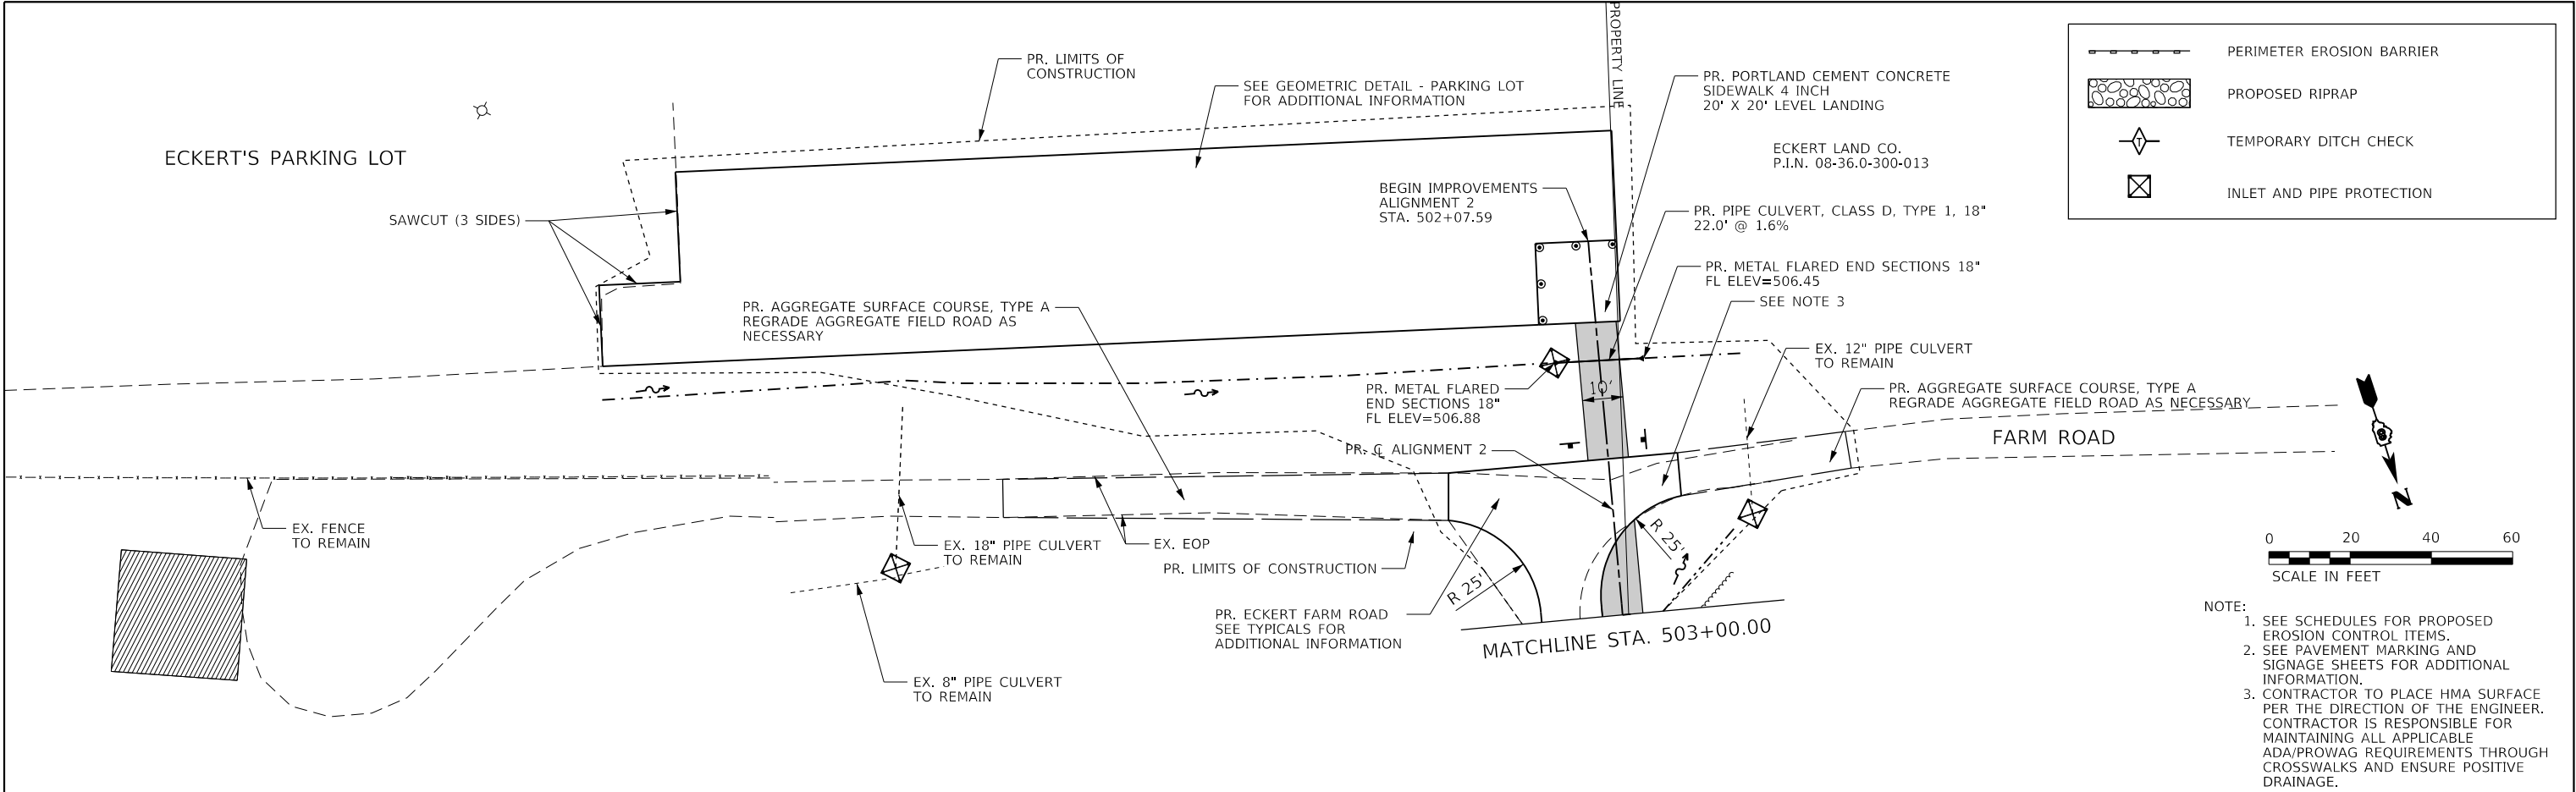

- NOTE:
1. SEE SCHEDULES FOR PROPOSED EROSION CONTROL ITEMS.
 2. SEE PAVEMENT MARKING AND SIGNAGE SHEETS FOR ADDITIONAL INFORMATION.
 3. CONTRACTOR TO PLACE HMA SURFACE PER THE DIRECTION OF THE ENGINEER. CONTRACTOR IS RESPONSIBLE FOR MAINTAINING ALL APPLICABLE ADA/PROWAG REQUIREMENTS THROUGH CROSSWALKS AND ENSURE POSITIVE DRAINAGE.

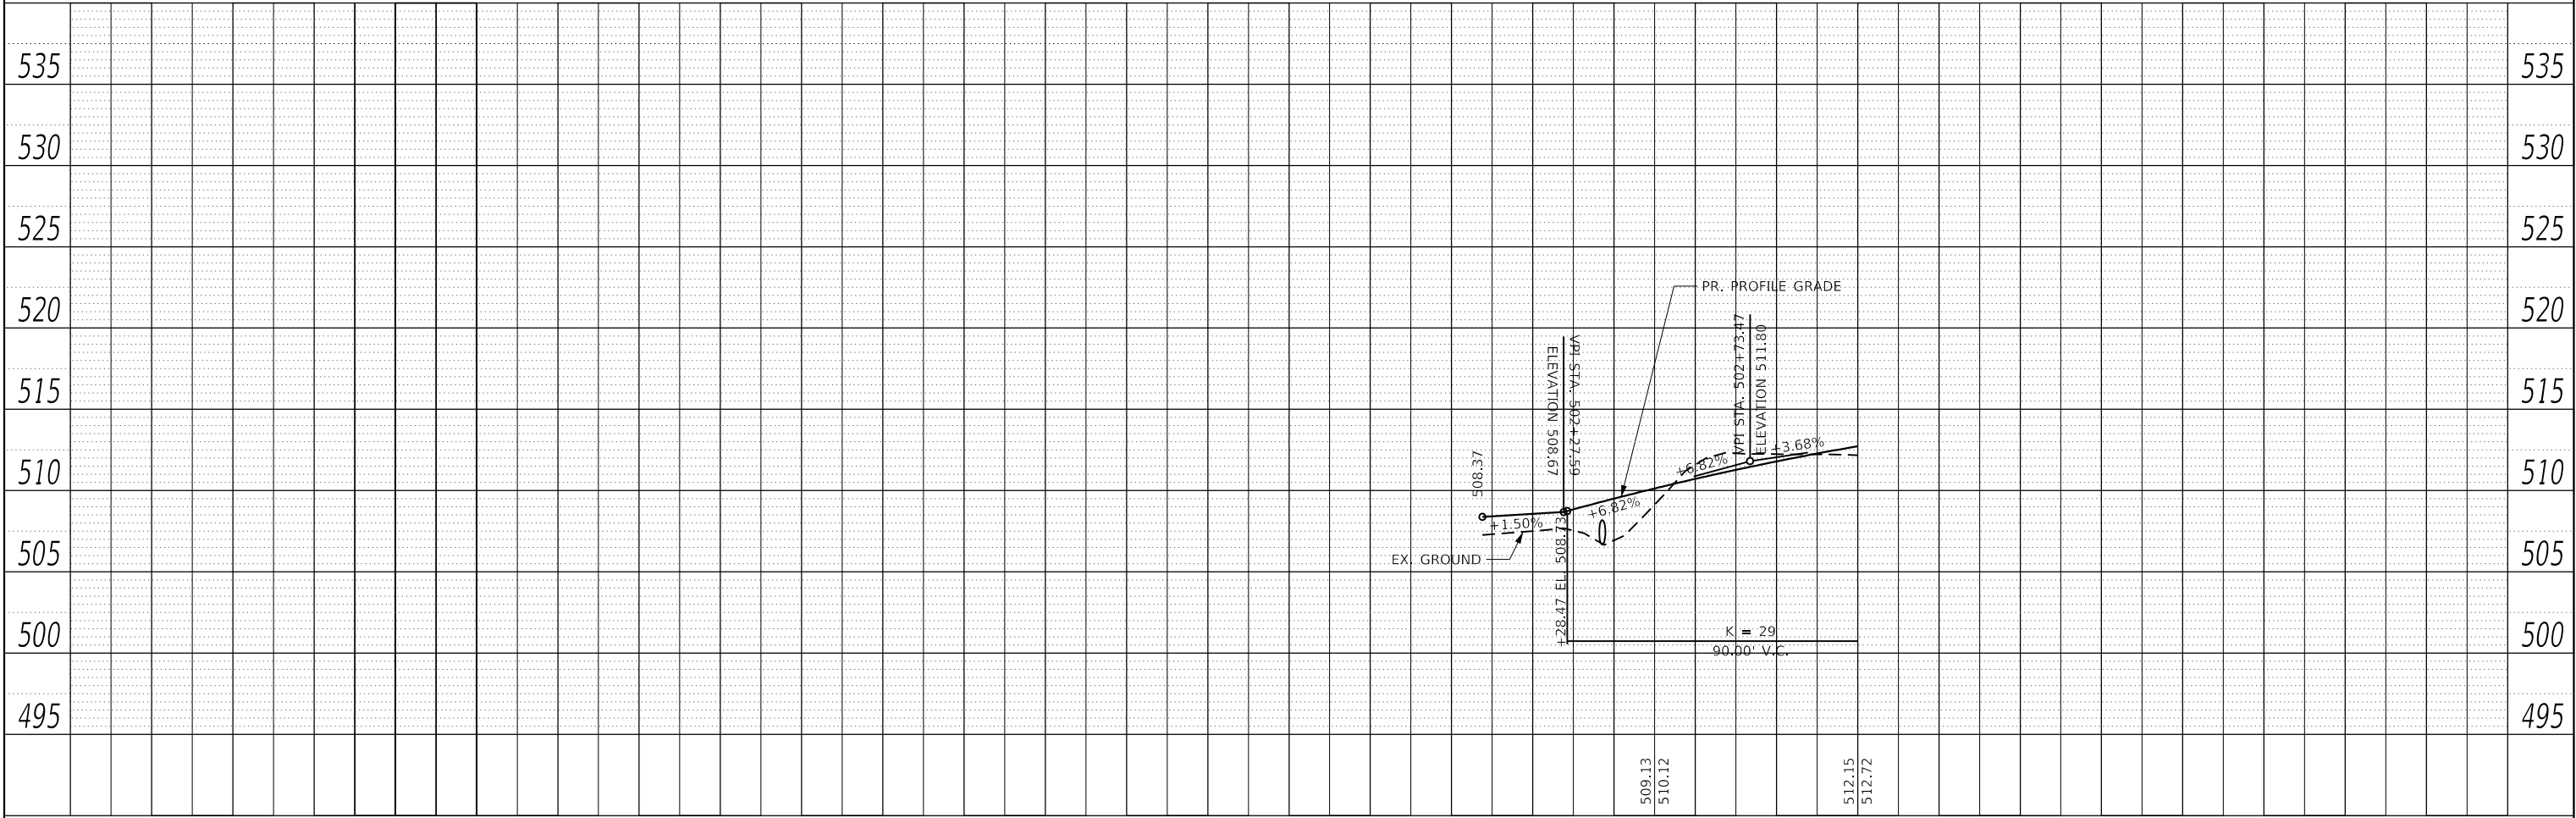

DESIGNED - JRR	REVISED -
DRAWN - EKS/TMG	REVISED -
CHECKED - JWS	REVISED -
DATE - 03/2018	REVISED -


THOUVENOT, WADE & MOERCHEN, INC.
CORPORATE OFFICE
4940 Old Collinsville Road
Swansea, Illinois 62226
Tel: 618.824.4488
Fax: 618.824.6688
SWANSEA • WATERLOO • EDWARDSVILLE • ST. LOUIS • ST. CHARLES





PLAN AND PROFILE ALIGNMENT 2		
	PROJECT	JOB NO.
SCALE: 1" = 20'	SHEET NO. 1 OF 16 SHEETS	STA. 502+07.59 TO STA. 503+00.00

Orchard Loop Trail Phase 1		COUNTY	TOTAL SHEETS	SHEET NO.
		ST. CLAIR	140	37
FED. ROAD DIST. NO. ILLINOIS FED. AID PROJECT				

 PLOTTED BY: esmith
FILE NAME: I30149-PinPr f015.dgn

	PERIMETER EROSION BARRIER
	PROPOSED RIPRAP
	TEMPORARY DITCH CHECK
	INLET AND PIPE PROTECTION

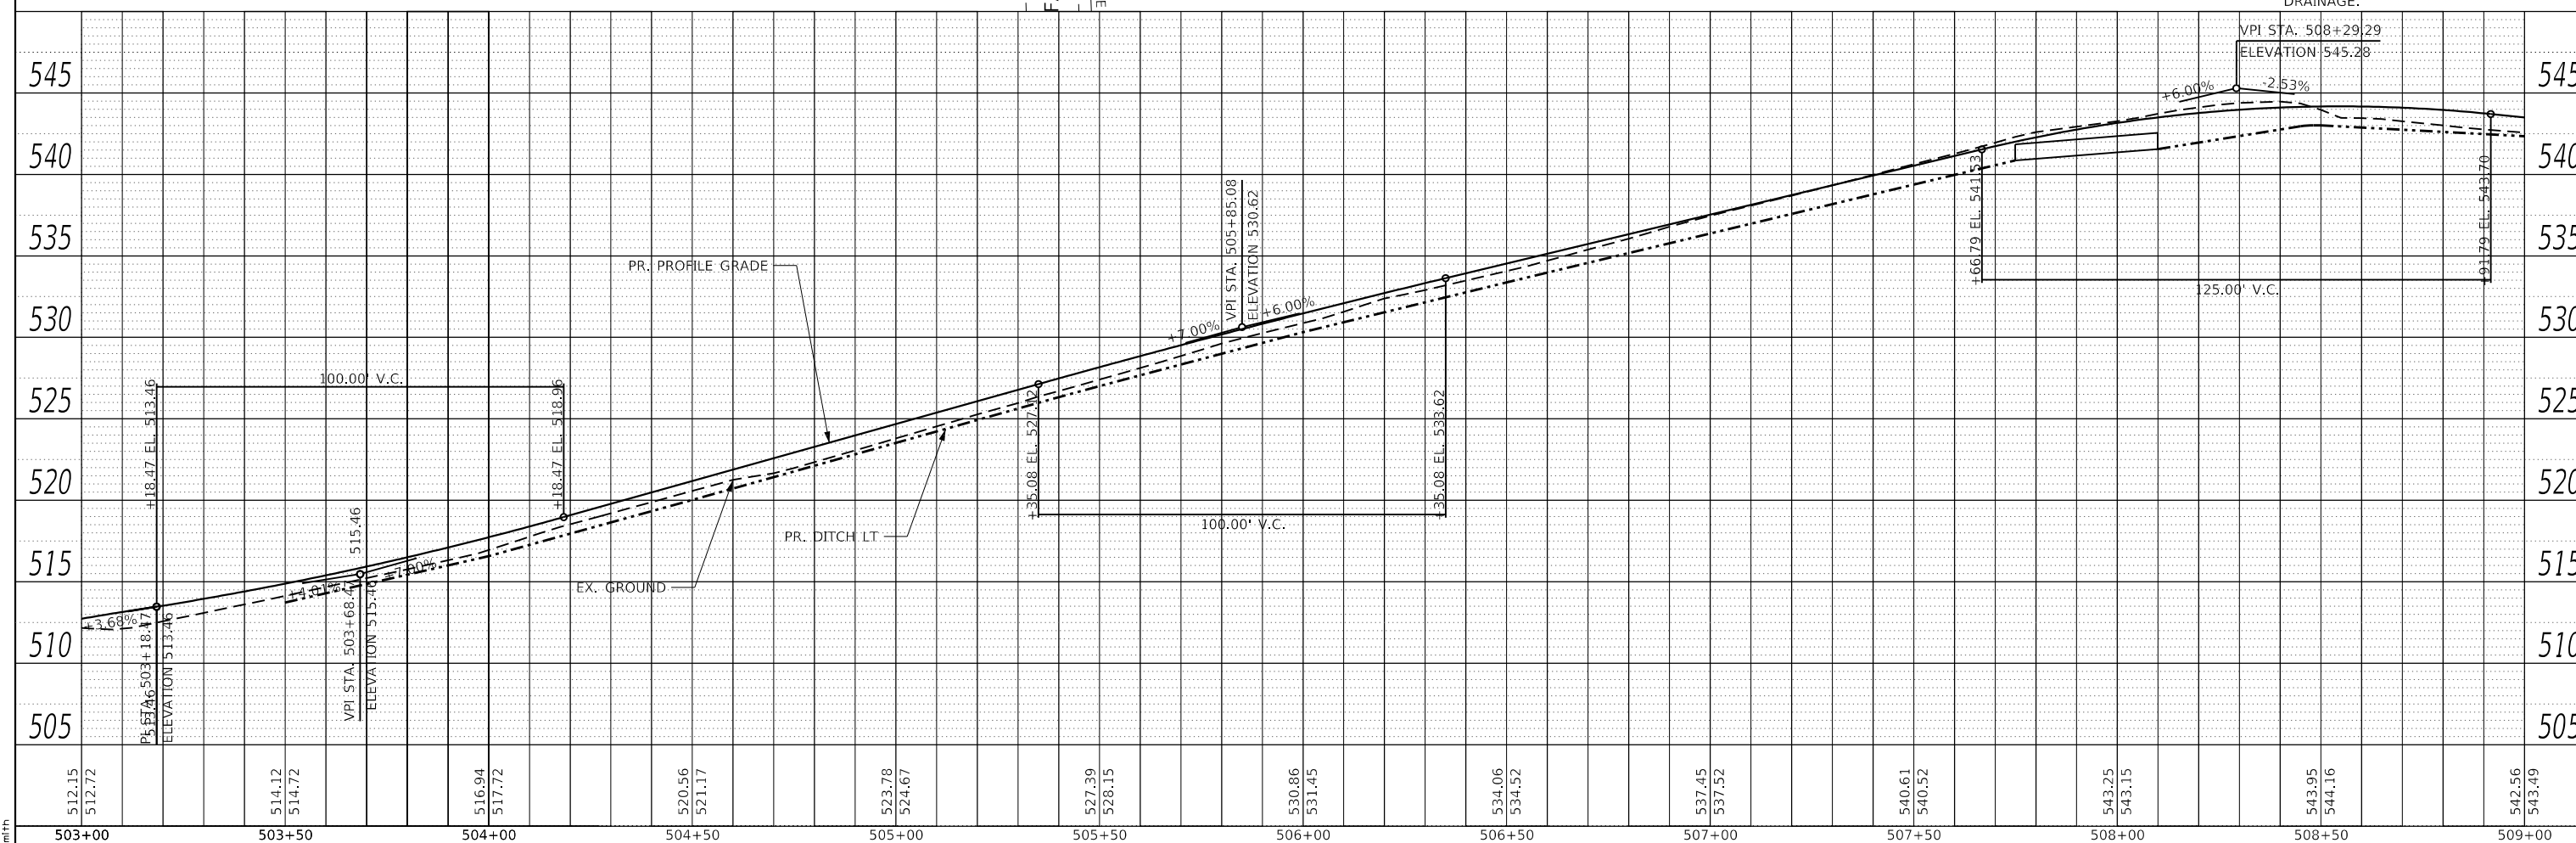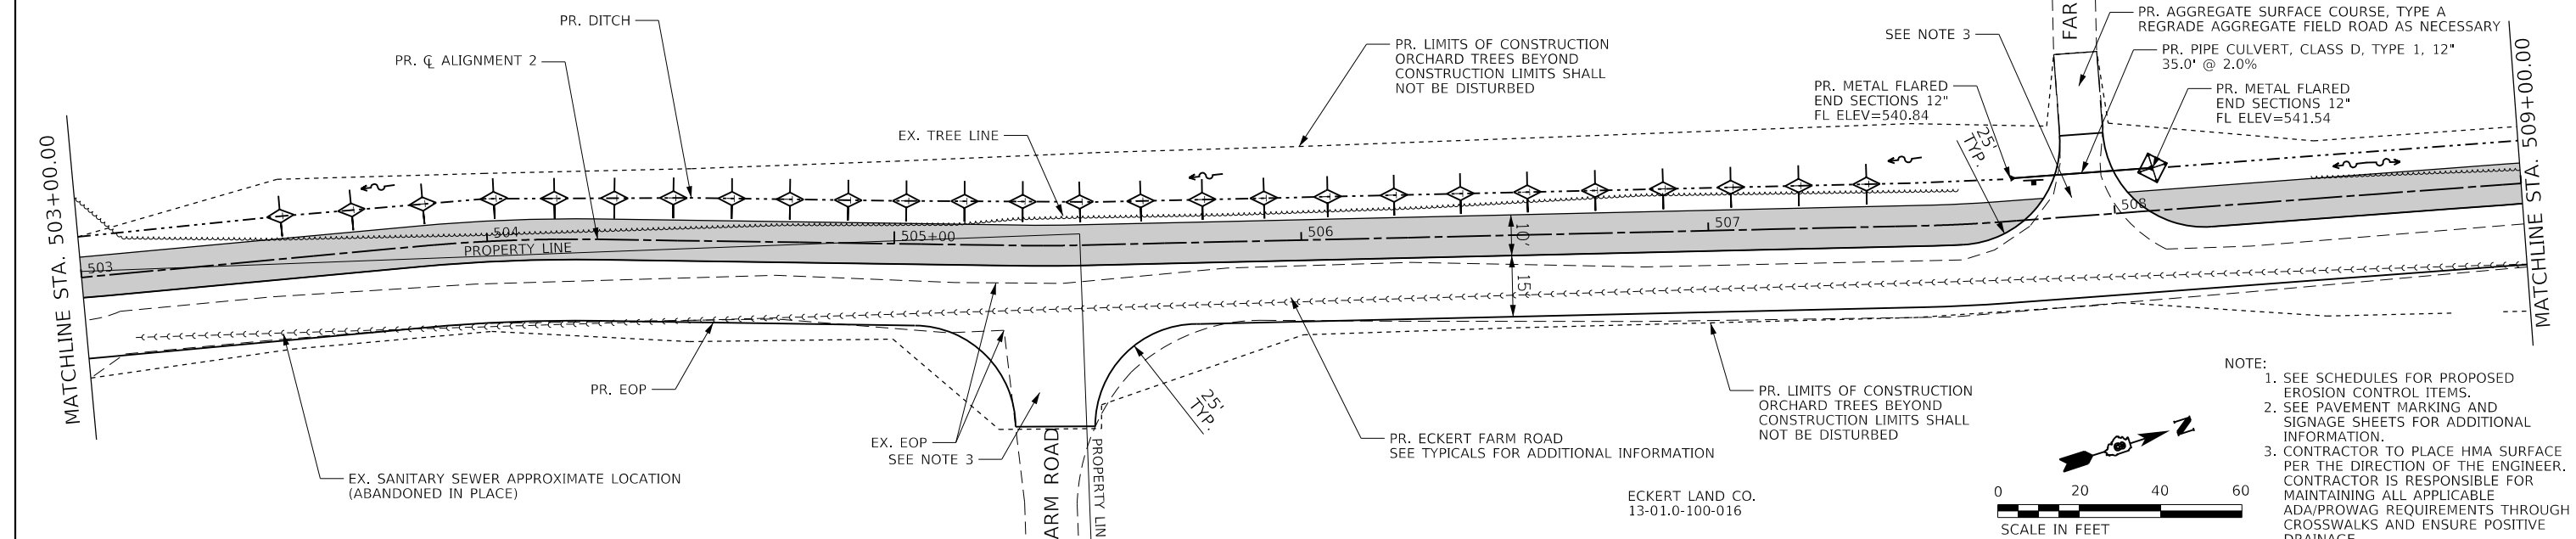

DESIGNED - JRR	REVISED -
DRAWN - EKS/TMG	REVISED -
CHECKED - JWS	REVISED -
DATE - 03/2018	REVISED -

**THOUVENOT,
WADE &
MOERCHEN, INC.**

CORPORATE OFFICE
4940 Old Collinsville Road
Swansea, Illinois 62226
Tel: 618.624.4488
Fax: 618.624.6688

SWANSEA • WATERLOO • EDWARDSVILLE • ST. LOUIS • ST. CHARLES

St Clair
County
Transit
District

PLAN AND PROFILE ALIGNMENT 2		
	PROJECT	JOB NO.
SCALE: 1" = 20'	SHEET NO. 2 OF 16 SHEETS	STA. 503+00.00 TO STA. 509+00.00

Orchard Loop Trail Phase 1	COUNTY	TOTAL SHEETS	SHEET NO.
	ST. CLAIR	140	38
FED. ROAD DIST. NO.	ILLINOIS	FED. AID PROJECT	

PERIMETER EROSION BARRIER



PROPOSED RIPRAP

TEMPORARY DITCH CHECK

INLET AND PIPE PROTECTION

ECKERT LAND CO.
P.I.N. 08-36.0-300-013

- NOTE:
1. SEE SCHEDULES FOR PROPOSED EROSION CONTROL ITEMS.
 2. SEE PAVEMENT MARKING AND SIGNAGE SHEETS FOR ADDITIONAL INFORMATION.
 3. CONTRACTOR TO PLACE HMA SURFACE PER THE DIRECTION OF THE ENGINEER. CONTRACTOR IS RESPONSIBLE FOR MAINTAINING ALL APPLICABLE ADA/PROWAG REQUIREMENTS THROUGH CROSSWALKS AND ENSURE POSITIVE DRAINAGE.

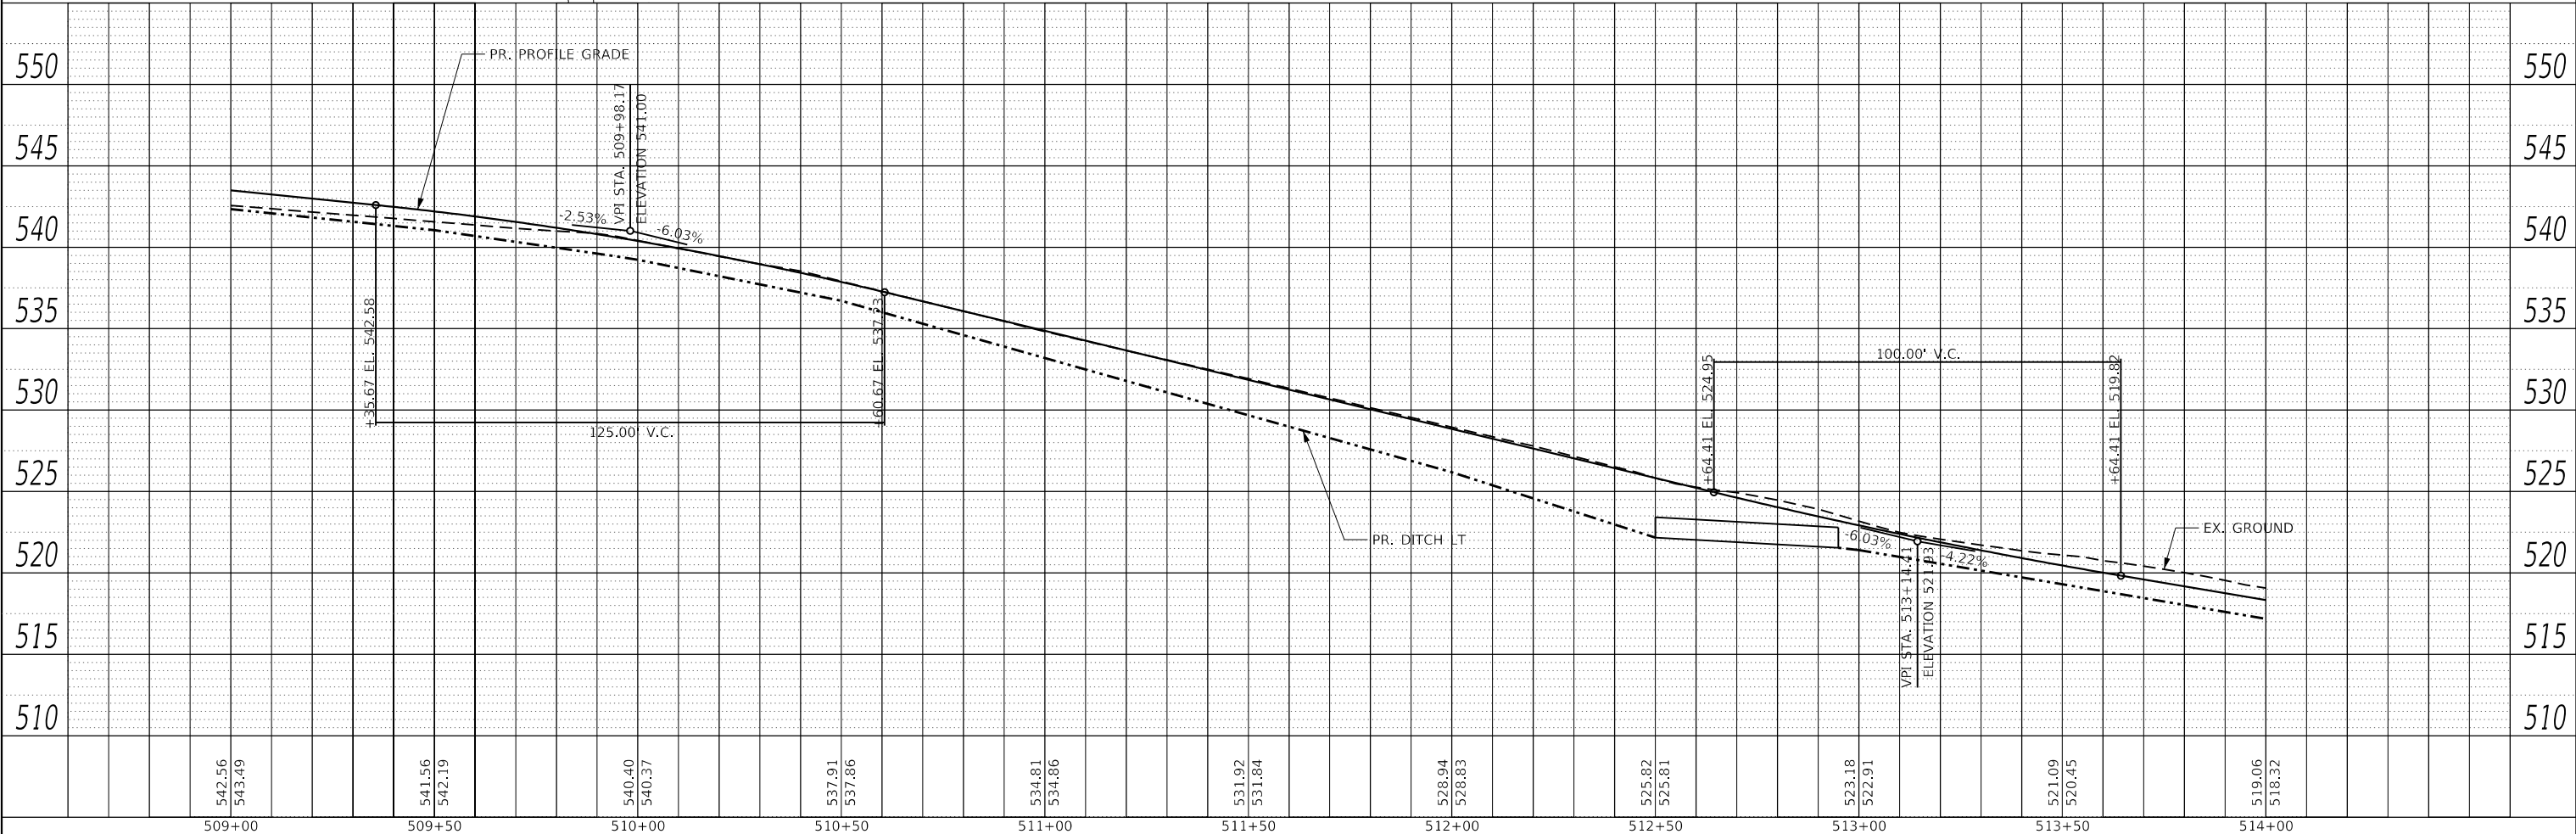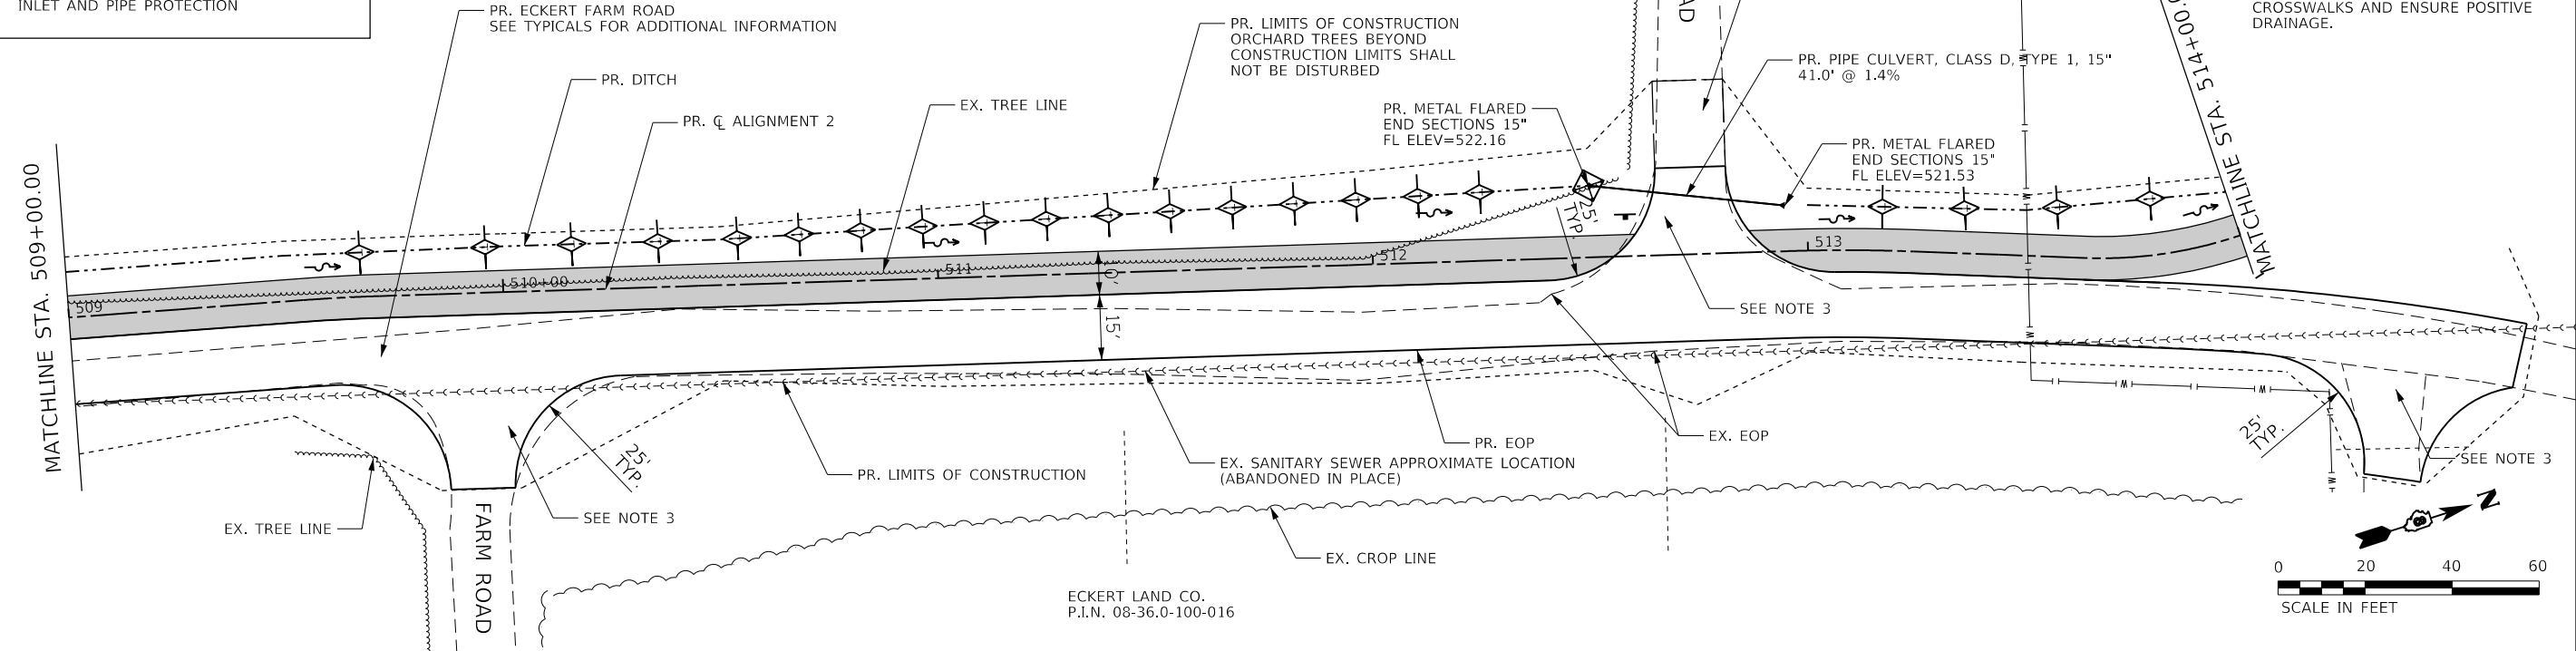

DESIGNED - JRR

DRAWN - EKS/TMG

CHECKED - JWS

DATE - 03/2018

REVISED -

REVISED -

REVISED -

REVISED -

THOUVENOT,
WADE &
MOERCHEN, INC.

CORPORATE OFFICE
4940 Old Collinsville Road
Swansea, Illinois 62226
Tel: 618.624.4488
Fax: 618.624.6688

SWANSEA • WATERLOO • EDWARDSVILLE • ST. LOUIS • ST. CHARLES

TWM

EXCEPTIONAL SERVICE.
NOTHING LESS.

St Clair
County
Transit
District

PLAN AND PROFILE
ALIGNMENT 2

PROJECT

JOB NO.

SCALE: 1" = 20'

SHEET NO. 3 OF 16 SHEETS

STA. 509+00.00 TO STA. 514+00.00

Orchard Loop Trail
Phase 1

FED. ROAD DIST. NO.

ILLINOIS

FED. AID PROJECT

COUNTY

ST. CLAIR



TOTAL
SHEETS

140


SHEET
NO.

39



PLOTTED BY: esmith
FILE NAME: I30149-PinPr f017.dgn

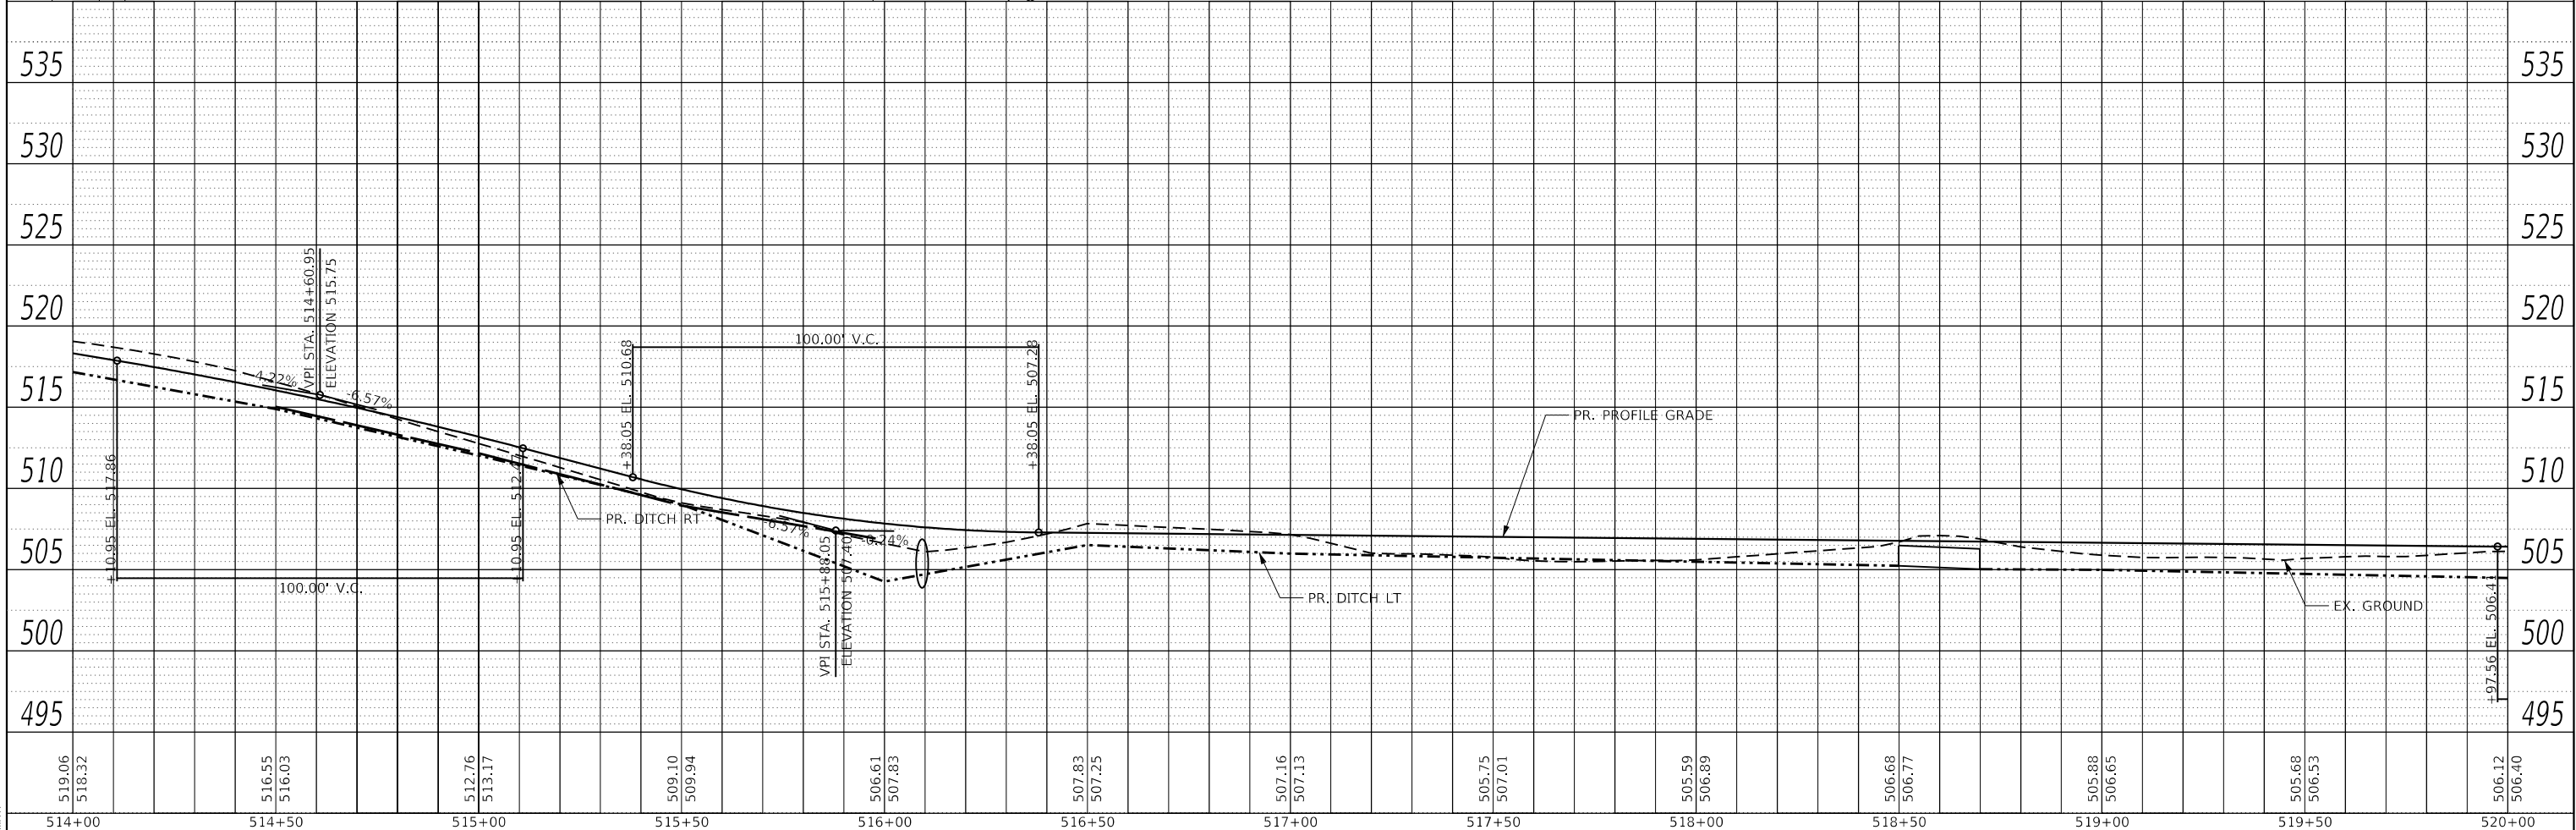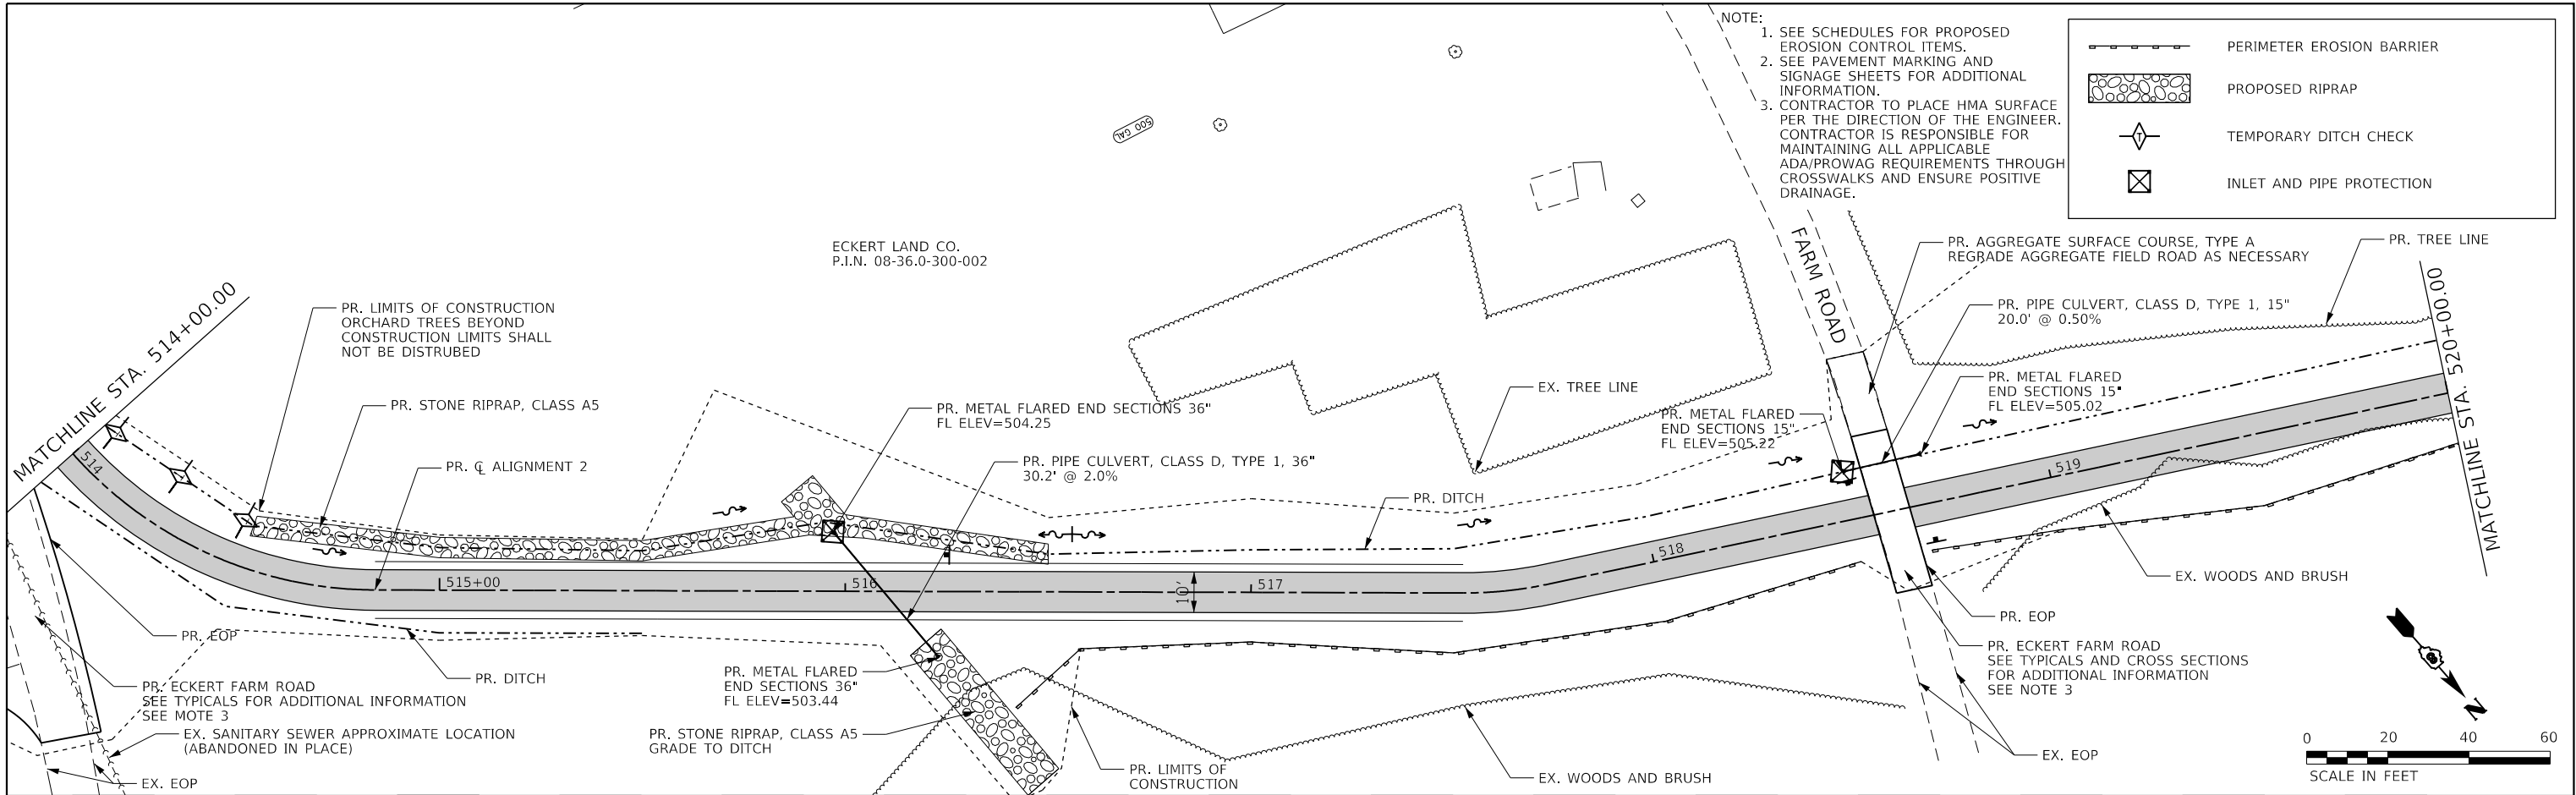


DESIGNED - JRR	REVISED -	THOUVENOT, WADE & MOERCHEN, INC. SWANSEA • WATERLOO • EDWARDSVILLE • ST. LOUIS • ST. CHARLES	CORPORATE OFFICE 4940 Old Collinsville Road Swansea, Illinois 62226 Tel: 618.624.4488 Fax: 618.624.6688  EXCEPTIONAL SERVICE. NOTHING LESS.	 St Clair County Transit District	PLAN AND PROFILE ALIGNMENT 2				Orchard Loop Trail Phase 1		COUNTY	TOTAL SHEETS	SHEET NO.
DRAWN - EKS/TMG	REVISED -										ST. CLAIR	140	40
CHECKED - JWS	REVISED -				PROJECT		JOB NO.		FED. ROAD DIST. NO. ILLINOIS FED. AID PROJECT				
DATE - 03/2018	REVISED -				SCALE: 1" = 20'		SHEET NO. 4 OF 16 SHEETS					STA. 514+00.00 TO STA. 520+00.00	
FILE NAME: I30149-PinPr F018.dgn													

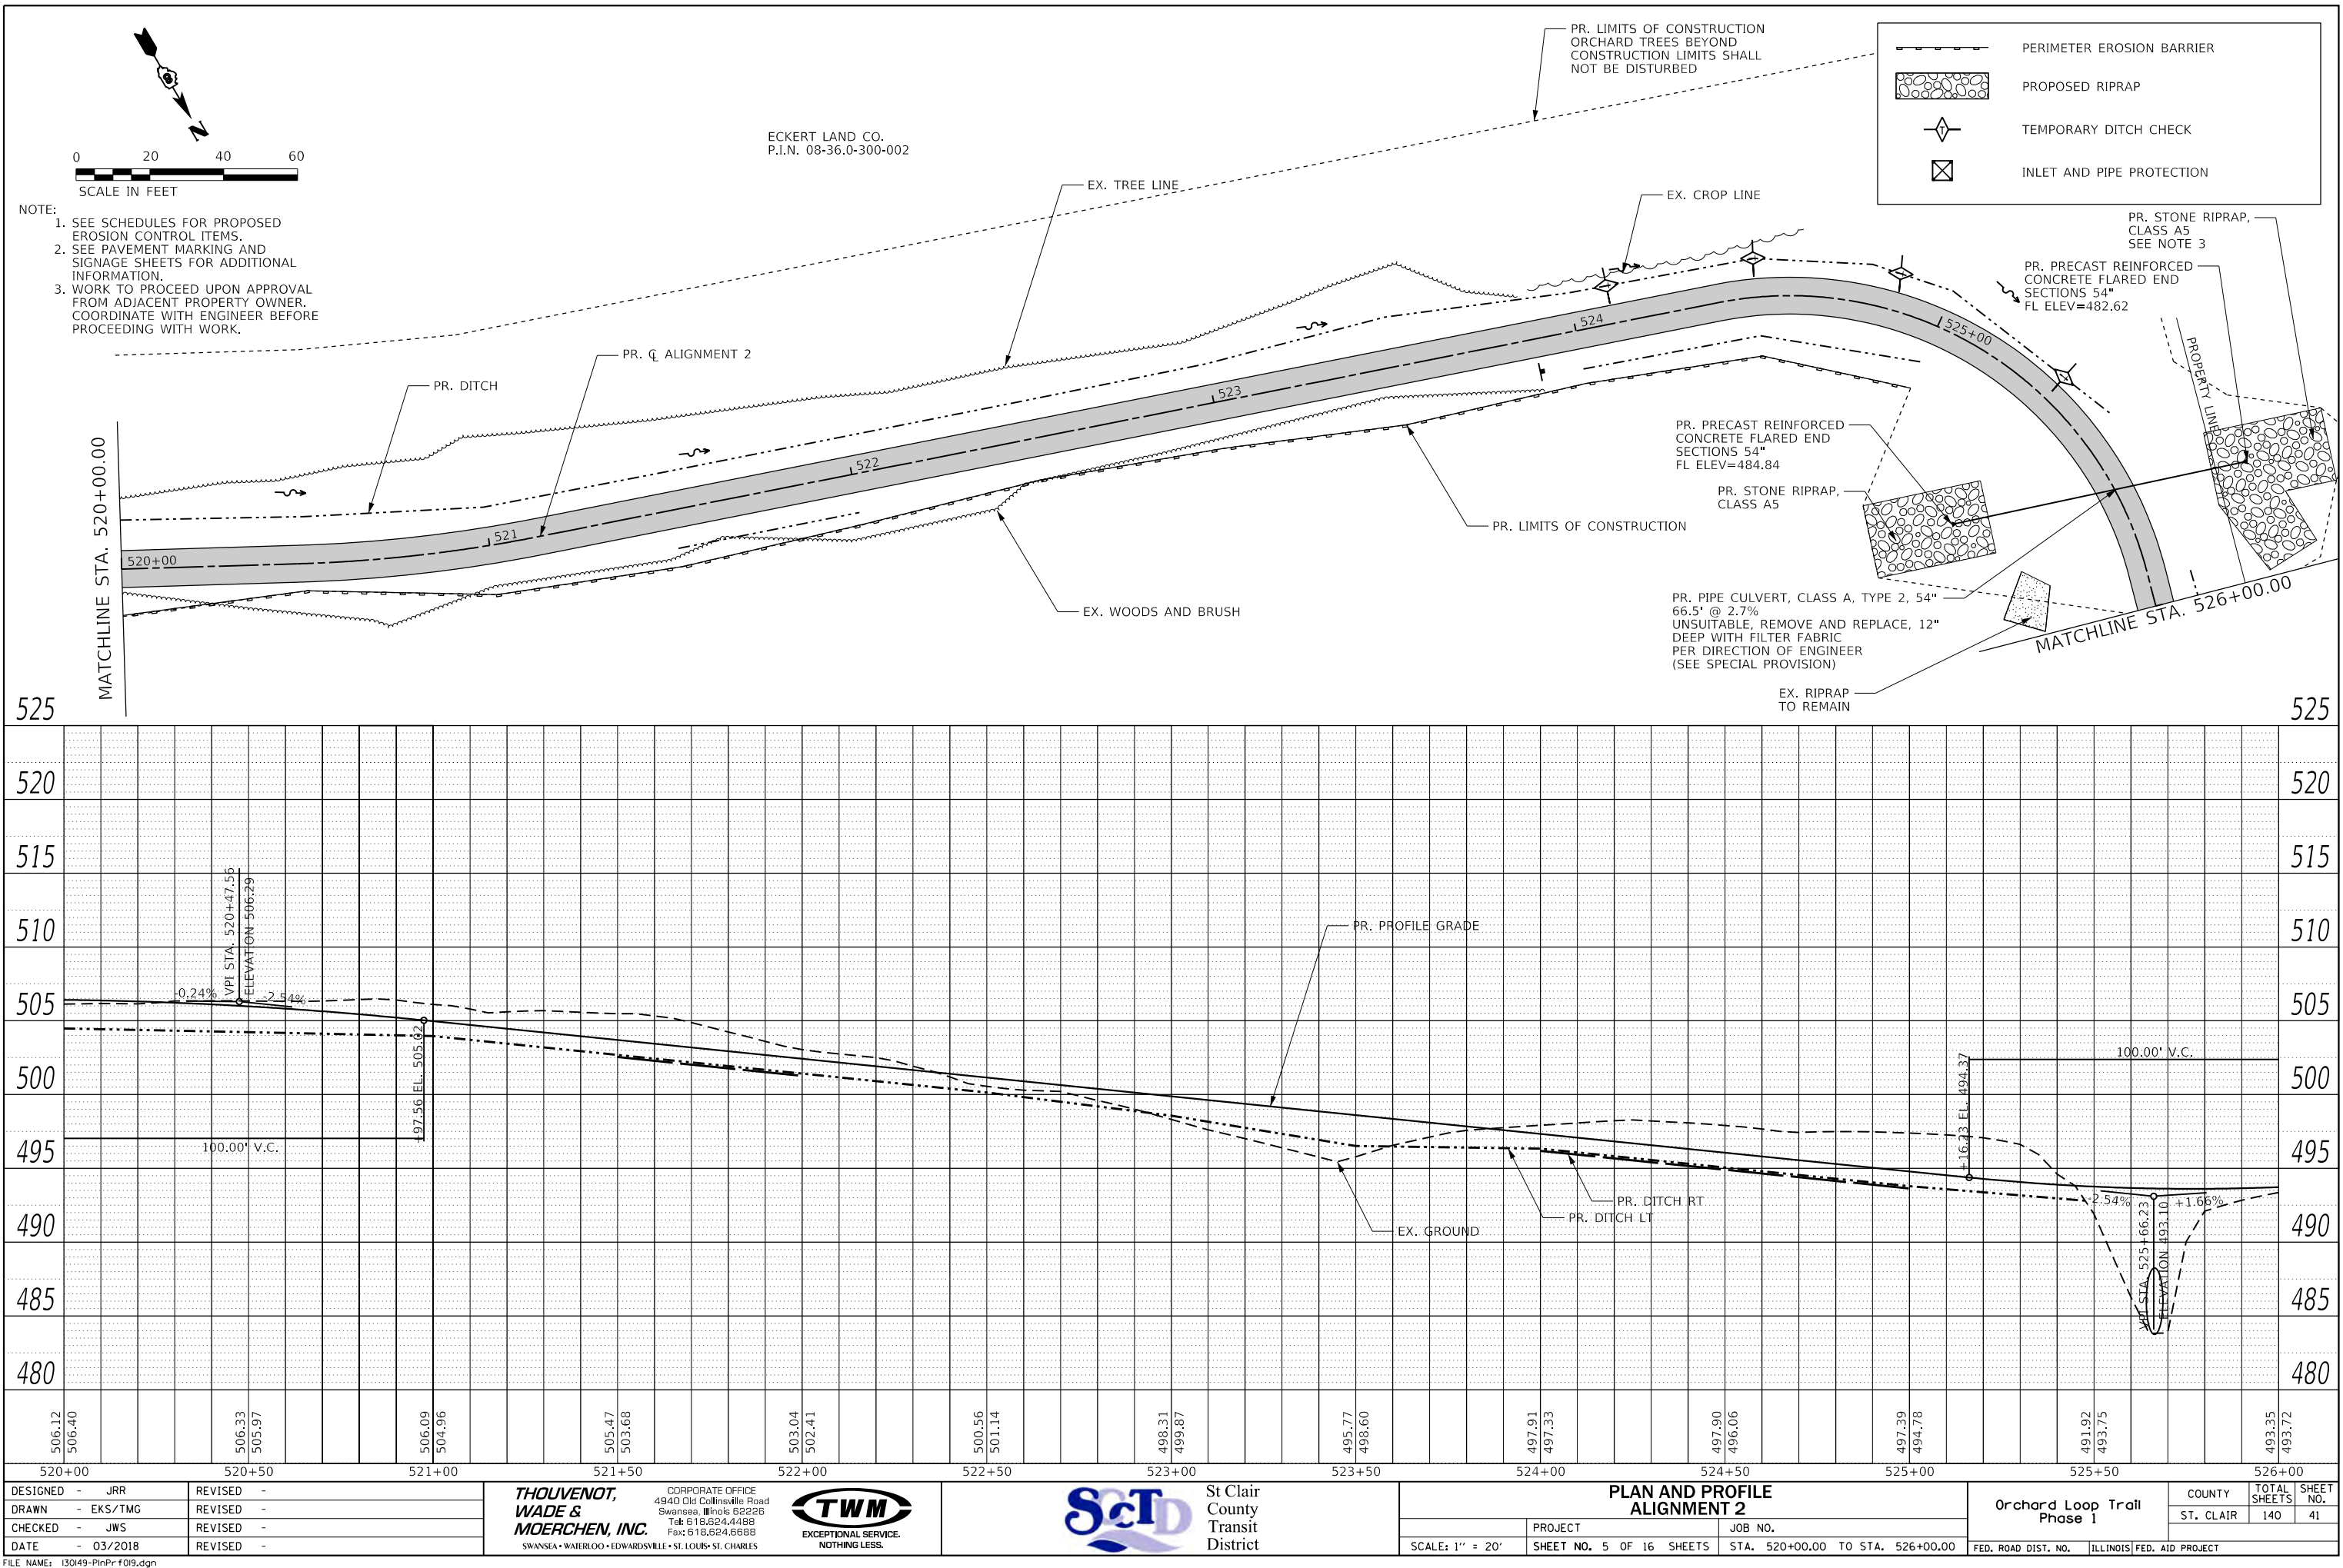


SO. IL AGLAND INC.
P.I.N. 08-35.0-400-014

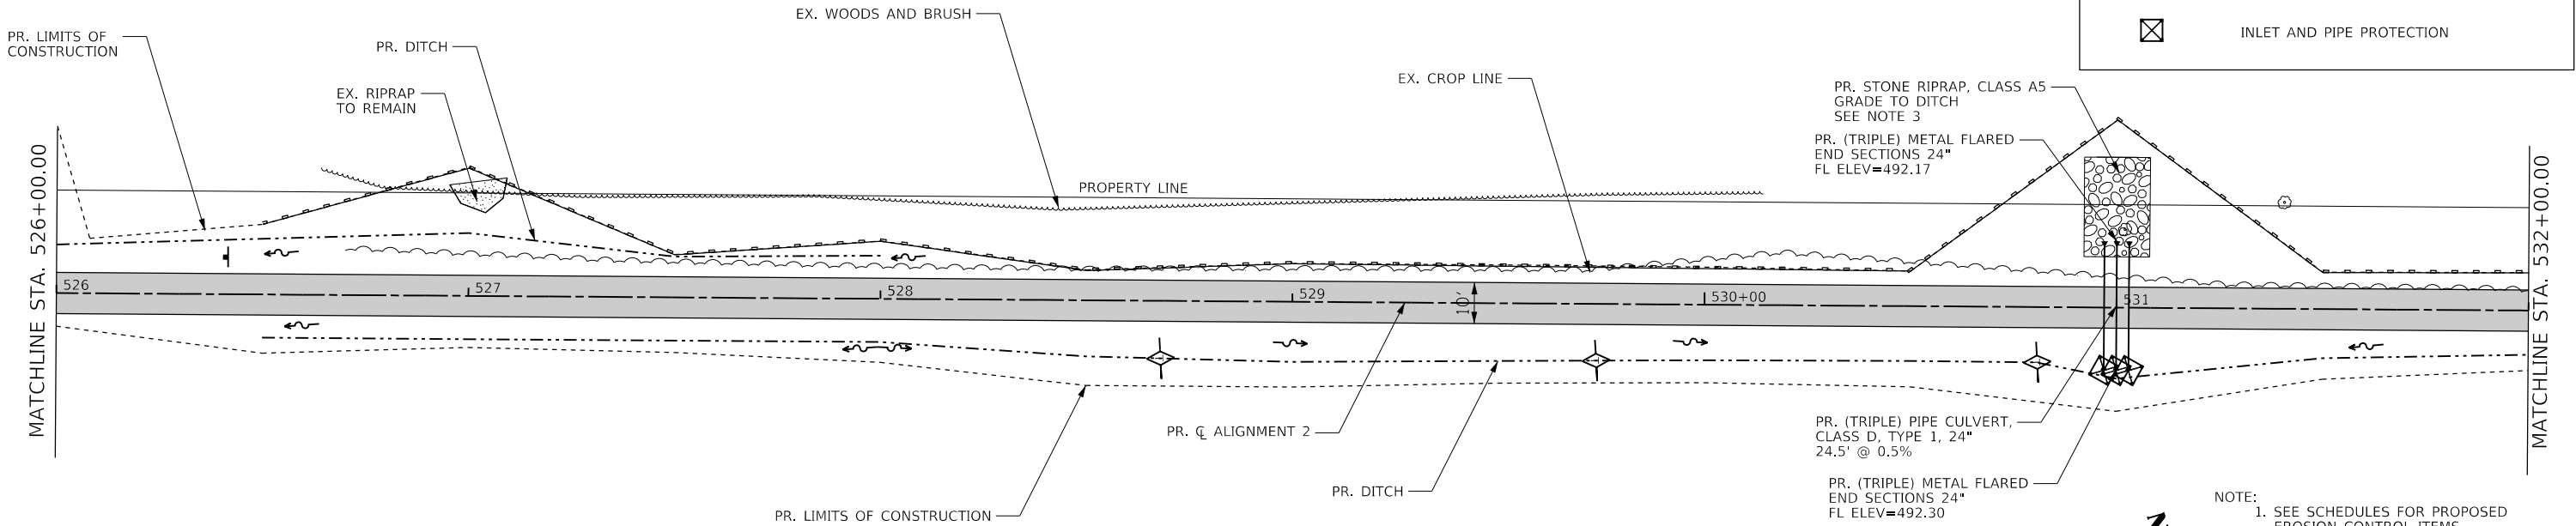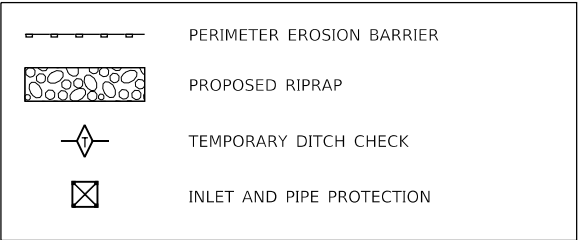

ECKERT LAND CO.
P.I.N. 08-36.0-300-002

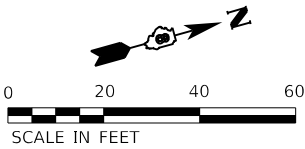

- NOTE:
1. SEE SCHEDULES FOR PROPOSED EROSION CONTROL ITEMS.
 2. SEE PAVEMENT MARKING AND SIGNAGE SHEETS FOR ADDITIONAL INFORMATION.
 3. WORK TO PROCEED UPON APPROVAL FROM ADJACENT PROPERTY OWNER. COORDINATE WITH ENGINEER BEFORE PROCEEDING WITH WORK.

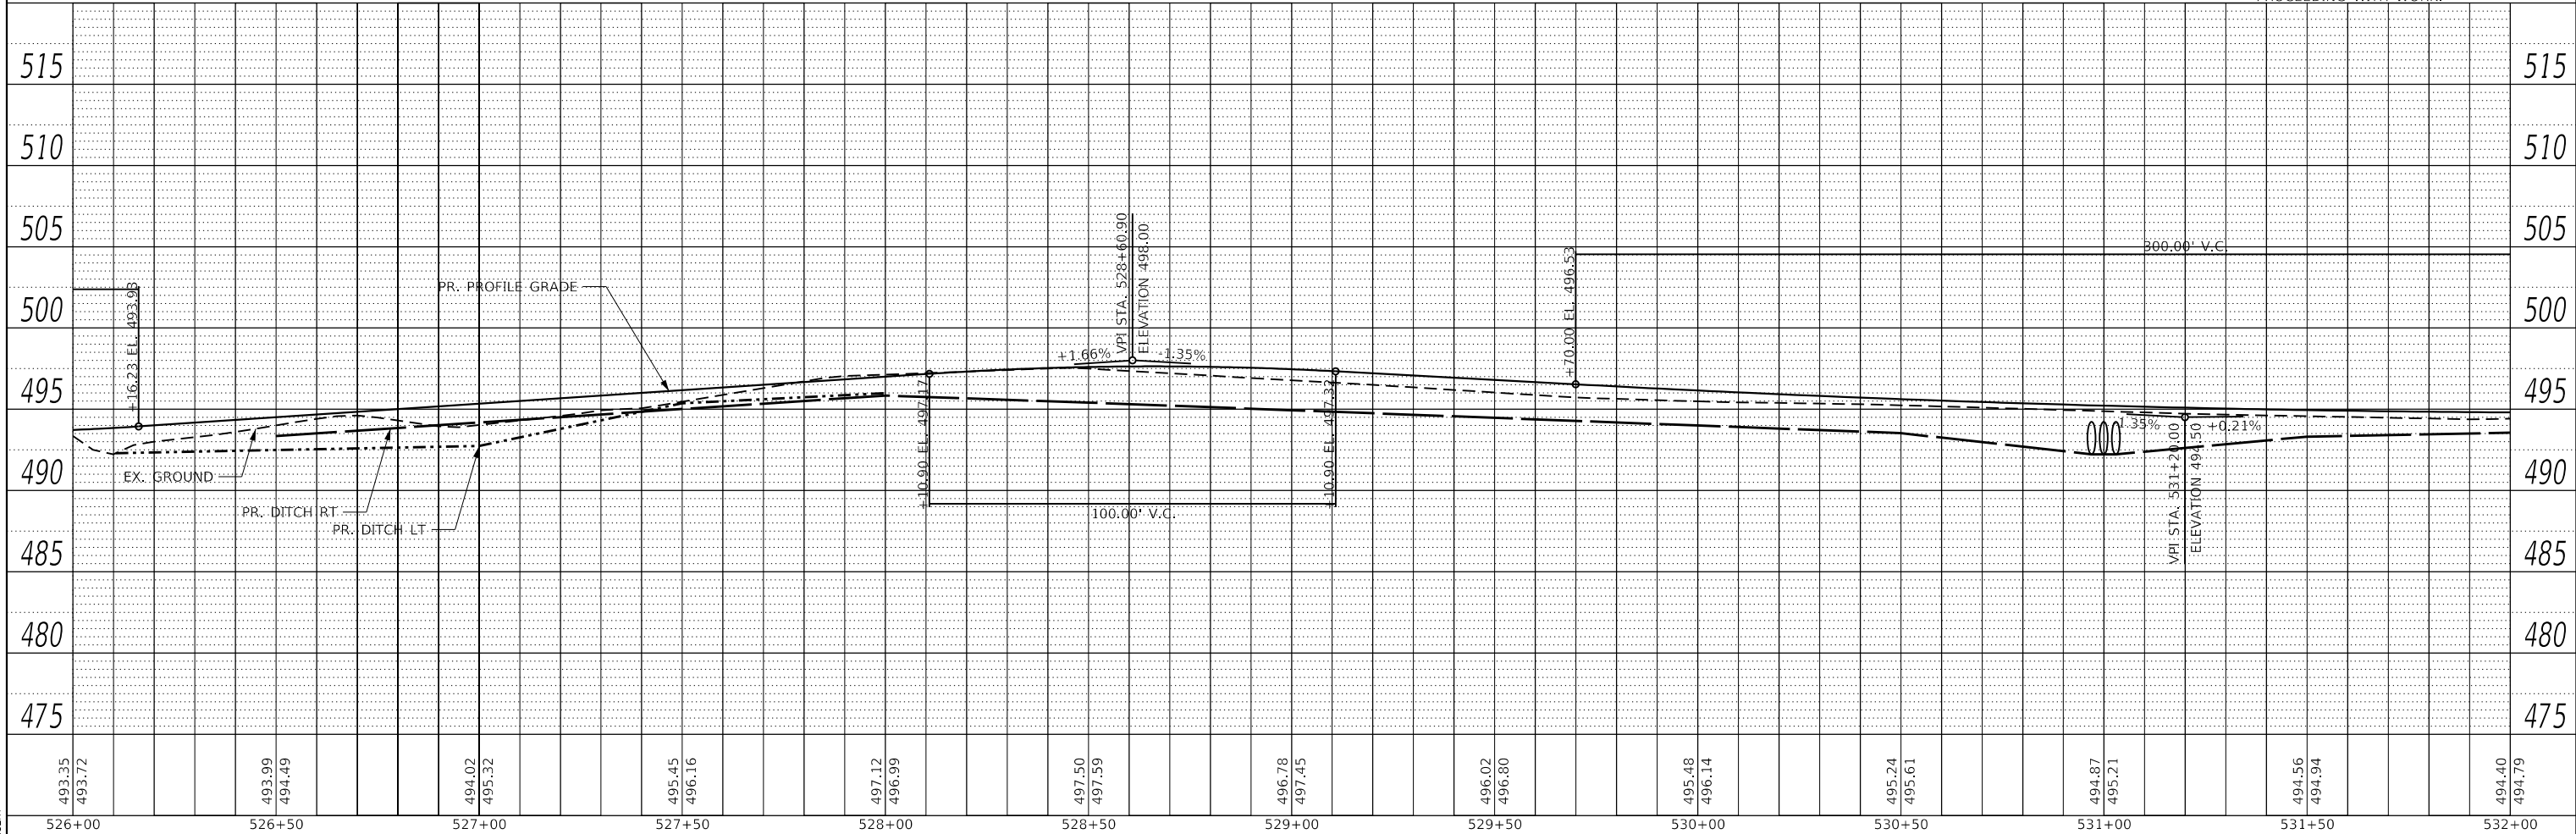

PLOTTED BY: **WJES**

DESIGNED - JRR	REVISED -
DRAWN - EKS/TMG	REVISED -
CHECKED - JWS	REVISED -
DATE - 03/2018	REVISED -

FILE NAME: **FILES**

THOUVENOT, WADE & MOERCHEN, INC.
CORPORATE OFFICE
4940 Old Collinsville Road
Swansea, Illinois 62226
Tel: 618.824.4488
Fax: 618.824.6688




**PLAN AND PROFILE
ALIGNMENT 2**


PROJECT	JOB NO.
SCALE: 1" = 20'	SHEET NO. 6 OF 16 SHEETS
STA. 526+00.00 TO STA. 532+00.00	

**Orchard Loop Trail
Phase 1**


COUNTY	TOTAL SHEETS	SHEET NO.
ST. CLAIR	140	42

 FED. ROAD DIST. NO. ILLINOIS FED. AID PROJECT

	PERIMETER EROSION BARRIER
	PROPOSED RIPRAP
	TEMPORARY DITCH CHECK
	INLET AND PIPE PROTECTION

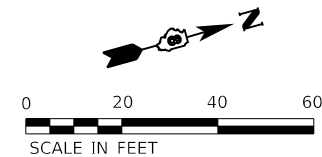


ECKERT LAND CO.
P.I.N. 08-36.0-300-002

 


DESIGNED - JRR	REVISED -	THOUVENOT, WADE & MOERCHEN, INC. SWANSEA • WATERLOO • EDWARDSVILLE • ST. LOUIS • ST. CHARLES	CORPORATE OFFICE 4940 Old Collinsville Road Swansea, Illinois 62226 Tel: 618.624.4498 Fax: 618.624.6698	TWM EXCEPTIONAL SERVICE. NOTHING LESS.	SCTD St Clair County Transit District	PLAN AND PROFILE ALIGNMENT 2			Orchard Loop Trail Phase 1		COUNTY	TOTAL SHEETS	SHEET NO.	
DRAWN - EKS/TMG	REVISED -										ST. CLAIR	140	43	
CHECKED - JWS	REVISED -								PROJECT	JOB NO.				
DATE - 03/2018	REVISED -								SCALE: 1" = 20'	SHEET NO. 7 OF 16 SHEETS	STA. 532+00.00 TO STA. 538+00.00	FED. ROAD DIST. NO. ILLINOIS FED. AID PROJECT		


SO. IL AGLAND INC.
P.I.N. 08-35.0-400-014

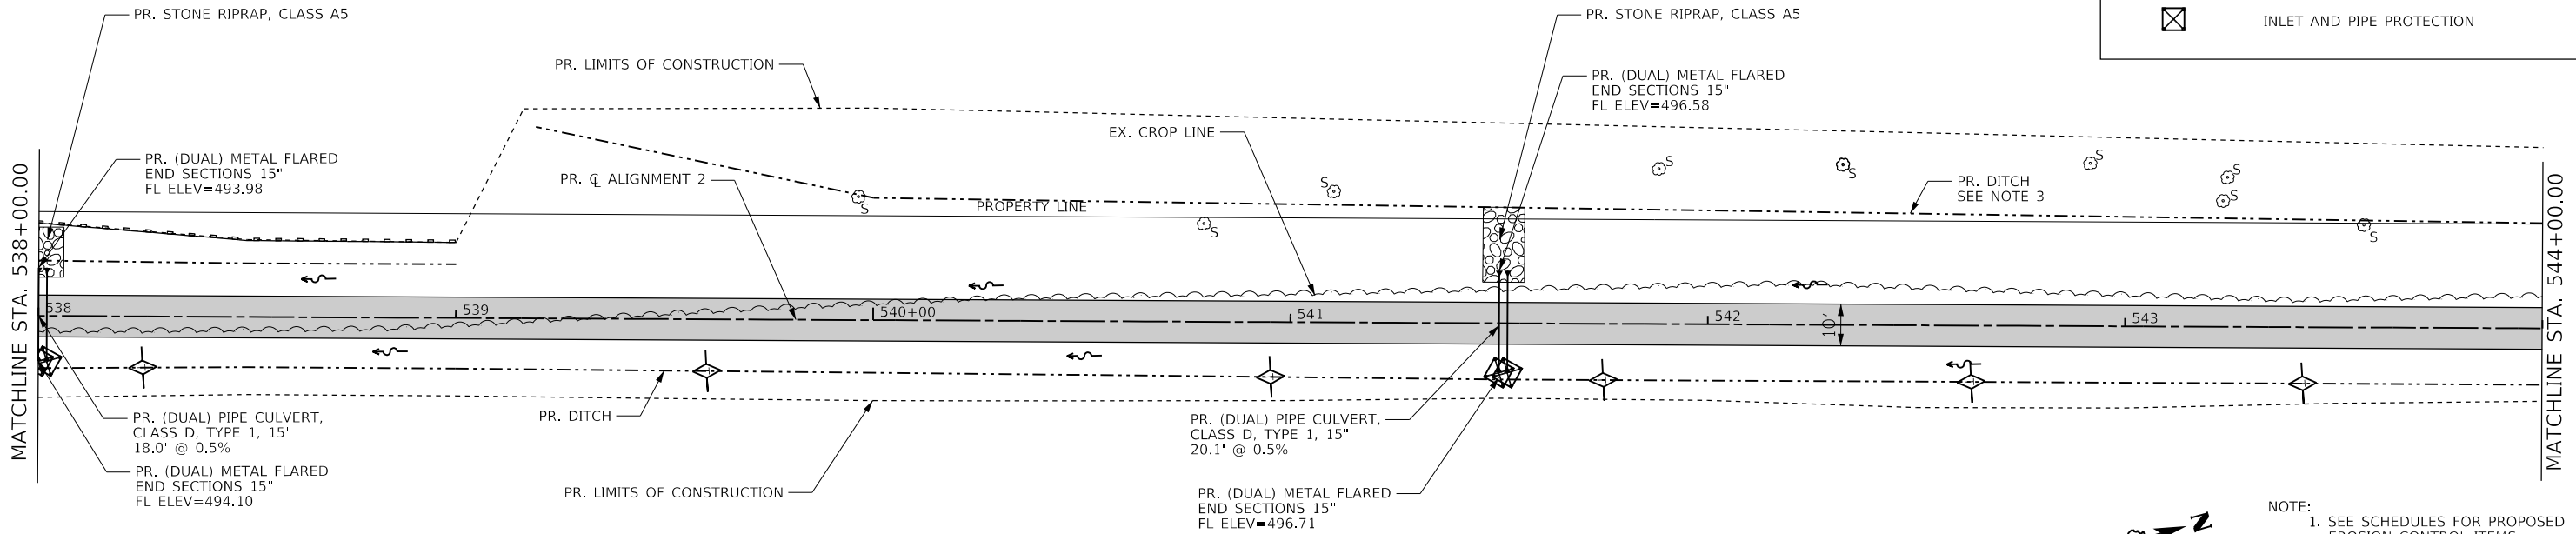

ECKERT LAND CO.
P.I.N. 08-36.0-300-002

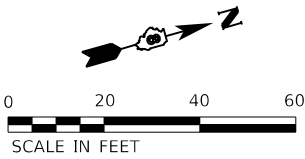

- NOTE:
1. SEE SCHEDULES FOR PROPOSED EROSION CONTROL ITEMS.
 2. SEE PAVEMENT MARKING AND SIGNAGE SHEETS FOR ADDITIONAL INFORMATION.
 3. WORK TO PROCEED UPON APPROVAL FROM ADJACENT PROPERTY OWNER. COORDINATE WITH ENGINEER BEFORE PROCEEDING WITH WORK.

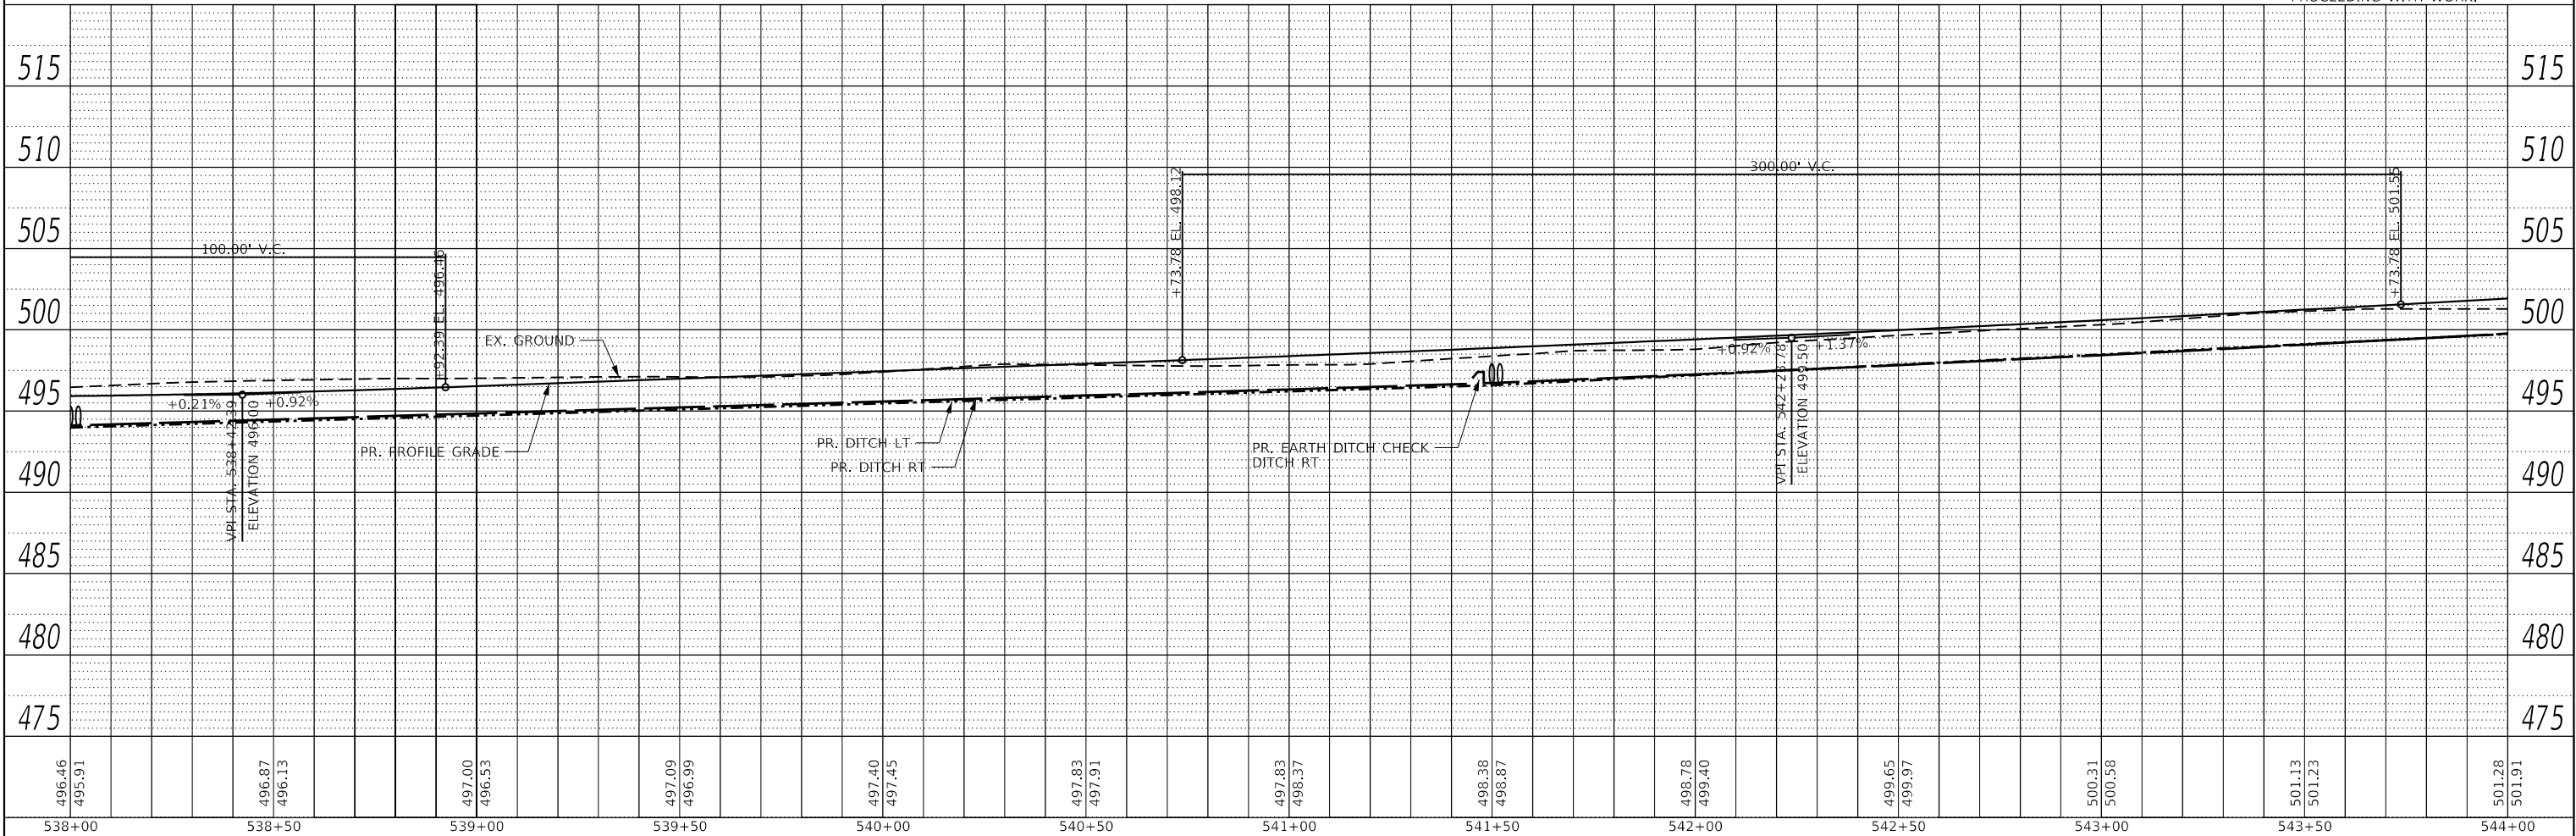

PLotted BY: #USER\$
FILE NAME: #FILES\$

DESIGNED - JRR	REVISED -
DRAWN - EKS/TMG	REVISED -
CHECKED - JWS	REVISED -
DATE - 03/2018	REVISED -

**THOUVENOT,
WADE &
MOERCHEN, INC.**
CORPORATE OFFICE
4940 Old Collinsville Road
Swansea, Illinois 62226
Tel: 618.824.4488
Fax: 618.824.6688
SWANSEA • WATERLOO • EDWARDSVILLE • ST. LOUIS • ST. CHARLES




St Clair
County
Transit
District

**PLAN AND PROFILE
ALIGNMENT 2**

PROJECT	JOB NO.
SCALE: 1" = 20'	SHEET NO. 8 OF 16 SHEETS
STA. 538+00.00 TO STA. 544+00.00	

Orchard Loop Trail
Phase 1

COUNTY	TOTAL SHEETS	SHEET NO.
ST. CLAIR	140	44
FED. ROAD DIST. NO.	ILLINOIS	FED. AID PROJECT

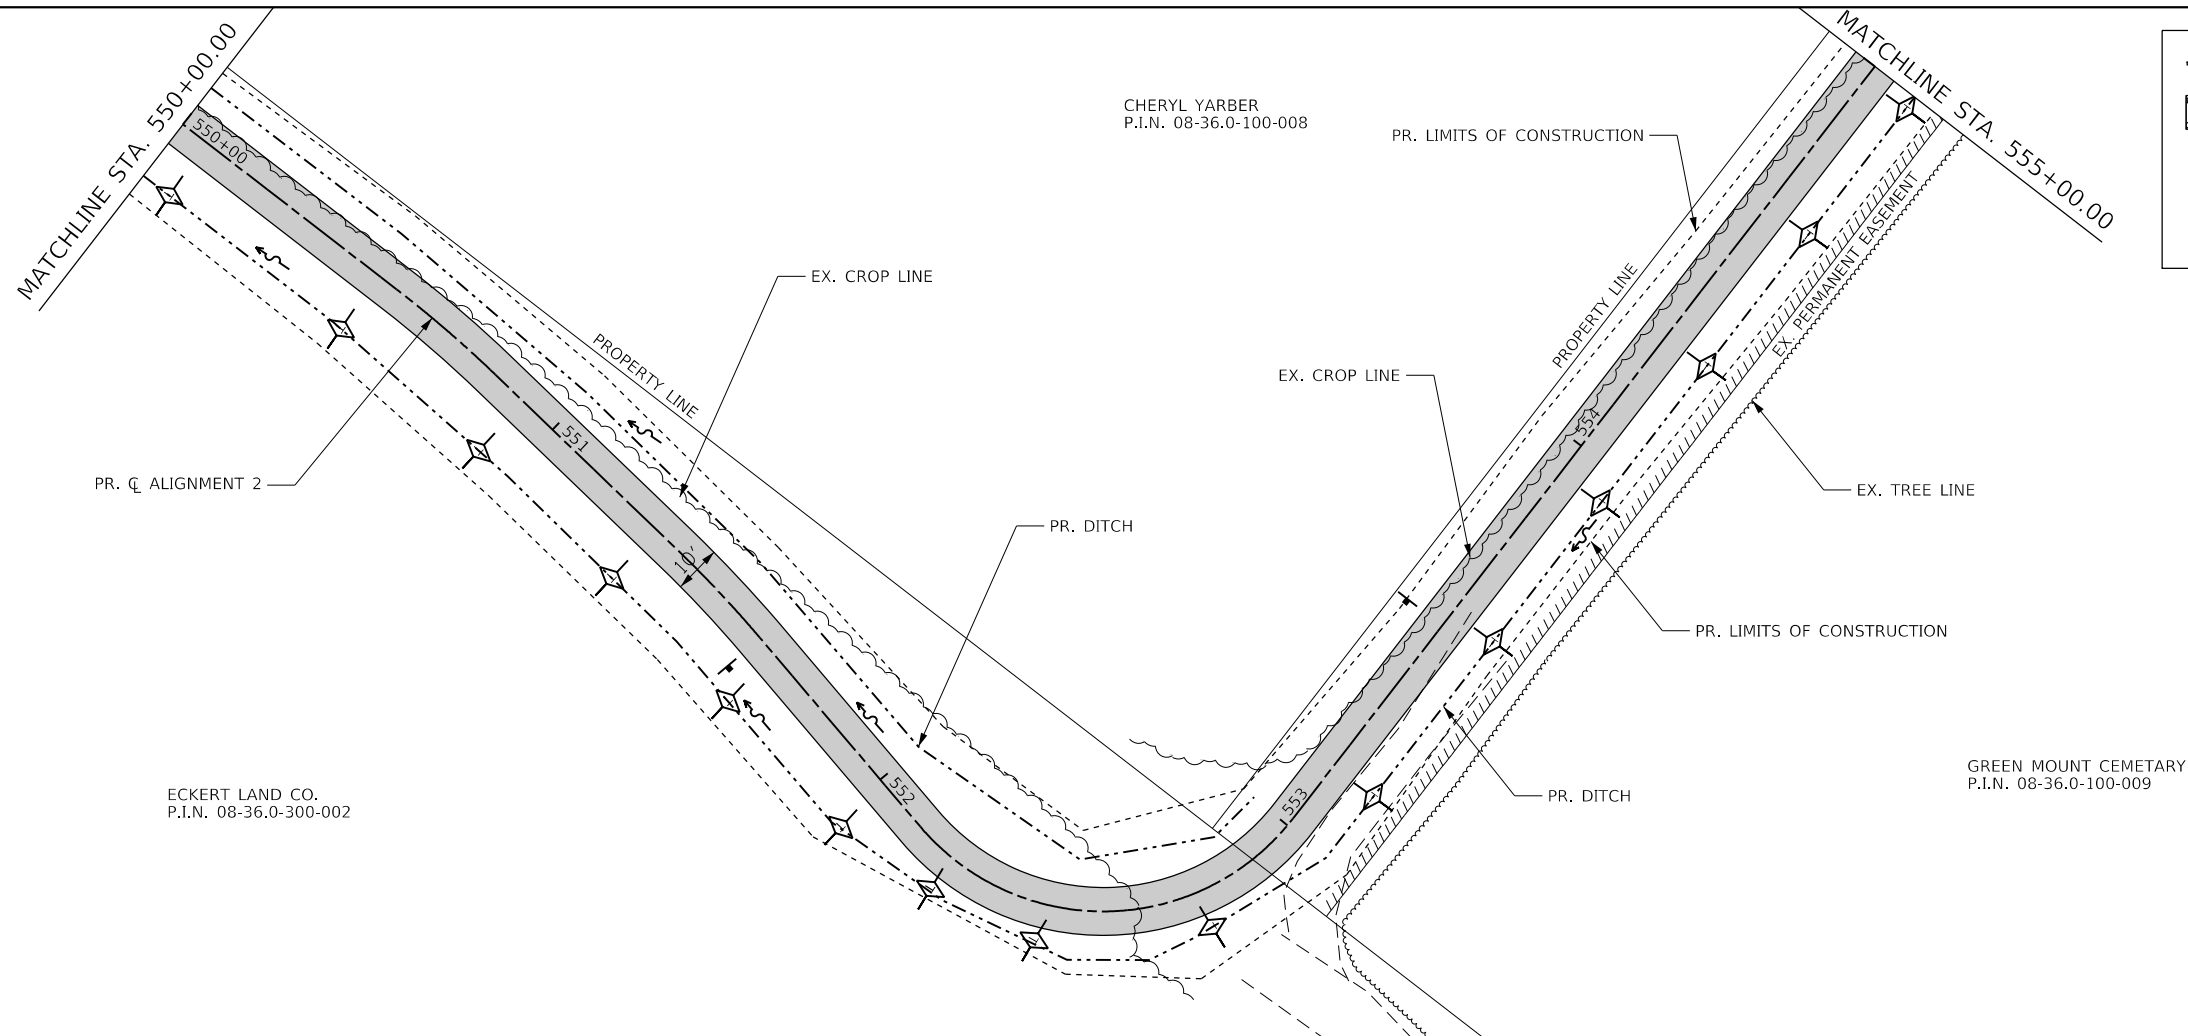


PERIMETER EROSION BARRIER


PROPOSED RIPRAP

TEMPORARY DITCH CHECK

INLET AND PIPE PROTECTION

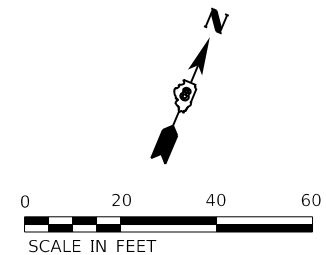

NOTE:
1. SEE SCHEDULES FOR PROPOSED EROSION CONTROL ITEMS.
2. SEE PAVEMENT MARKING AND SIGNAGE SHEETS FOR ADDITIONAL INFORMATION.

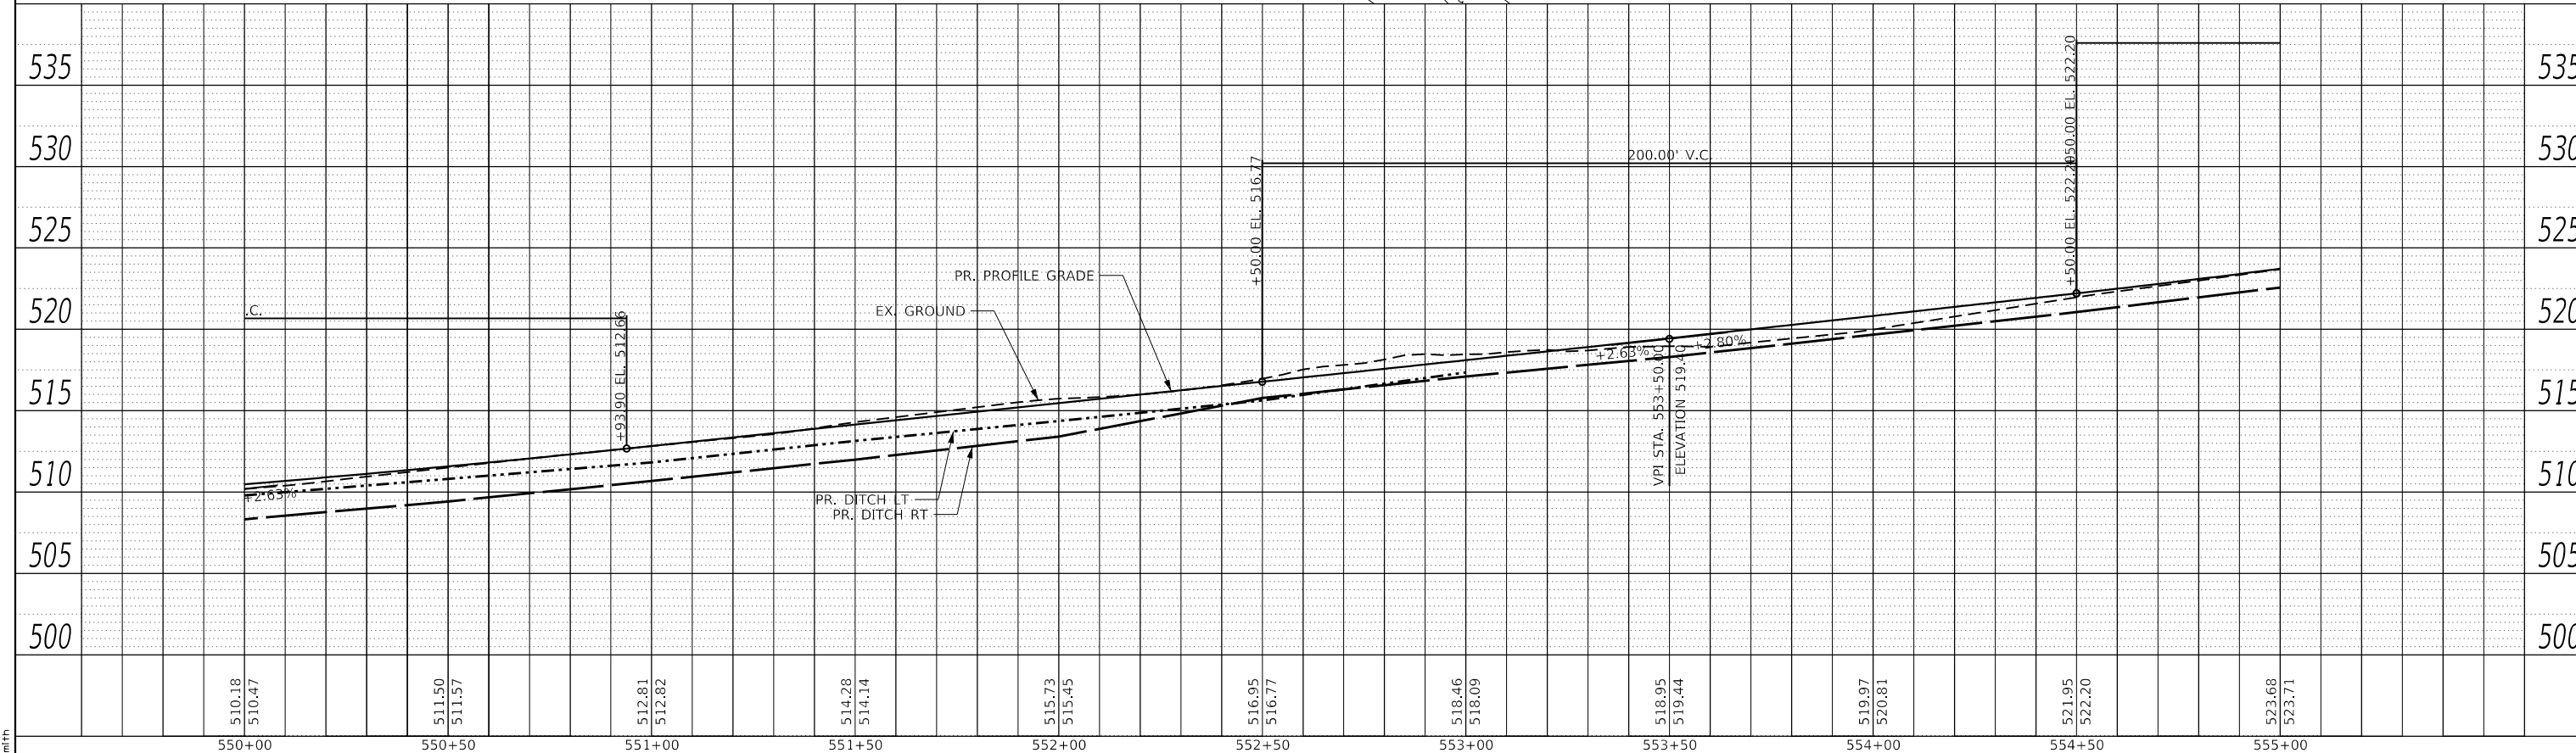


PLOTTED BY: FILE NAME: I30149-PlnPr-f024.dgn	DESIGNED - JRR	REVISED -	THOUVENOT, WADE & MOERCHEN, INC. SWANSEA • WATERLOO • EDWARDSVILLE • ST. LOUIS • ST. CHARLES	CORPORATE OFFICE 4940 Old Collinsville Road Swansea, Illinois 62226 Tel: 618.624.4488 Fax: 618.624.6688	 EXCEPTIONAL SERVICE. NOTHING LESS.	 St Clair County Transit District	PLAN AND PROFILE ALIGNMENT 2				Orchard Loop Trail Phase 1		COUNTY	TOTAL SHEETS	SHEET NO.
	DRAWN - EKS/TMG	REVISED -											ST. CLAIR	140	46
	CHECKED - JWS	REVISED -													
	DATE - 03/2018	REVISED -													
	SCALE: 1" = 20'						PROJECT	JOB NO.	SHEET NO. 10 OF 16 SHEETS		STA. 550+00.00 TO STA. 555+00.00		FED. ROAD DIST. NO.	ILLINOIS	FED. AID PROJECT

PLOTTED BY: esmith
FILE NAME: I30149-PinPr f024.dgn


CHERYL YARBER
P.I.N. 08-36.0-100-008

  PERIMETER EROSION BARRIER

 PROPOSED RIPRAP


 TEMPORARY DITCH CHECK

 INLET AND PIPE PROTECTION

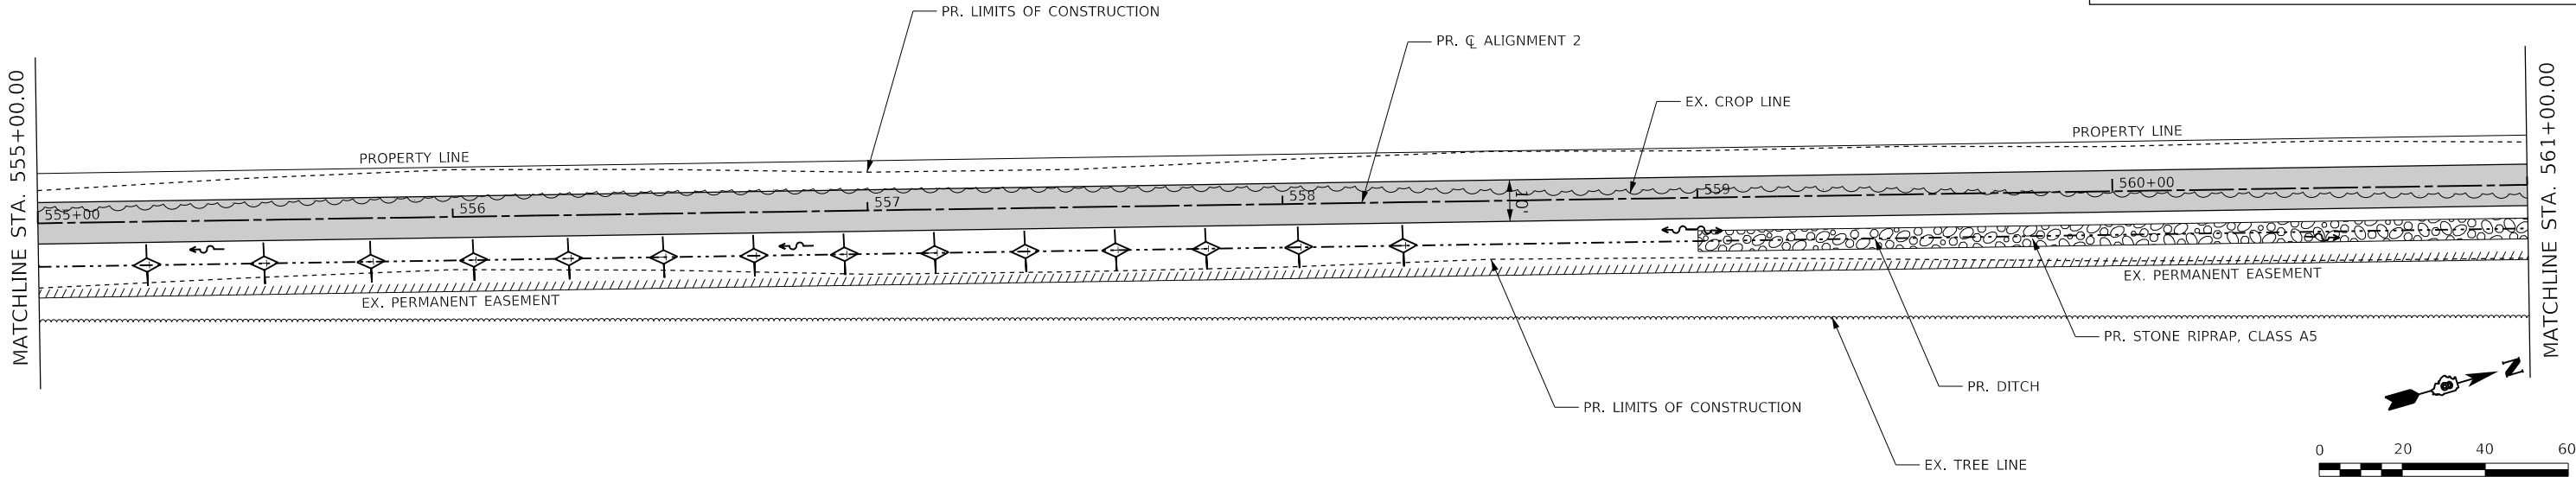

GREEN MOUNT CEMETARY
P.I.N. 08-36.0-100-009

NOTE:
1. SEE SCHEDULES FOR PROPOSED EROSION CONTROL ITEMS.
2. SEE PAVEMENT MARKING AND SIGNAGE SHEETS FOR ADDITIONAL INFORMATION.

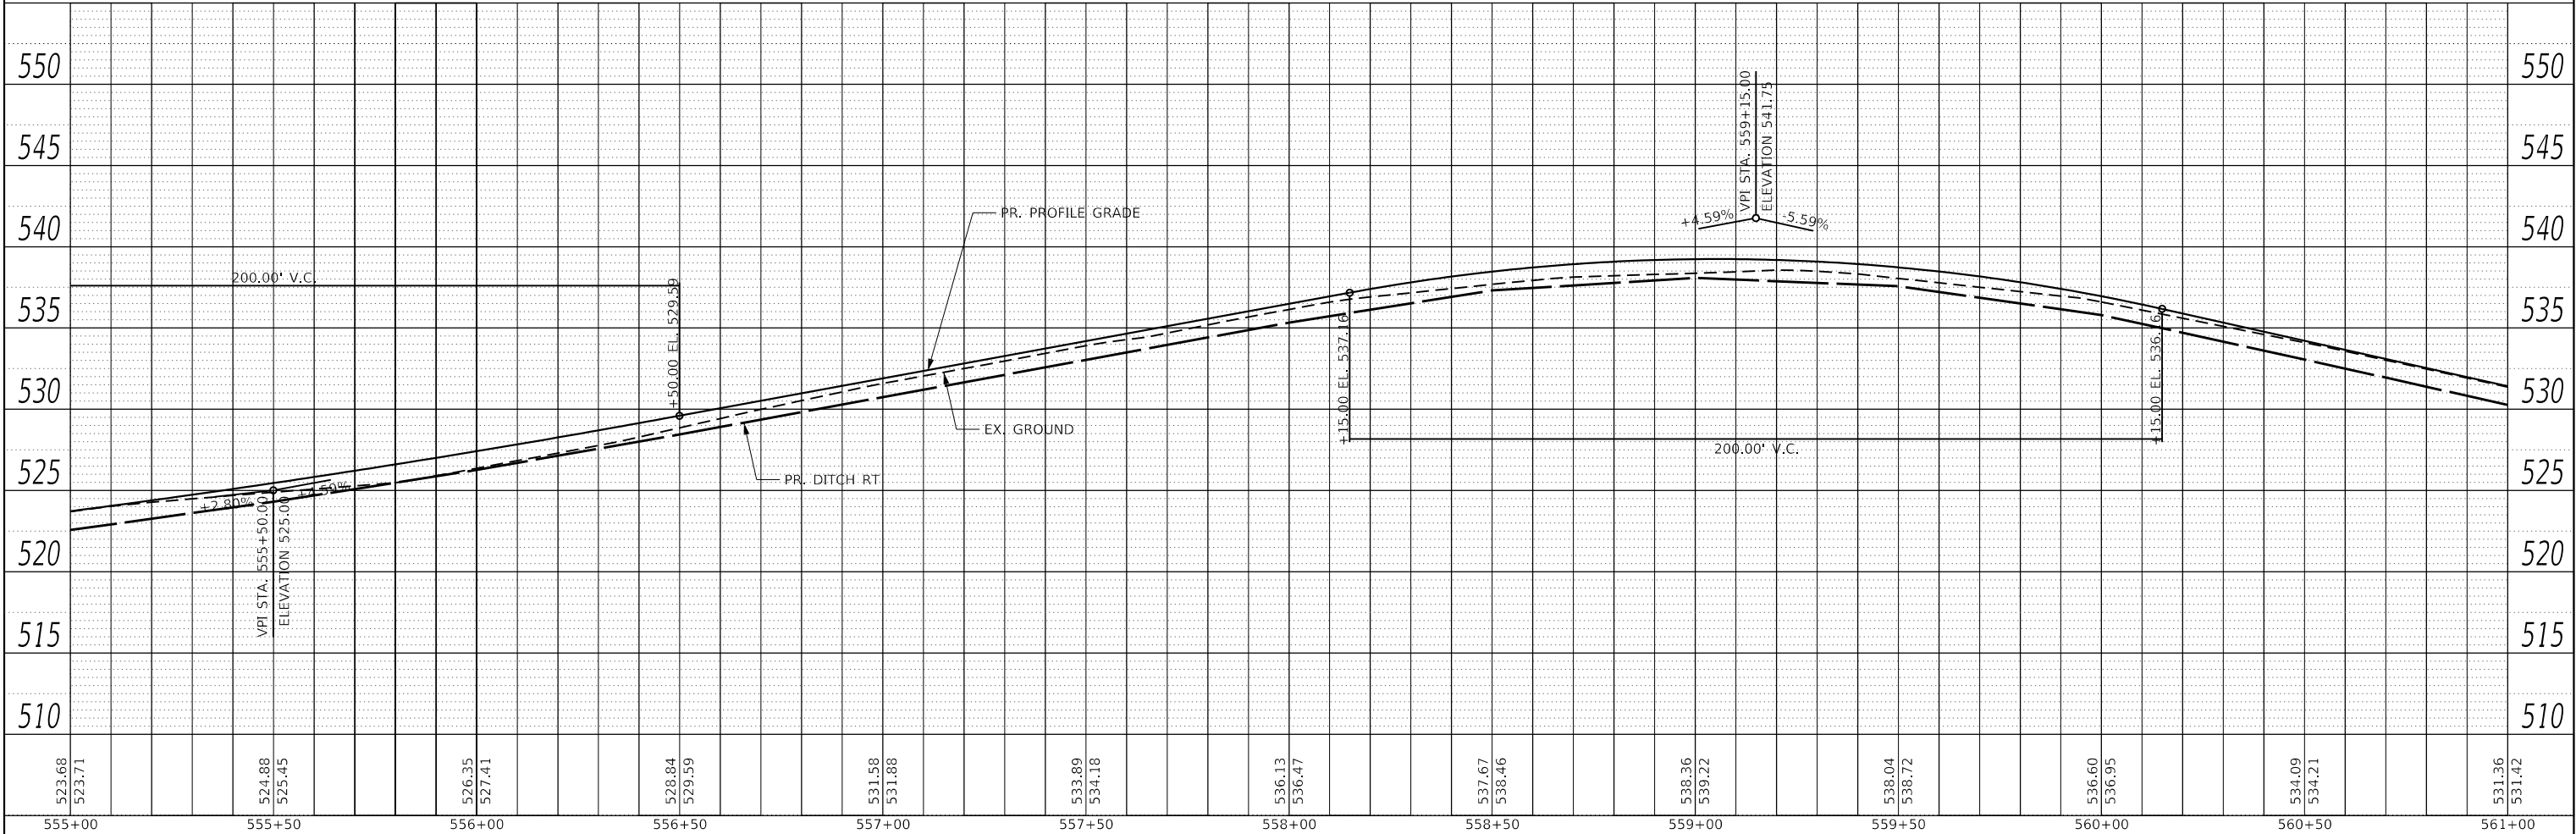

PLOTTED BY: esmith

DESIGNED - JRR	REVISED -
DRAWN - EKS/TMG	REVISED -
CHECKED - JWS	REVISED -
DATE - 03/2018	REVISED -

**THOUVENOT,
WADE &
MOERCHEN, INC.**
SWANSEA • WATERLOO • EDWARDSVILLE • ST. LOUIS • ST. CHARLES

CORPORATE OFFICE
4940 Old Collinsville Road
Swansea, Illinois 62226
Tel: 618.624.4488
Fax: 618.624.6688



St Clair
County
Transit
District



PLAN AND PROFILE
ALIGNMENT 2


PROJECT	JOB NO.
SCALE: 1" = 20'	SHEET NO. 11 OF 16 SHEETS
STA. 555+00.00 TO STA. 561+00.00	

Orchard Loop Trail
Phase 1


COUNTY	TOTAL SHEETS	SHEET NO.
ST. CLAIR	140	47
FED. ROAD DIST. NO.	ILLINOIS	FED. AID PROJECT

CHERYL YARBER
P.I.N. 08-36.0-100-008

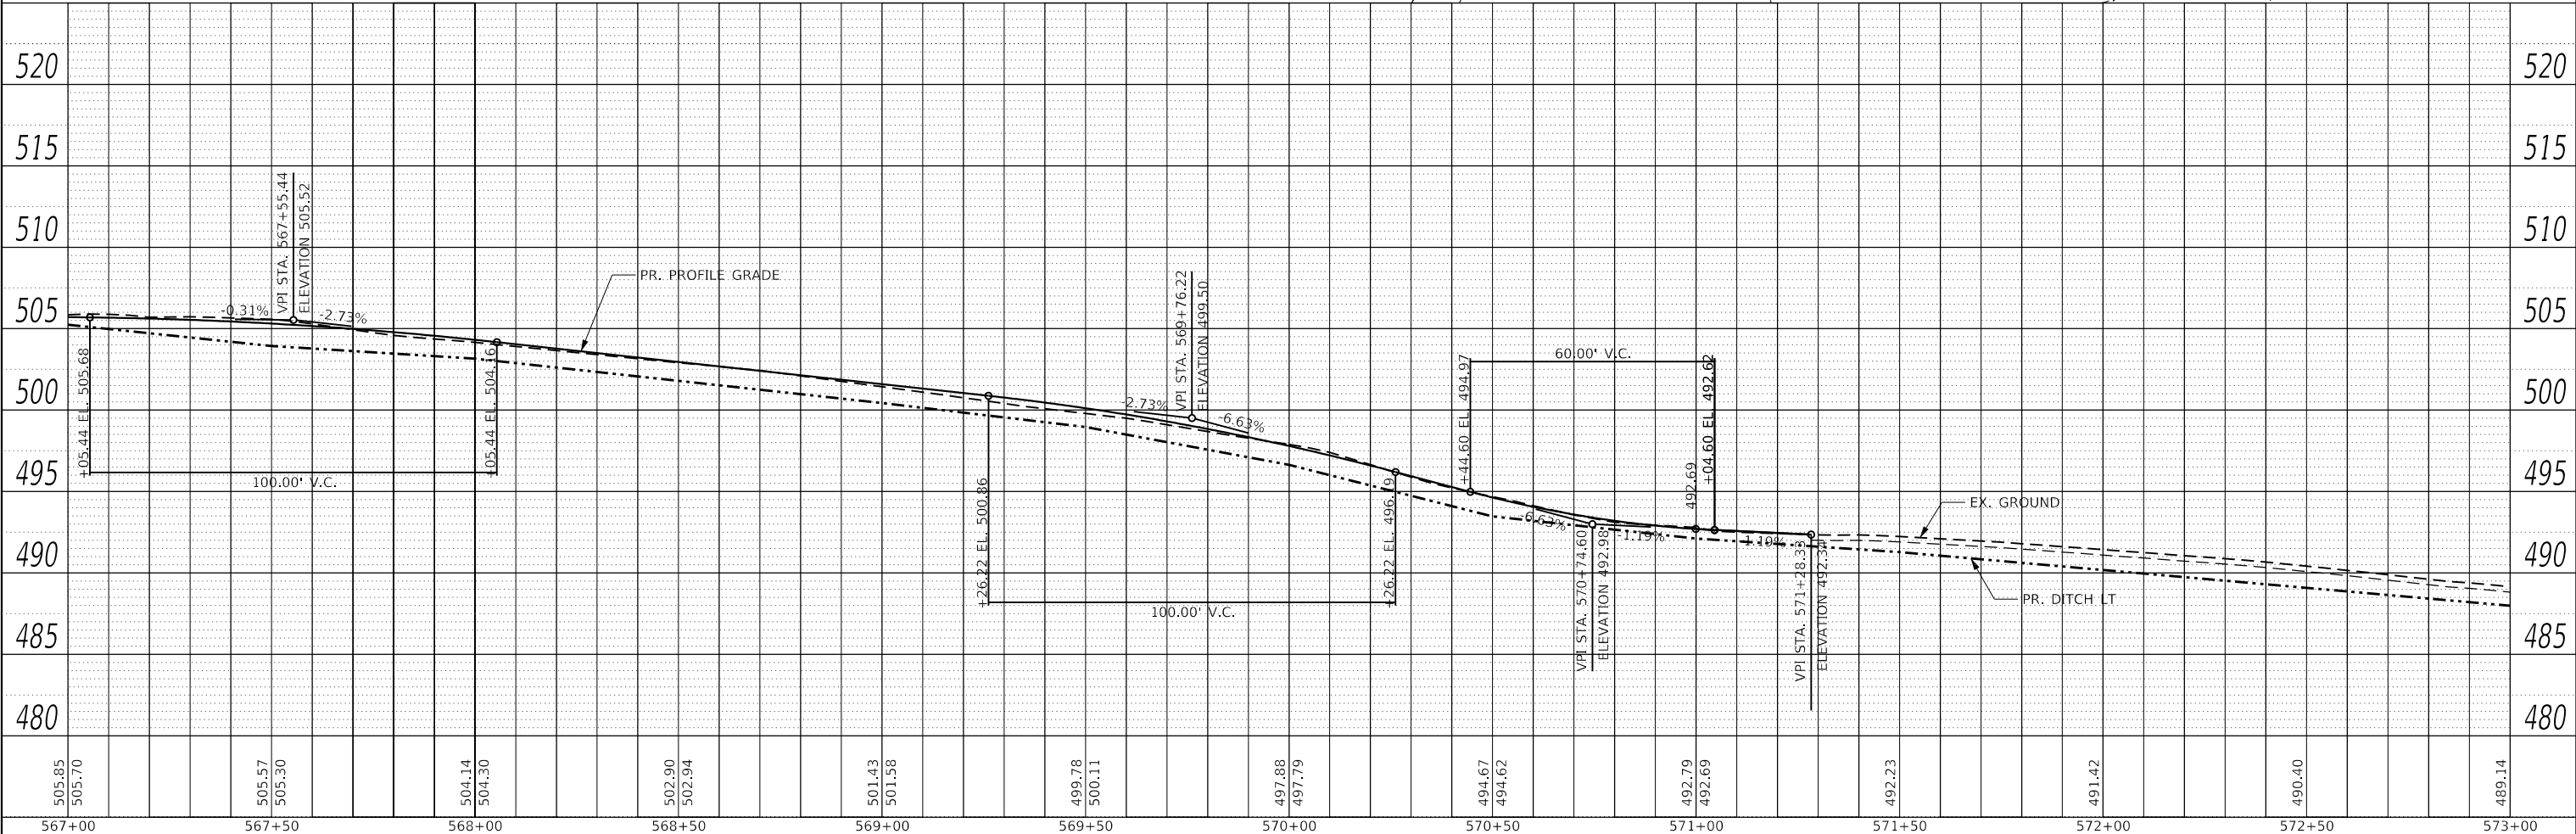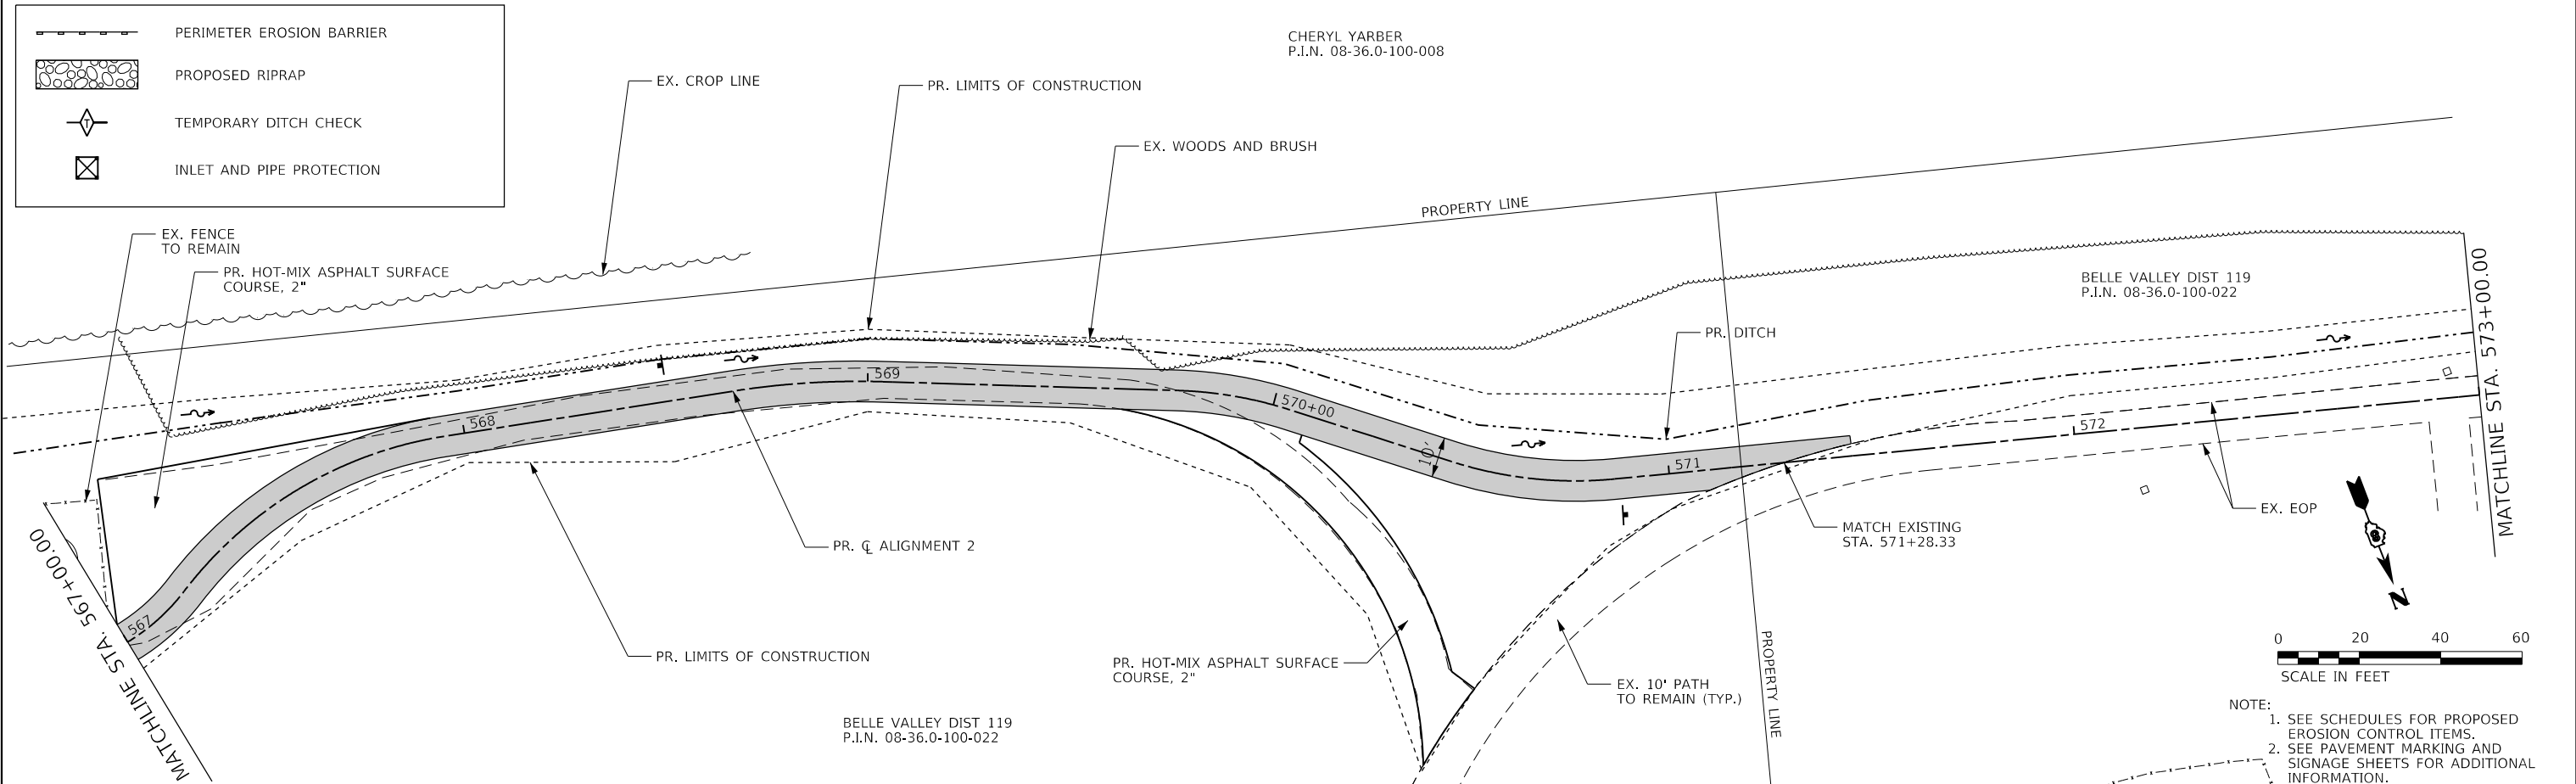


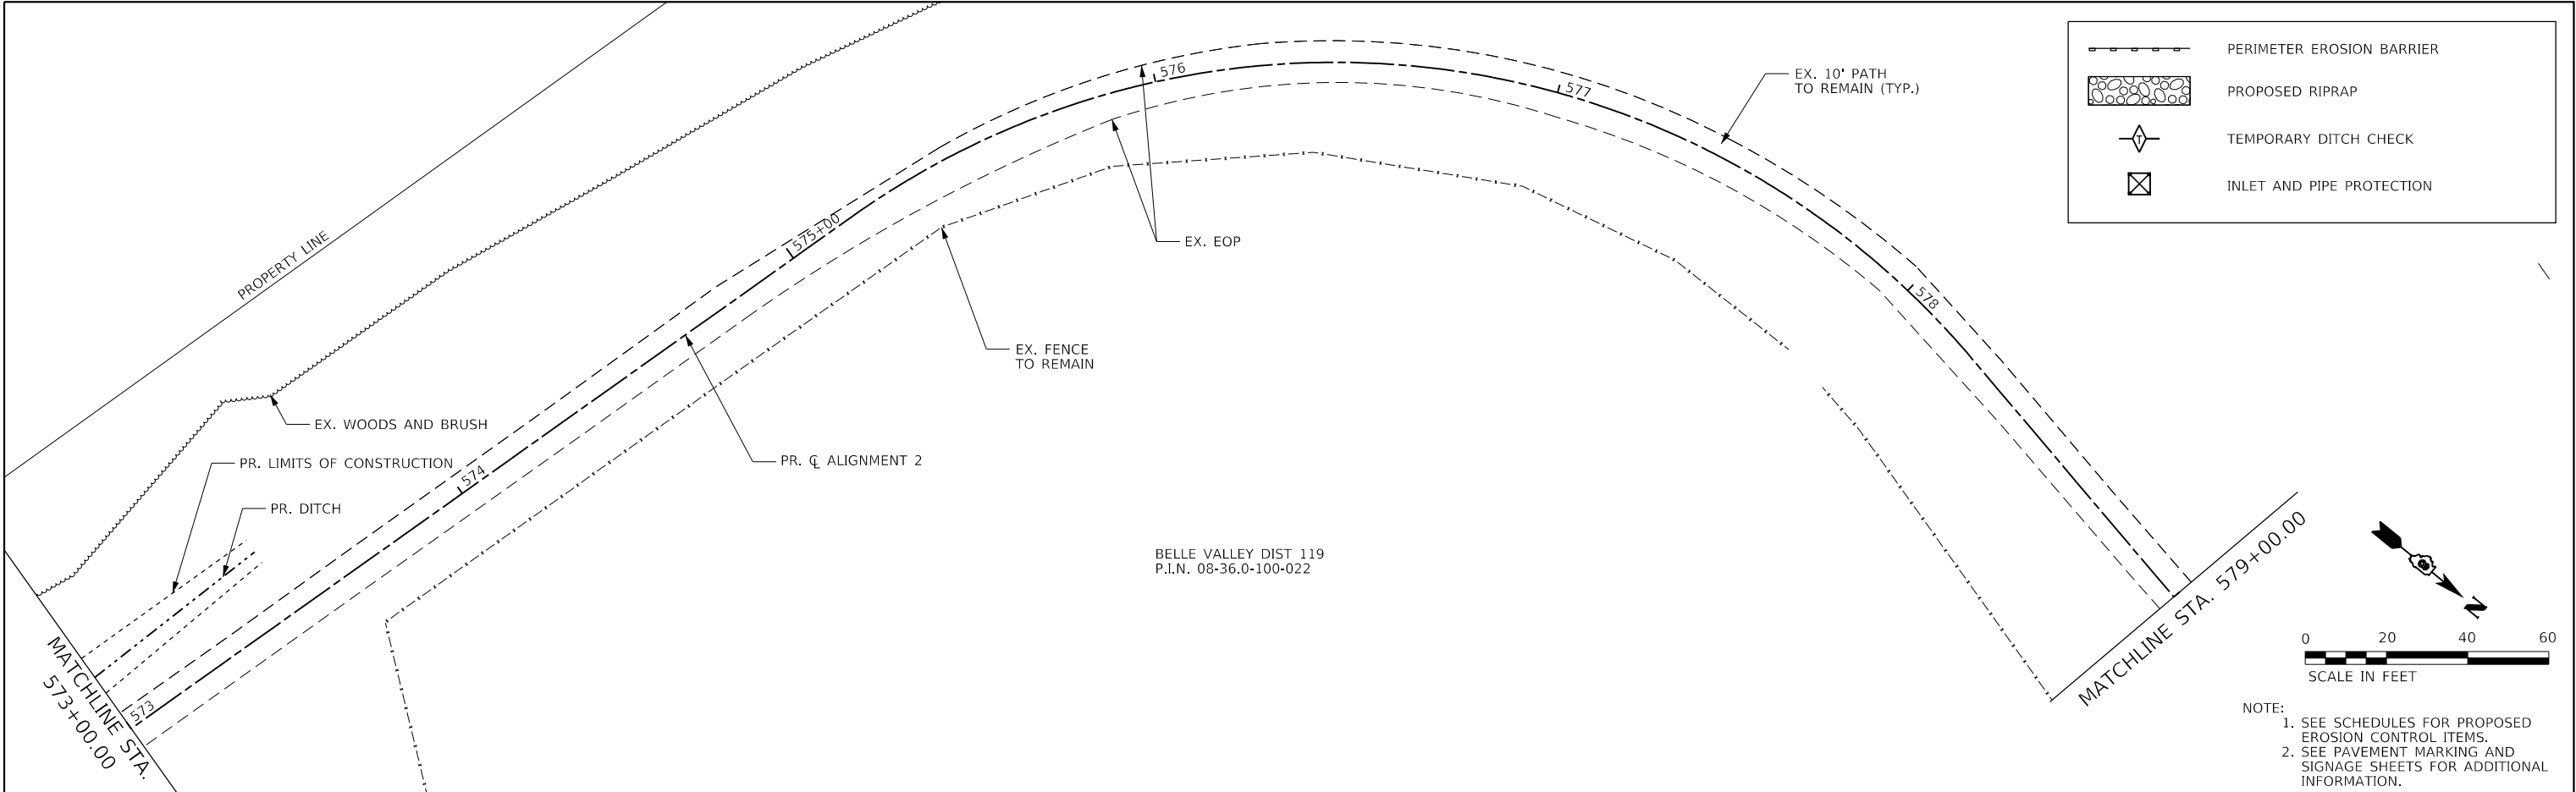




NOTE:
1. SEE SCHEDULES FOR PROPOSED EROSION CONTROL ITEMS.
2. SEE PAVEMENT MARKING AND SIGNAGE SHEETS FOR ADDITIONAL INFORMATION.

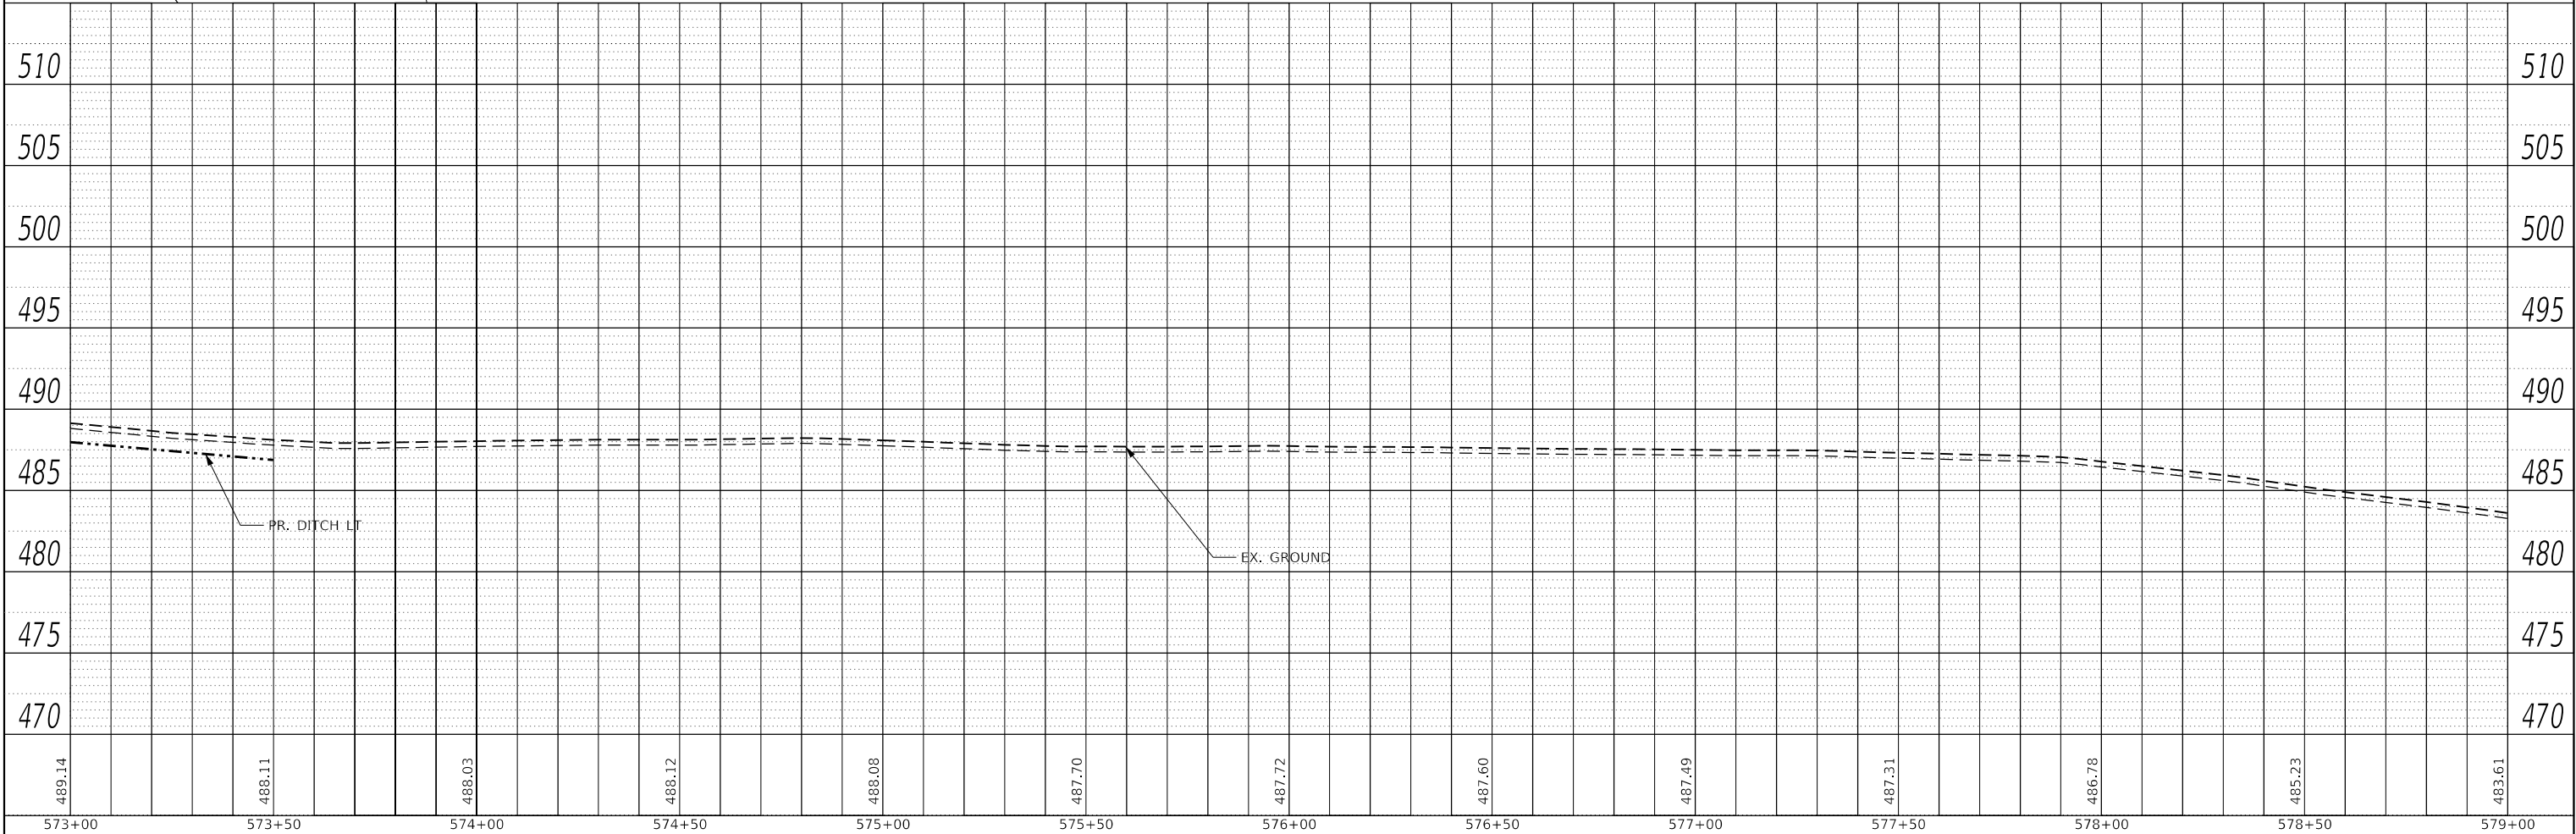

PLOTTED BY: esmith
FILE NAME: I30149-PinPr f028.dgn

DESIGNED - JRR		REVISED -		THOUVENOT, WADE & MOERCHEN, INC. SWANSEA • WATERLOO • EDWARDSVILLE • ST. LOUIS • ST. CHARLES	 EXCEPTIONAL SERVICE. NOTHING LESS.	 St Clair County Transit District	PLAN AND PROFILE ALIGNMENT 2		Orchard Loop Trail Phase 1	COUNTY	TOTAL SHEETS	SHEET NO.
DRAWN - EKS/TMG		REVISED -					ST. CLAIR	140		50		
CHECKED - JWS		REVISED -										
DATE - 03/2018		REVISED -										
PROJECT		JOB NO.		FED. ROAD DIST. NO.		ILLINOIS FED. AID PROJECT						
SCALE: 1" = 20'		SHEET NO. 14 OF 16 SHEETS		STA. 573+00.00 TO STA. 579+00.00								

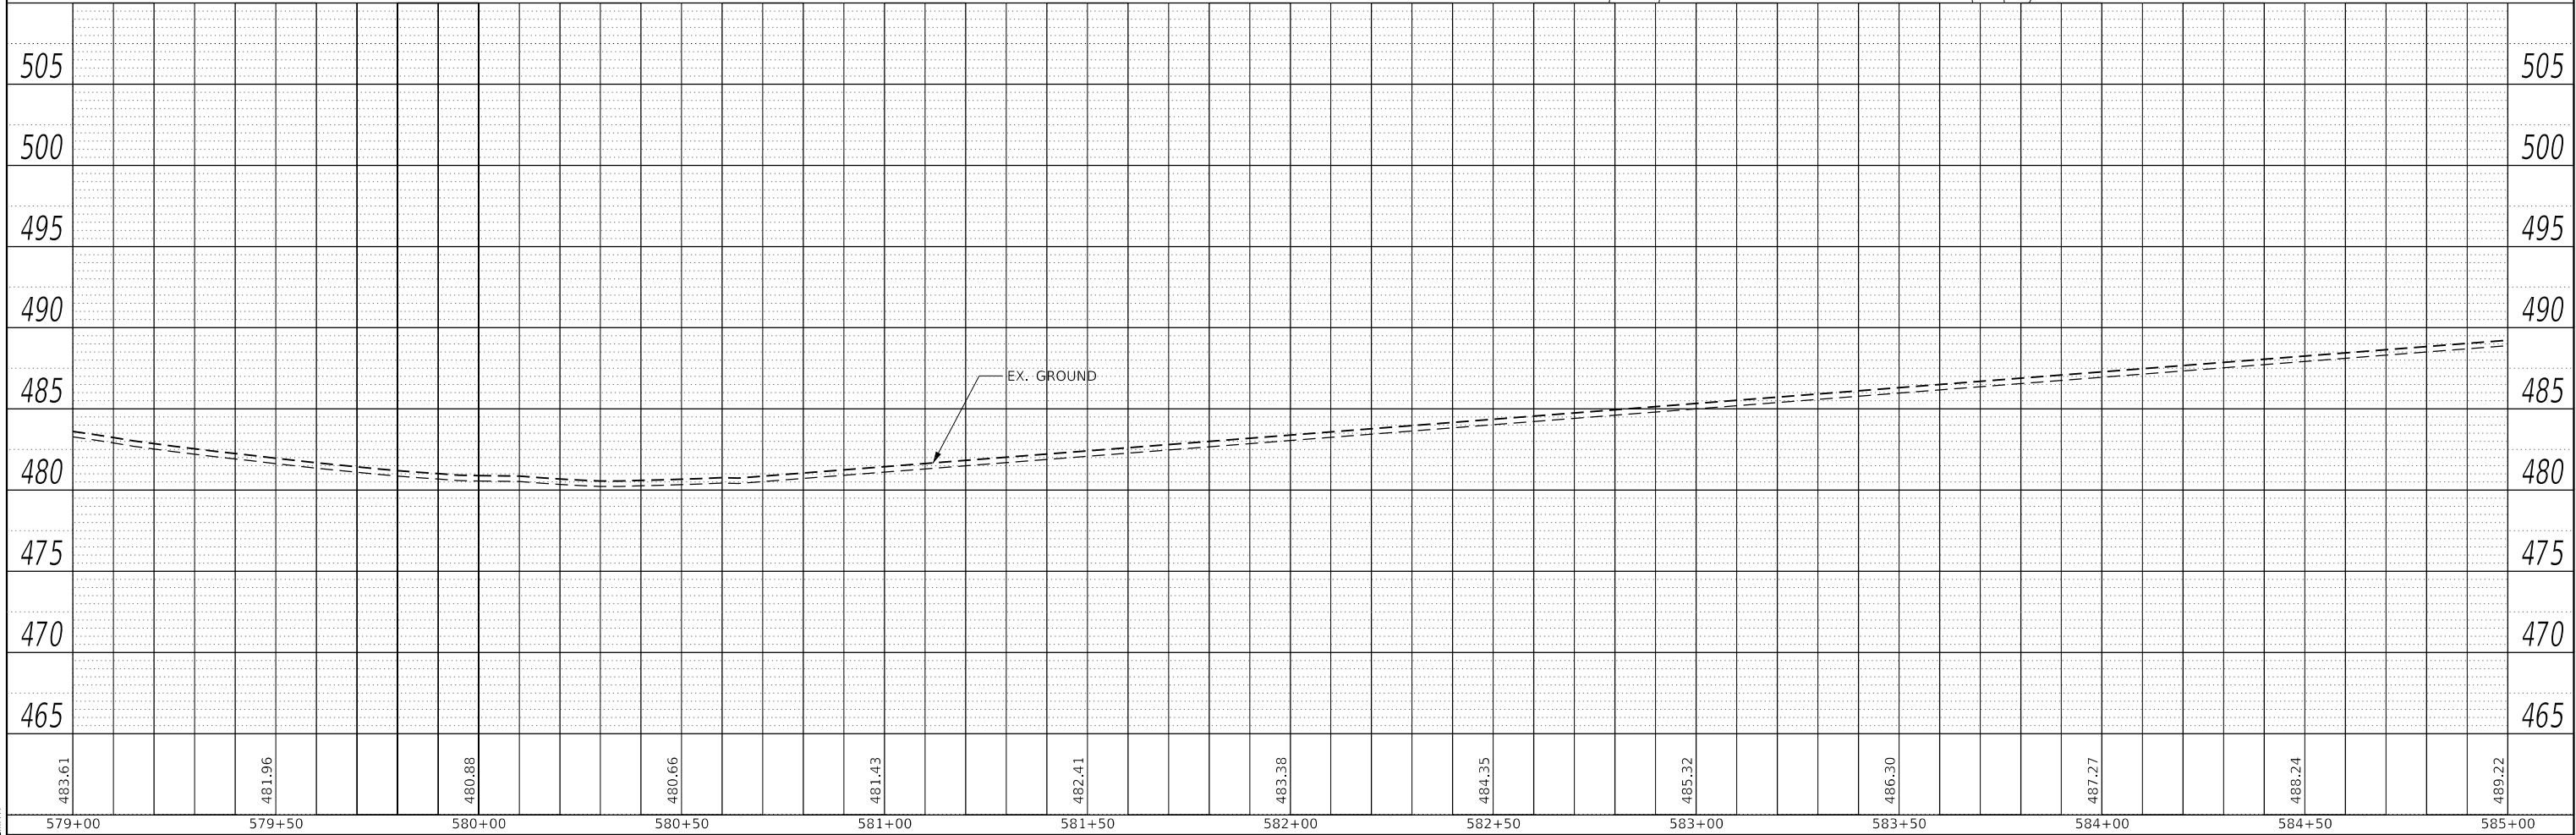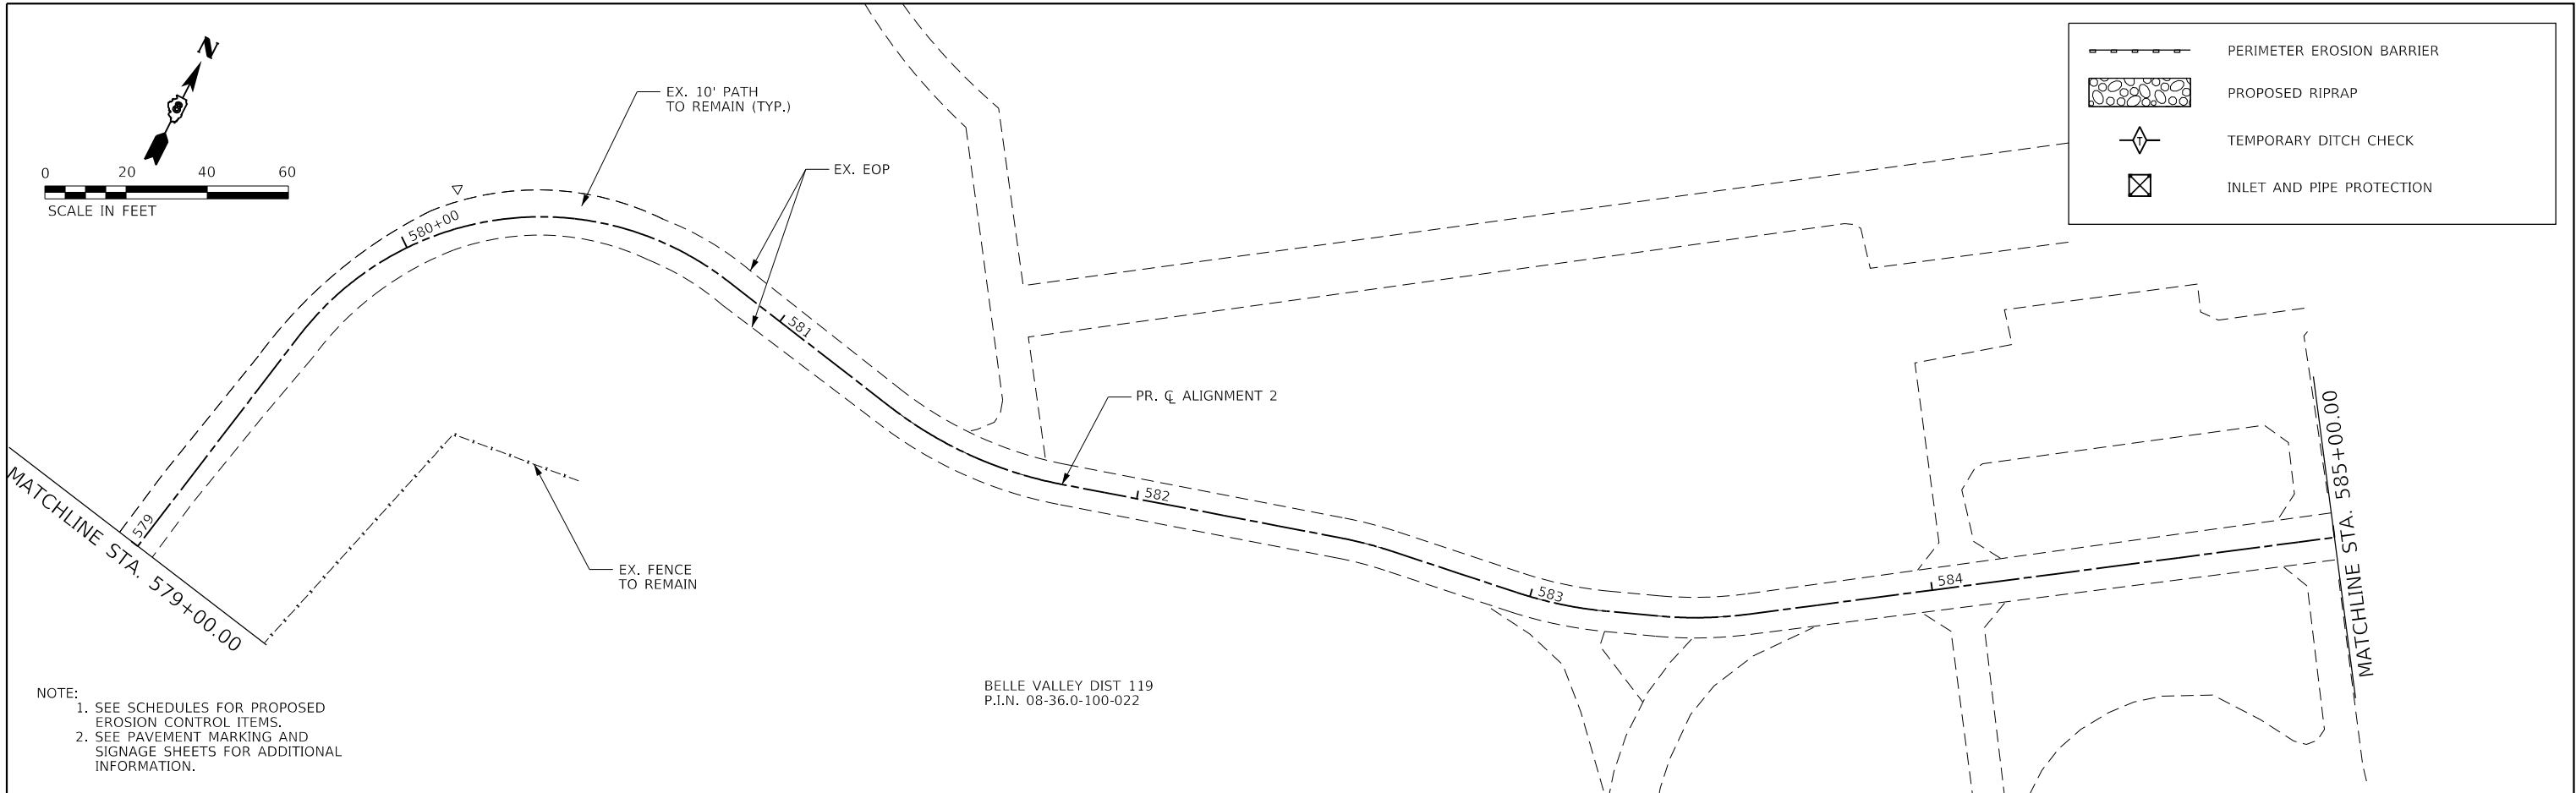

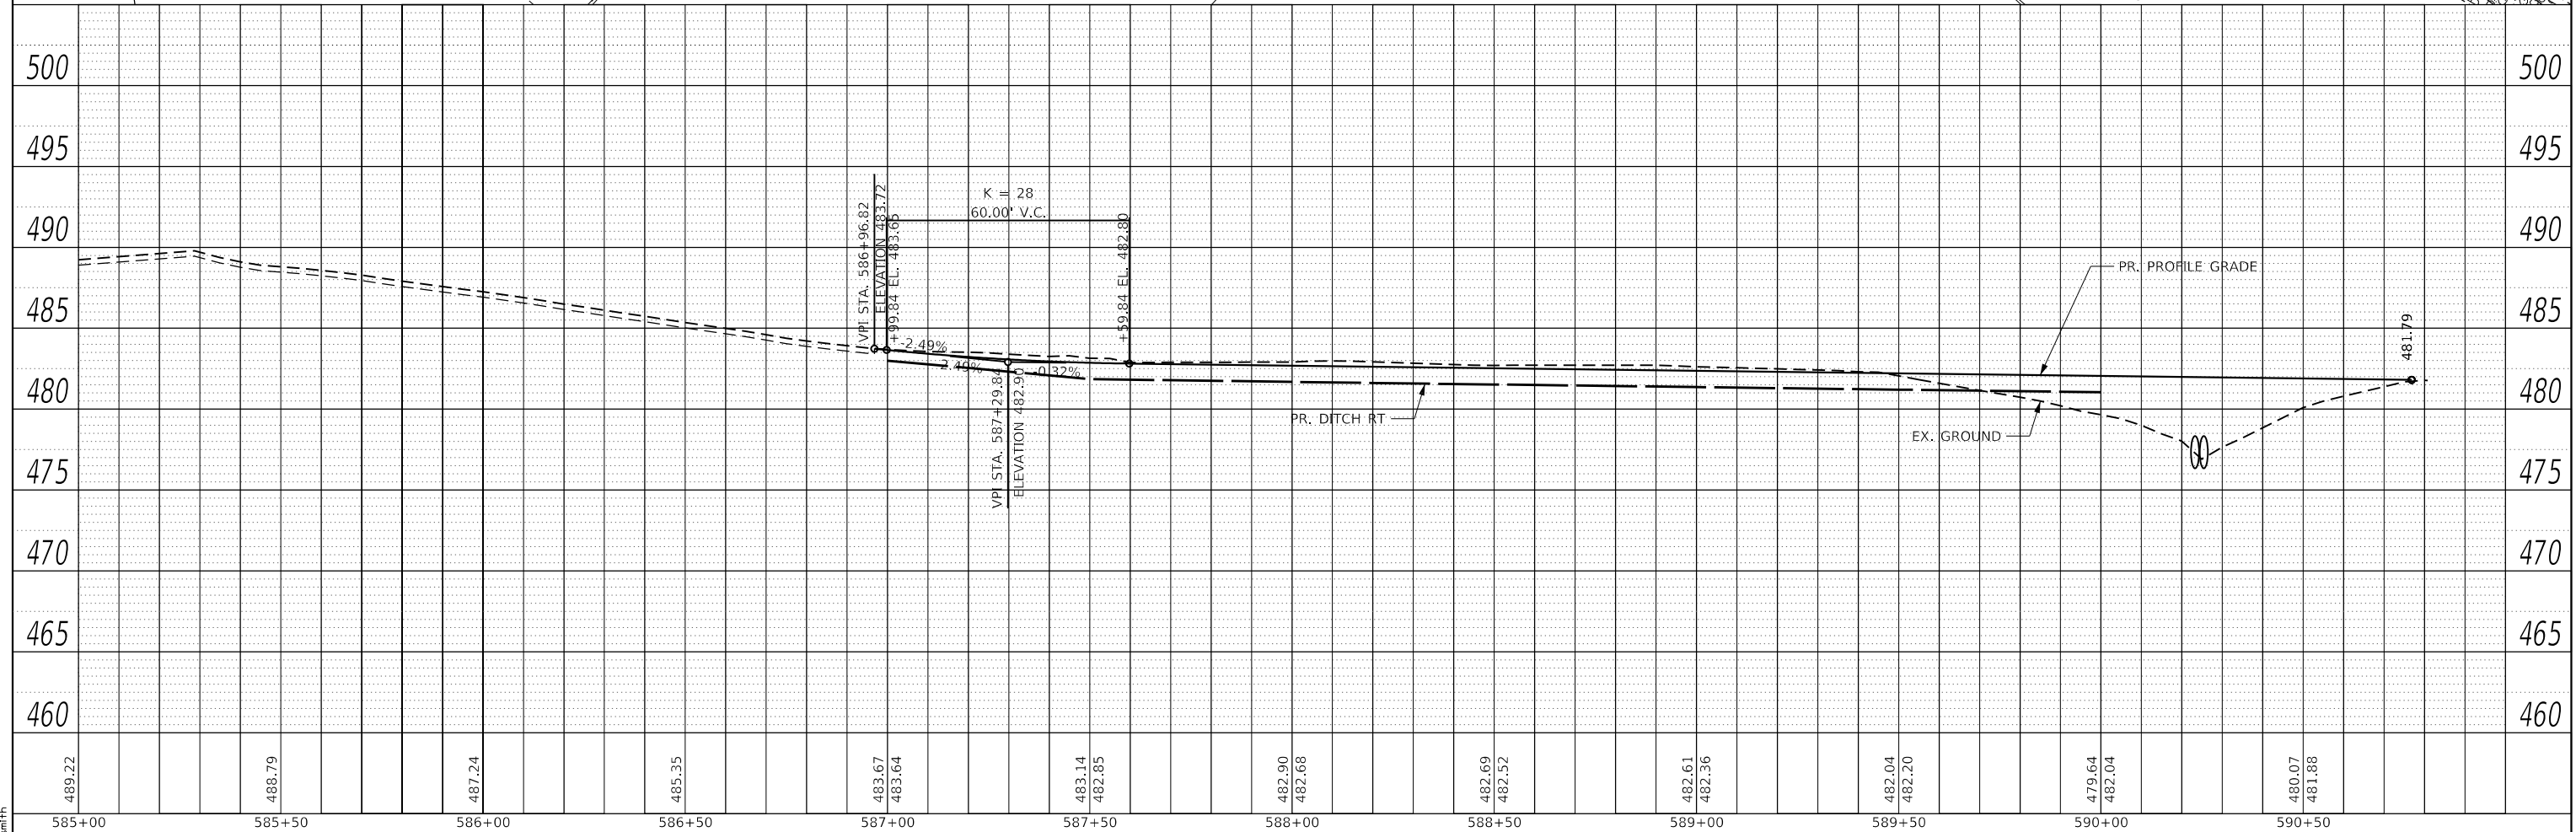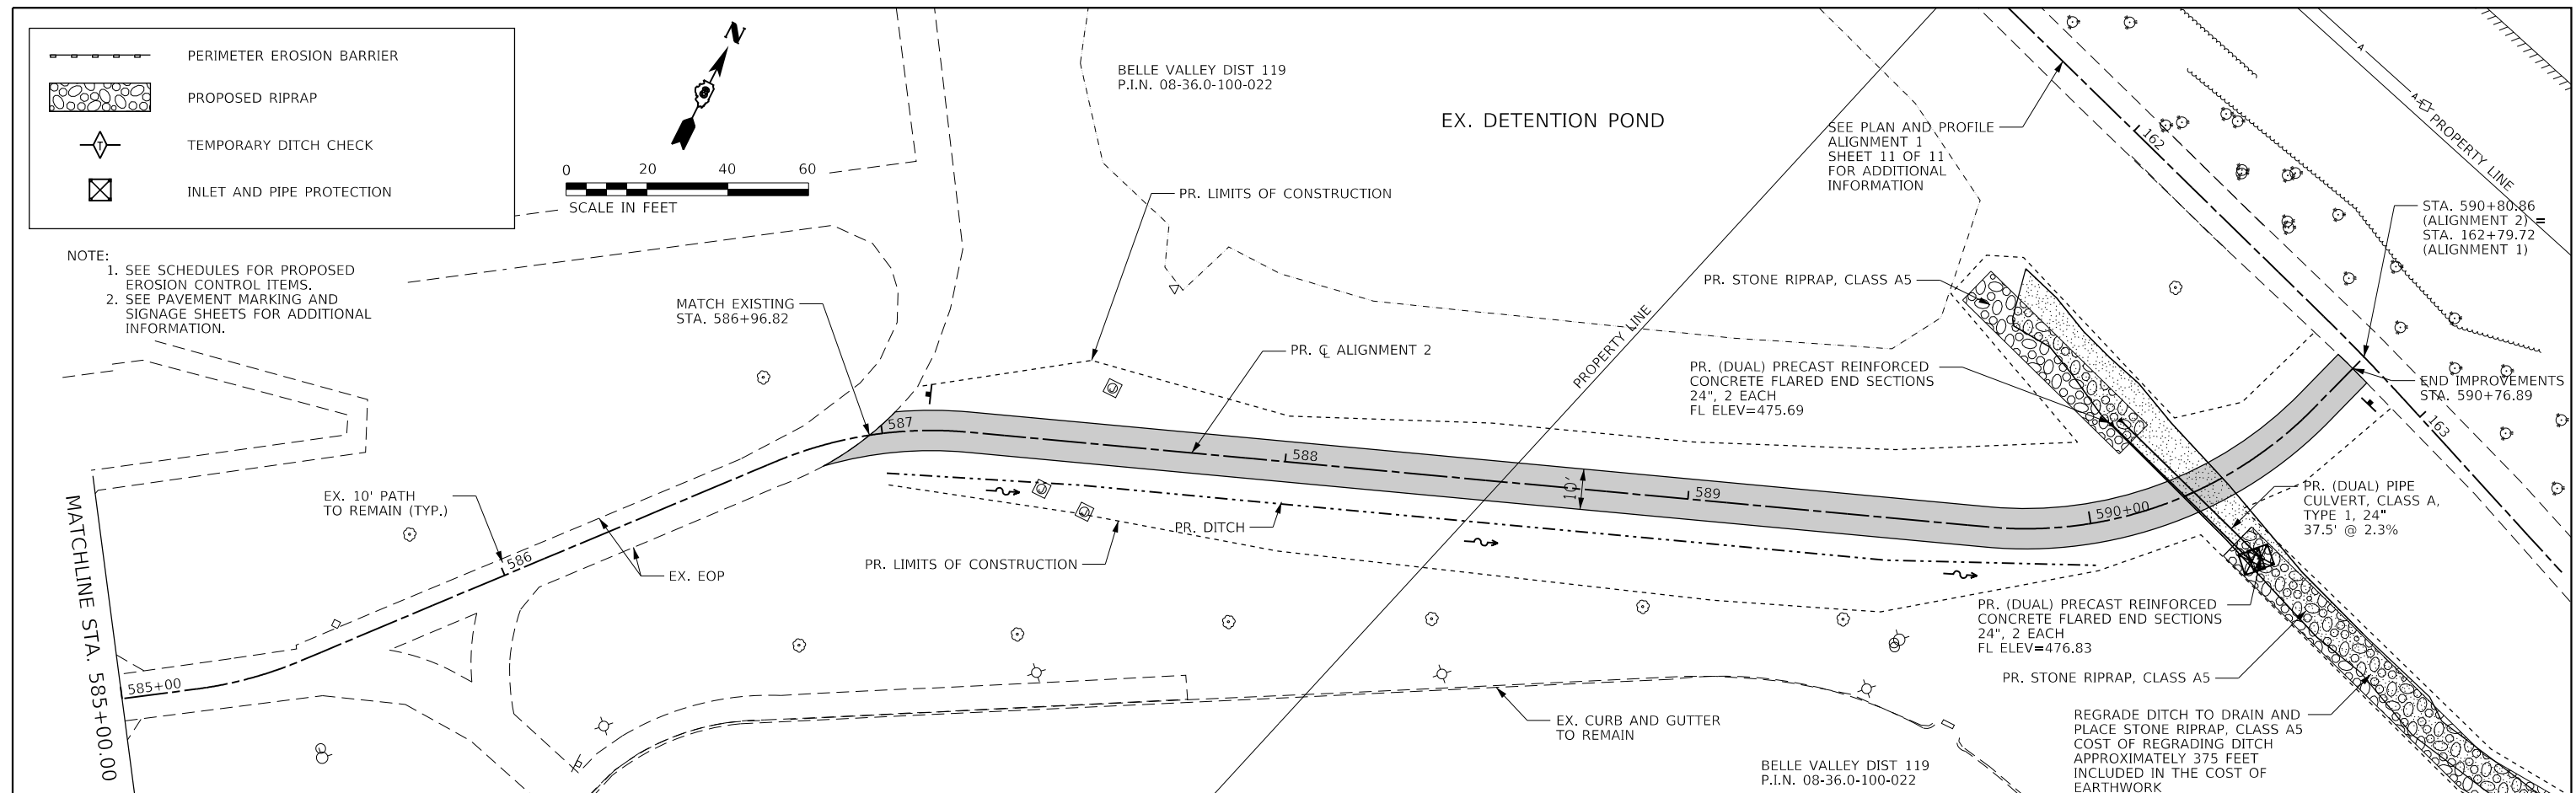

PLOTTED BY: esmith

FILE NAME: I30I49-PlnPr f030.dgn

DESIGNED - JRR	REVISED -
DRAWN - EKS/TMG	REVISED -
CHECKED - JWS	REVISED -
DATE - 03/2018	REVISED -

**THOUVENOT,
WADE &
MOERCHEN, INC.**

CORPORATE OFFICE
4940 Old Collinsville Road
Swansea, Illinois 62226
Tel: 618.624.4488
Fax: 618.624.6688

SWANSEA • WATERLOO • EDWARDSVILLE • ST. LOUIS • ST. CHARLES





St Clair
County
Transit
District


PLAN AND PROFILE ALIGNMENT 2

	PROJECT	JOB NO.
SCALE: 1" = 20'	SHEET NO. 16 OF 16 SHEETS	STA. 585+00.00 TO STA. 590+80.86

Orchard Loop Trail
Phase 1

COUNTY	TOTAL SHEETS	SHEET NO.
ST. CLAIR	140	52
ROAD PROJECT		

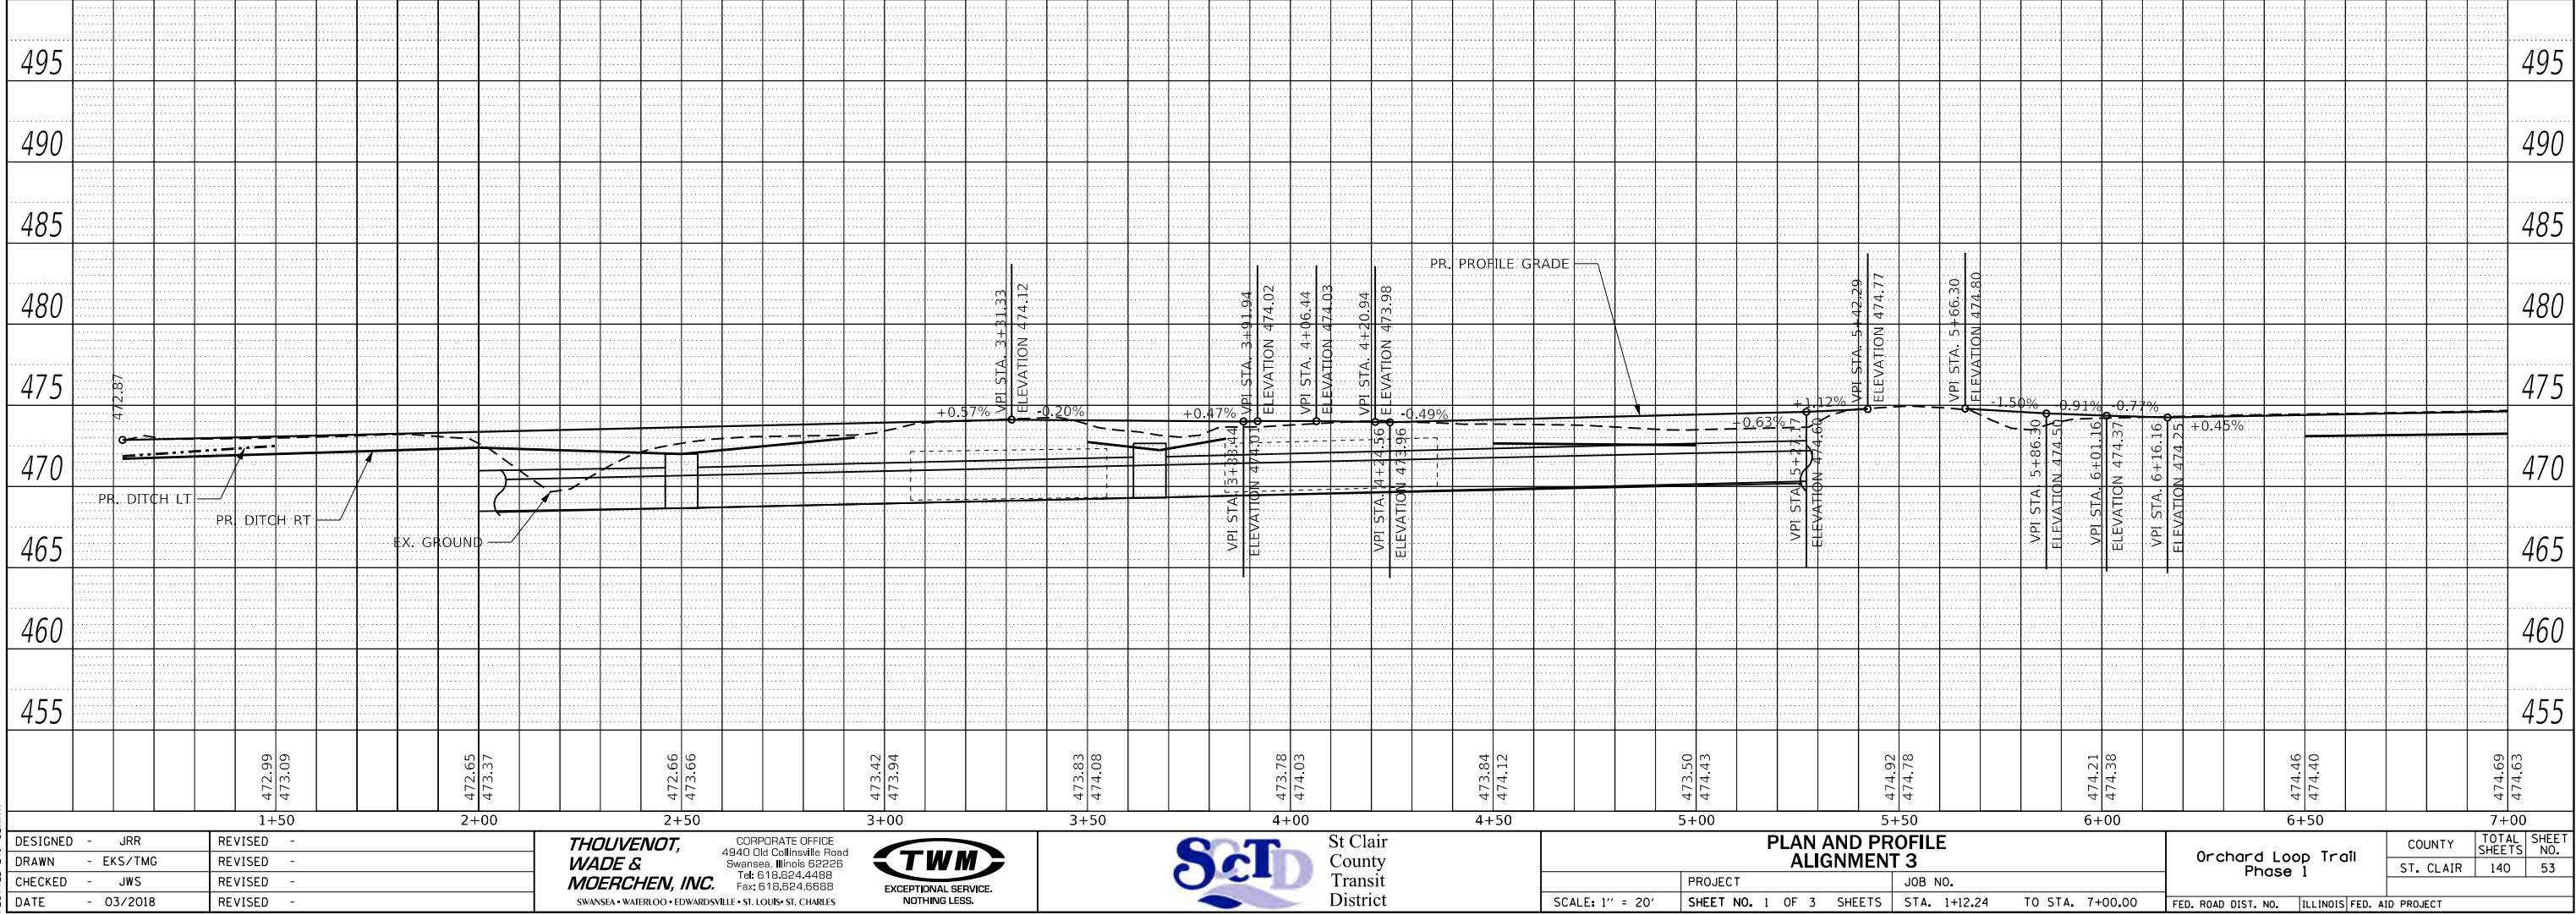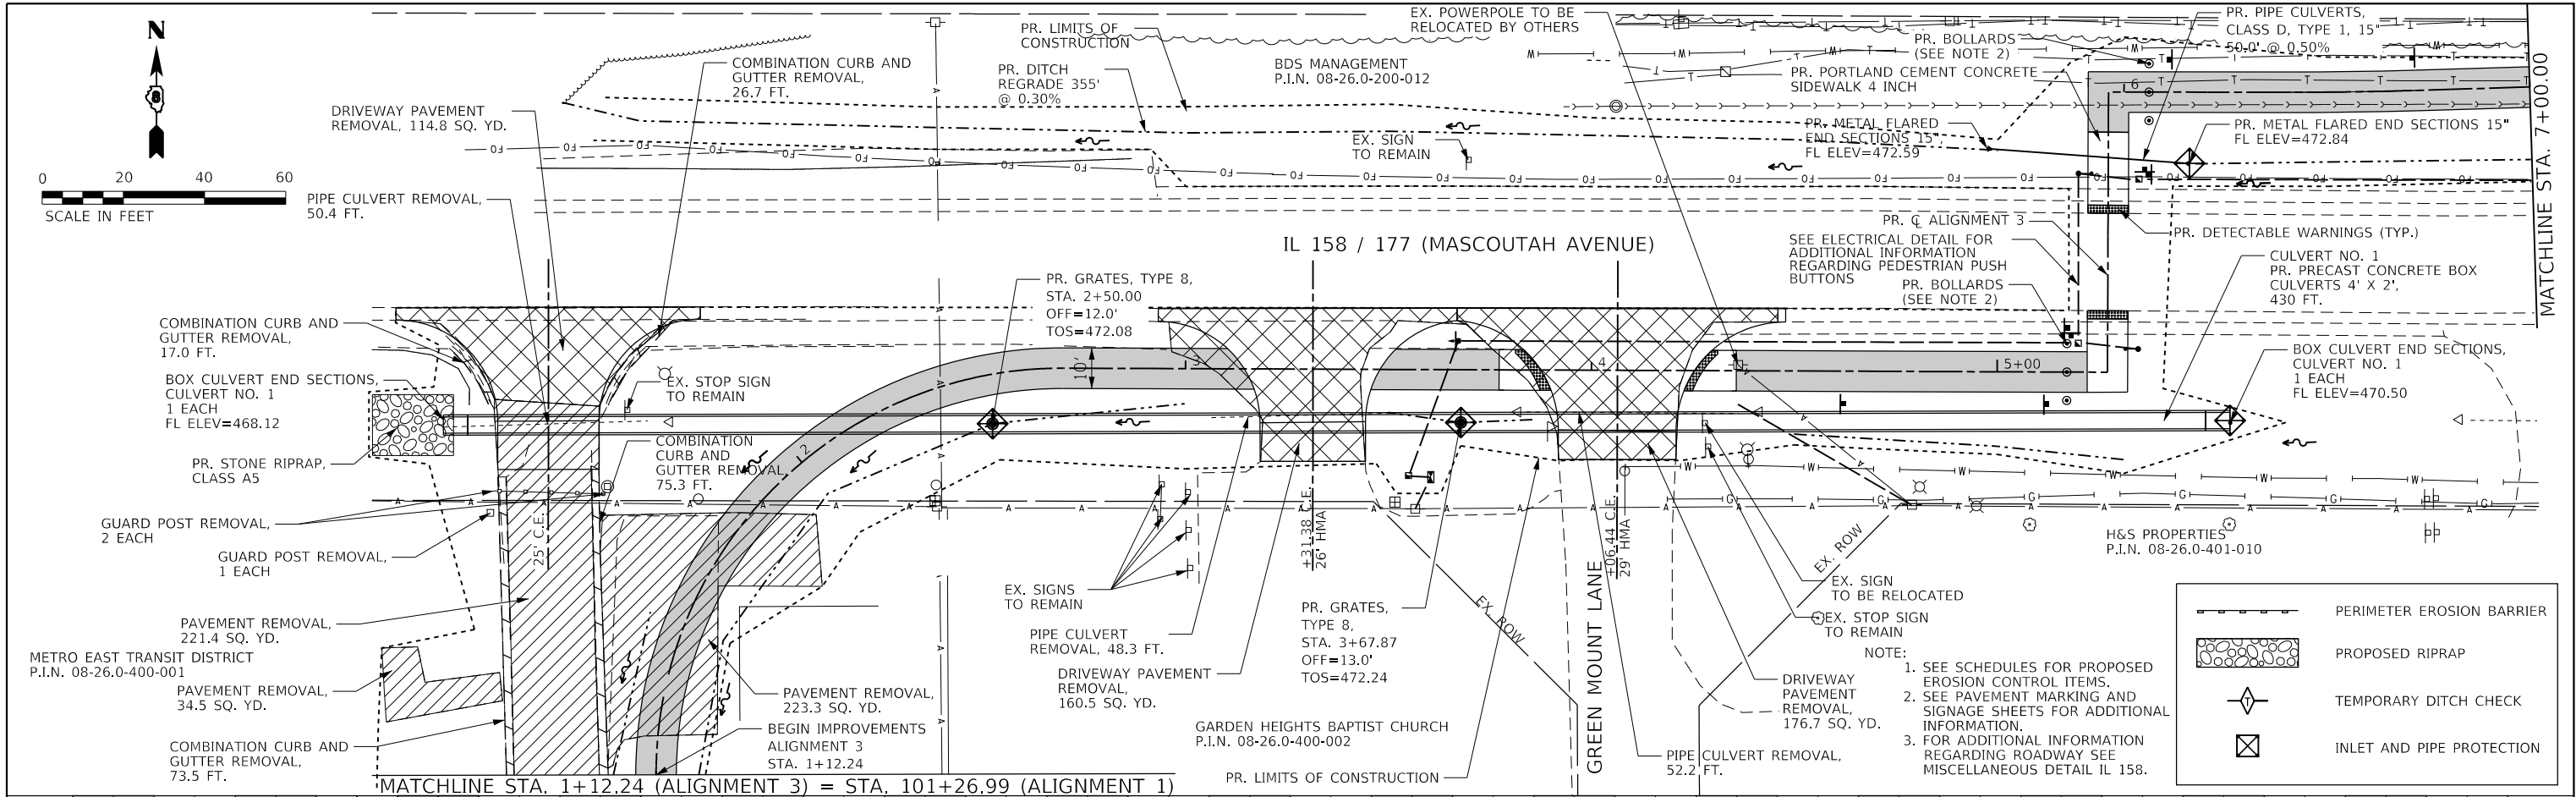

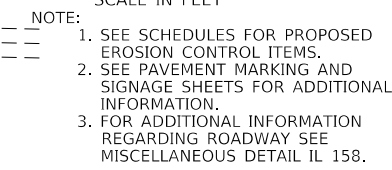

Orchard Loop Trail Phase 1	COUNTY	TOTAL SHEETS	SHEET NO.
	ST. CLAIR	140	54
FED. ROAD DIST. NO.	ILLINOIS	FED. AID PROJECT	

